


Keynote Legend	
Key Value	Keynote Text
2	FABRIC DUCT. COORDINATE SIZE, LOCATION AND ATTACHMENT WITH MECHANICAL DRAWINGS.
3	NEW RETURN AIR LOUVER. COORDINATE SIZE AND LOCATION WITH MECHANICAL DRAWINGS.
NOTE: REFER TO A 2.00 AND A3.00 FOR LOCATIONS AND EXTENT OF NEW METAL WALL PANEL(S) AND LINER PANEL(S).	

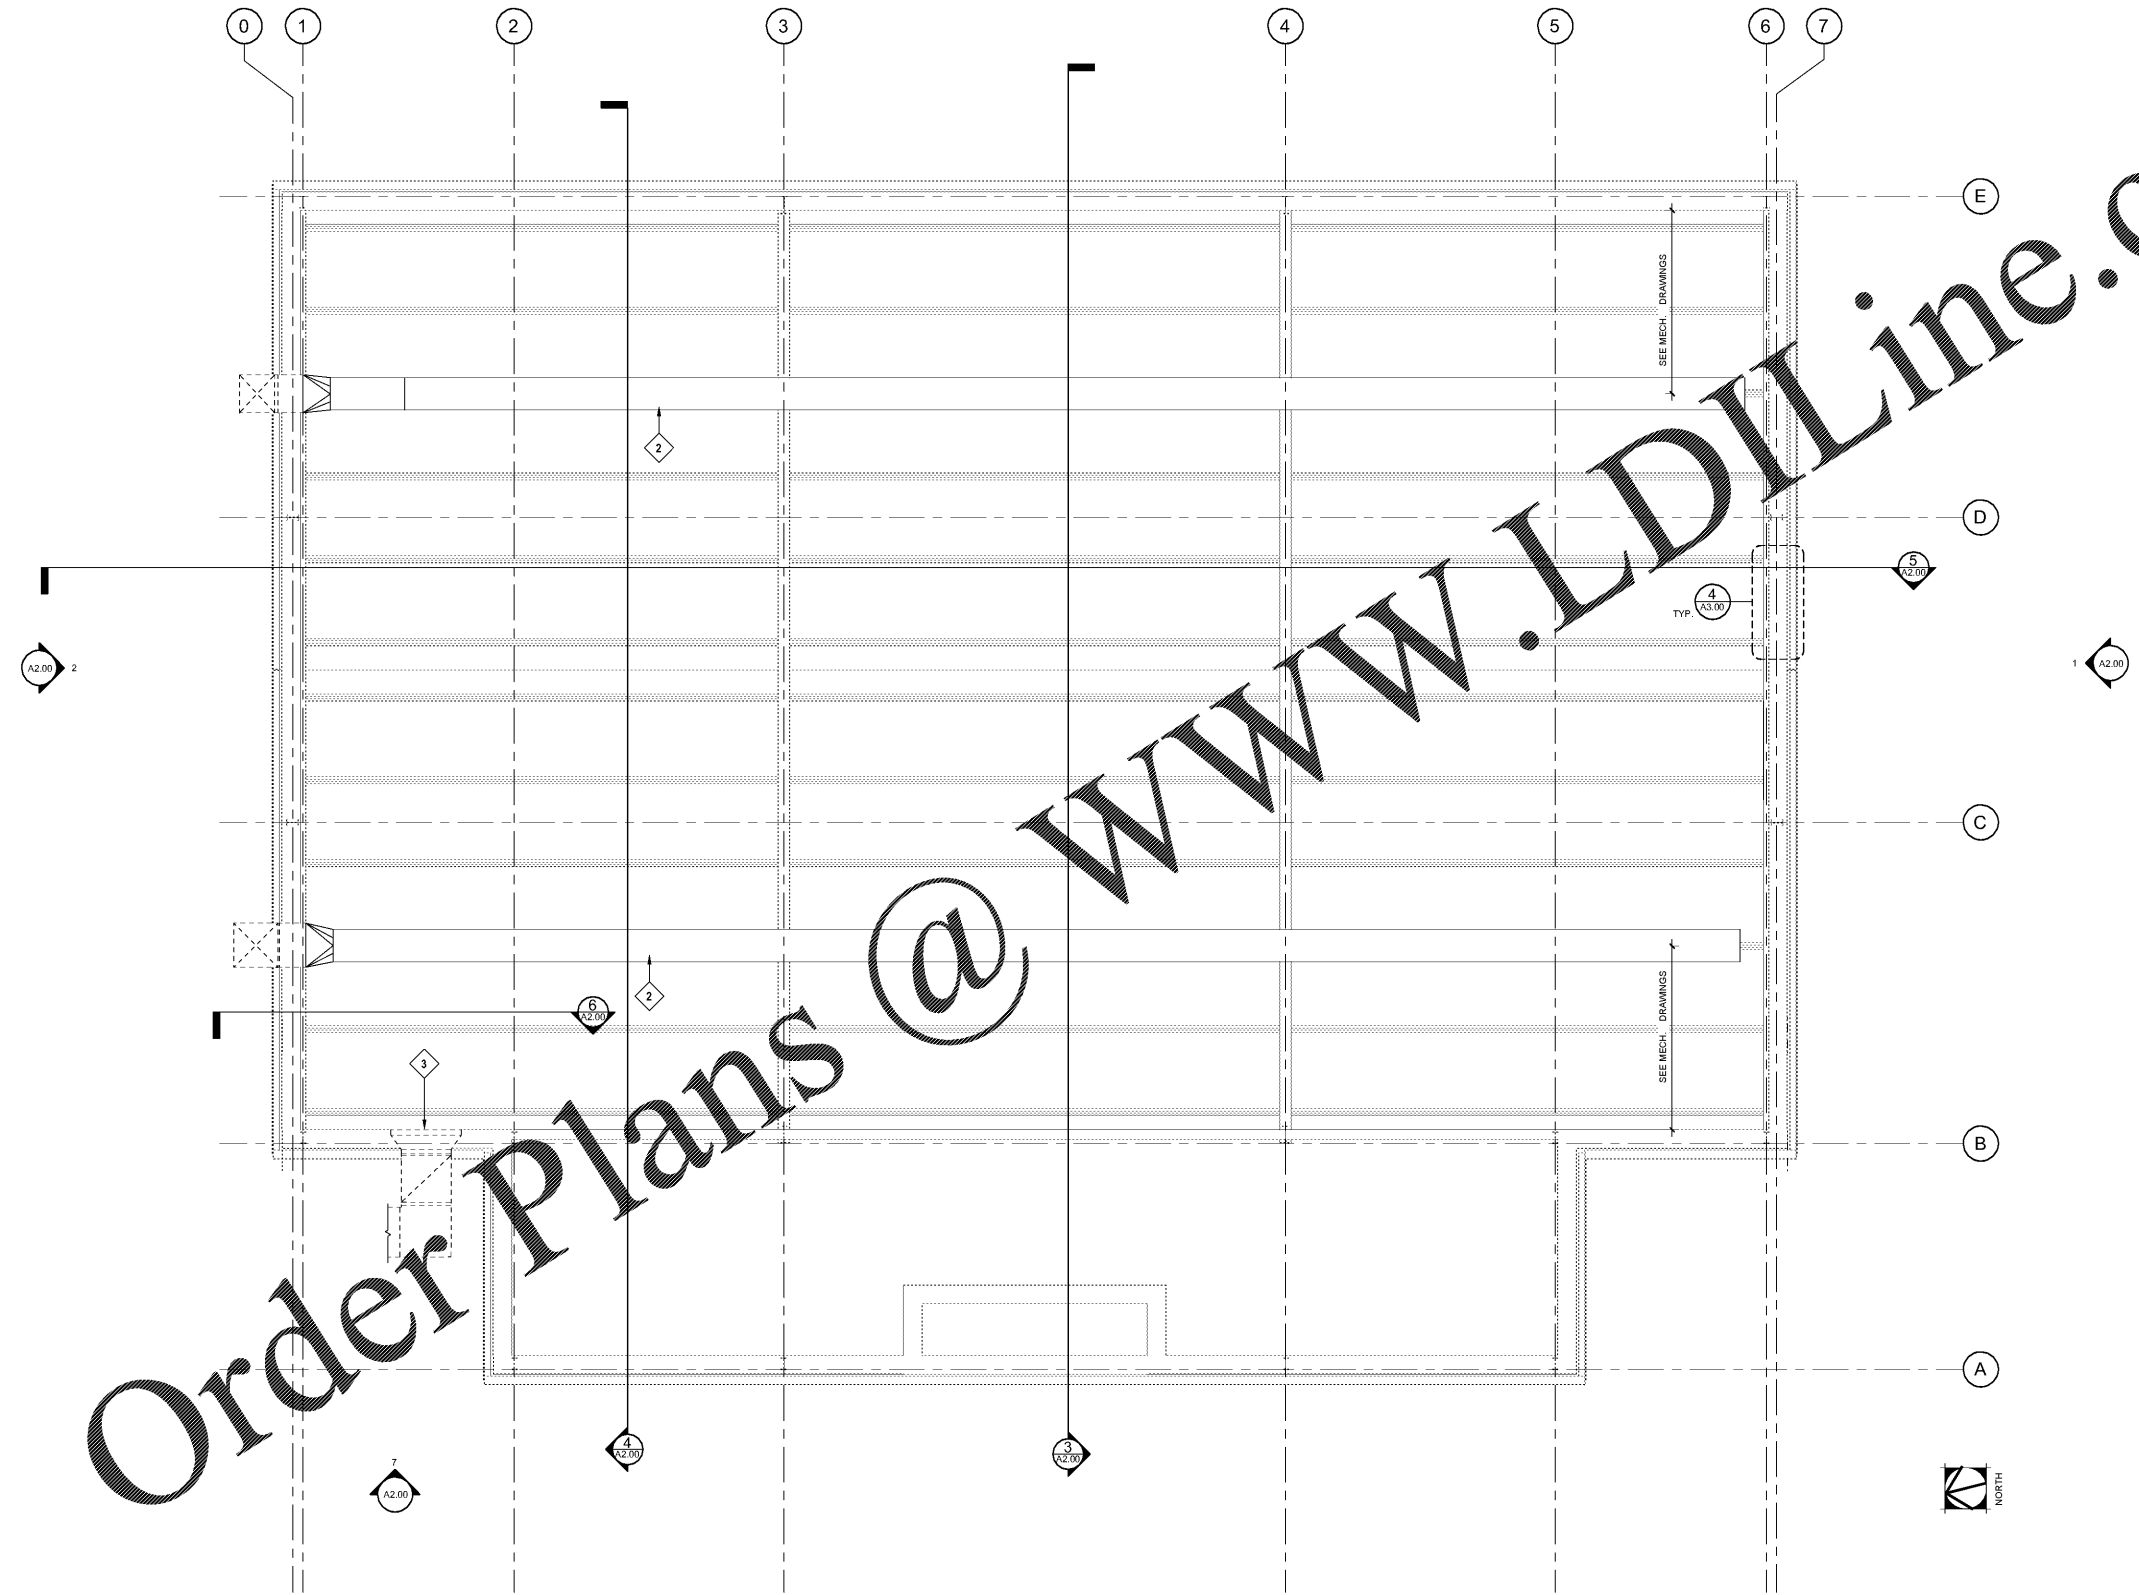

Order Plans @ www.LDILine.com

1 REFLECTED CEILING PLAN
1/4" = 1'-0"

BROCKETT ELEMENTARY SCHOOL
GYM HVAC DESIGN
1855 Brockett Road
Tucker, Georgia 30084

STANLEY LOVE STANLEY P A C
ARCHITECTURE
INTERIORS PLANNING
PROGRAM MANAGEMENT
1886 SPRING STREET, N.W.
ATLANTA, GEORGIA 30388
404-875-0508
www.stanleylove-stanley.com

DRAWING TITLE
REFLECTED CEILING PLAN



CONSULTANT

SCALES AS STATED HEREON ARE VALID ON THE ORIGINAL DRAWING. THE DIMENSIONS OF WHICH ARE SHOWN ON THE SCALY. NOTED HEREON ARE HEREBY CHANGE BY THE PART OF THE OVERALL SHEET DIMENSIONS OF THE PRINT TO CORRESPONDING DIMENSIONS OF THE ORIGINAL DRAWING.

THIS DRAWING IS THE PROPERTY OF STANLEY LOVE STANLEY P.C. AND IS NOT TO BE REPRODUCED OR COPIED IN WHOLE OR IN PART. IT IS ON LY TO BE USED FOR THE PROJECT AND SITE SPECIFICALLY IDENTIFIED HEREON AND IS NOT TO BE USED ON ANY OTHER PROJECT. IT IS TO BE RETURNED UPON REQUEST.

COPYRIGHT © 2018. ALL RIGHTS RESERVED
STANLEY LOVE STANLEY P.C.
DRAWING NO.

DATE
01/06/2020

PROJECT NO.
6919.9

DRAWING NO.

A1.10