

100% CD SET	01/31/2020

ELDRIDGE L. MILLER ELEMENTARY SCHOOL GYM HVAC DESIGN
 919 Martin Road
 Stone Mountain, Georgia 30088

STANLEY LOVE STANLEY P R C
 ARCHITECTURE
 INTERIORS PLANNING
 PROGRAM MANAGEMENT
 1186 SPRING STREET, N.W.
 ATLANTA, GEORGIA 30309
 404-875-0508
 404-875-0817
 www.stanleylove-stanleyprc.com

DRAWING TITLE
EXTERIOR ELEVATIONS & BUILDING SECTIONS - DEMOLITION


PROFESSIONAL SEAL

CONSULTANT


SCALES AS STATED HEREON ARE VALID ON THE ORIGINAL DRAWING. THE DIMENSIONS OF WHICH ARE SHOWN HEREON. THE SCALES NOTED HEREON ARE HEREBY CHANGE BY THE RATIO OF THE OVERALL SHEET DIMENSIONS OF THE PRINT TO CORRESPONDING DIMENSIONS OF THE ORIGINAL DRAWING.
 THE DRAWING IS THE PROPERTY OF STANLEY LOVE STANLEY P.C. AND IS NOT TO BE REPRODUCED OR COPIED IN WHOLE OR IN PART. IT IS OK TO BE USED FOR THE PROJECT AND SITE SPECIFICALLY IDENTIFIED HEREON AND IS NOT TO BE USED ON ANY OTHER PROJECT. IT IS TO BE RETURNED UPON REQUEST.
 COPYRIGHT © 2018. ALL RIGHTS RESERVED
 STANLEY LOVE STANLEY P.C.
 DRAWING NO.

DATE
 01/31/2020
 PROJECT NO.
 6919.1
 DRAWING NO.


AD2.00

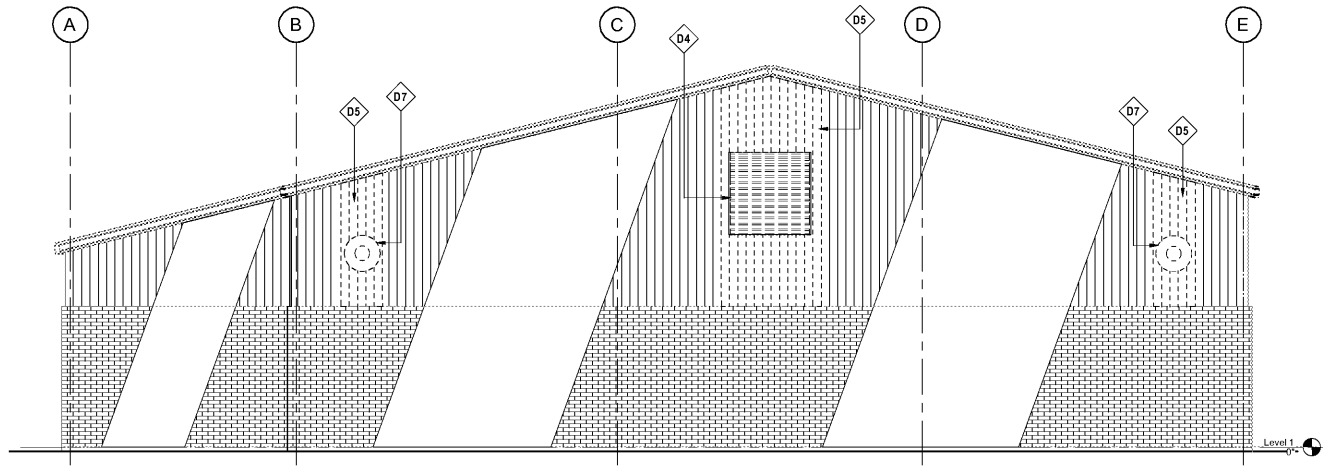


1 DEMOLITION NORTH ELEVATION
 1/4" = 1'-0"

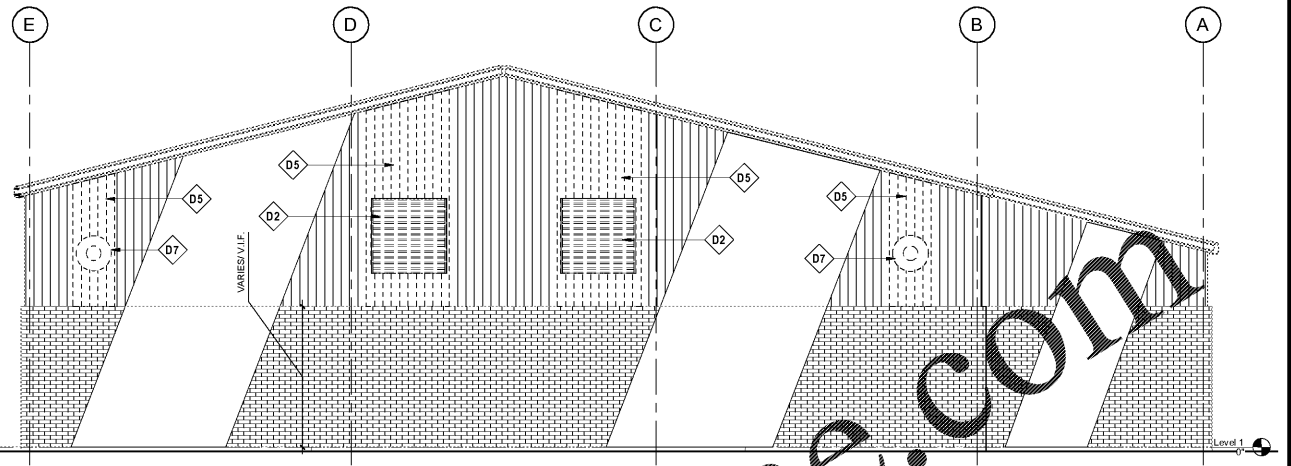

2 DEMOLITION SOUTH ELEVATION
 1/4" = 1'-0"

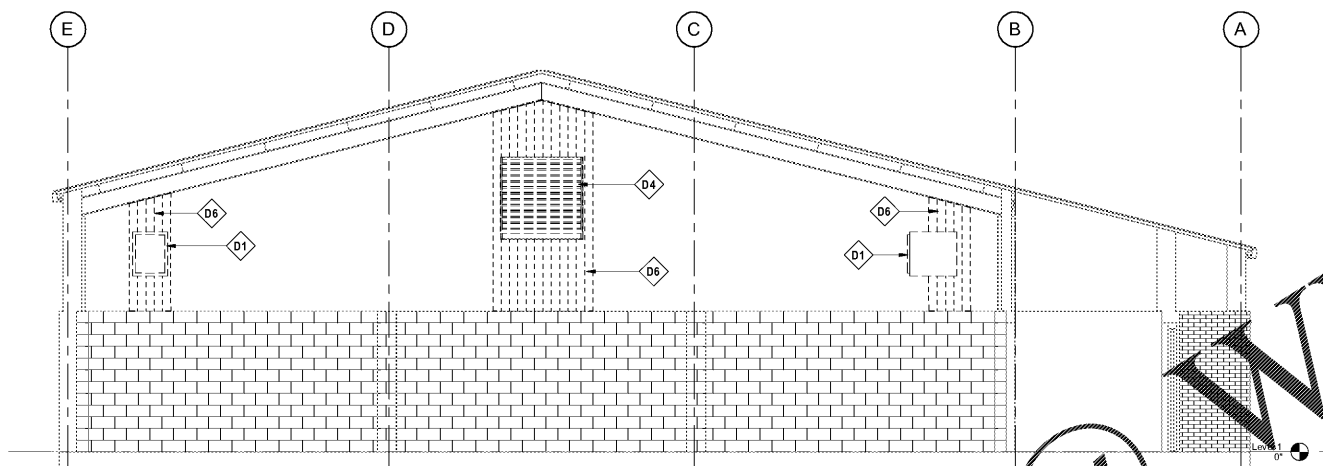

3 DEMOLITION SECTION 3
 1/4" = 1'-0"

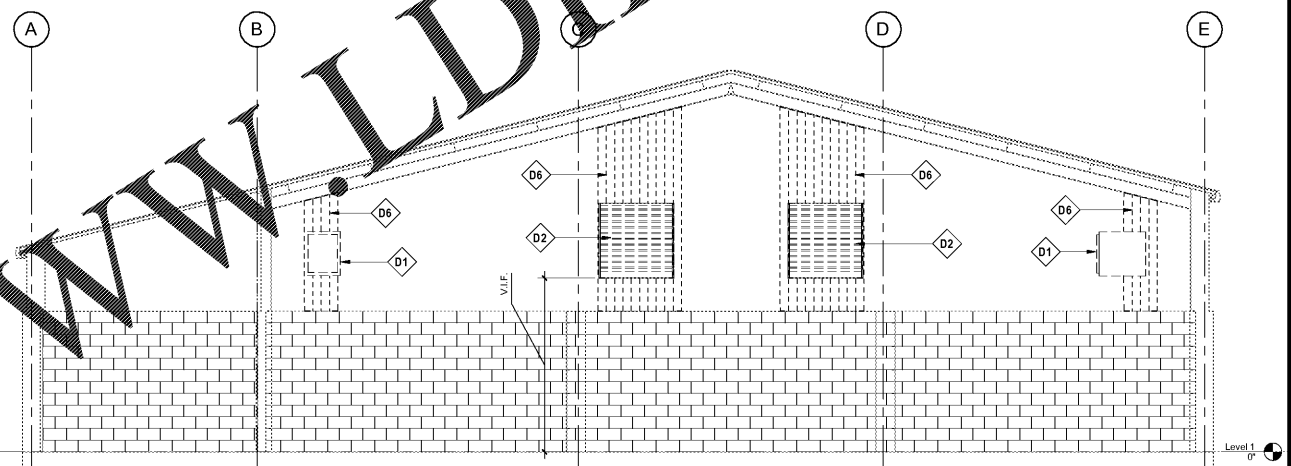

4 DEMOLITION SECTION 4
 1/4" = 1'-0"

Order Plans @ www.LDILine.com

Keynote Legend	
Key Value	Keynote Text
D1	REMOVE EXISTING GAS-FIRED UNIT HEATERS. SEE MECHANICAL DRAWINGS.
D2	REMOVE EXISTING INTAKE LOUVER SYSTEM TO EXTENT INDICATED. SEE MECHANICAL DRAWINGS.
D4	REMOVE EXISTING WALL-MOUNTED EXHAUST FAN SYSTEM TO EXTENT INDICATED. SEE MECHANICAL DRAWINGS.
D5	REMOVE FULL METAL WALL PANEL(S) IN THIS AREA, AS REQUIRED, FOR INSTALLATION OF NEW EXTERIOR METAL WALL PANEL(S).
D6	REMOVE FULL LINER WALL PANEL(S) IN THIS AREA, AS REQUIRED, FOR INSTALLATION OF NEW METAL LINER PANEL(S).
D7	REMOVE GAS HEATER VENT PIPING THROUGH WALL. FIELD VERIFY LOCATION. SEE PLUMBING DRAWINGS.