


Keynote Legend	
Key Value	Keynote Text
6	AIR HANDLING UNIT. SEE MECHANICAL DRAWINGS.
7	CONCRETE PAD. SEE CIVIL AND MECHANICAL DRAWINGS.
8	CHAIN LINK FENCE. SEE CIVIL DRAWINGS.
17	NEW EXTERIOR SUPPLY AIR DUCTWORK AND SUPPORT AS SHOWN ON DETAILS 7, 9 AND 10 ON MECHANICAL DRAWING M-401.

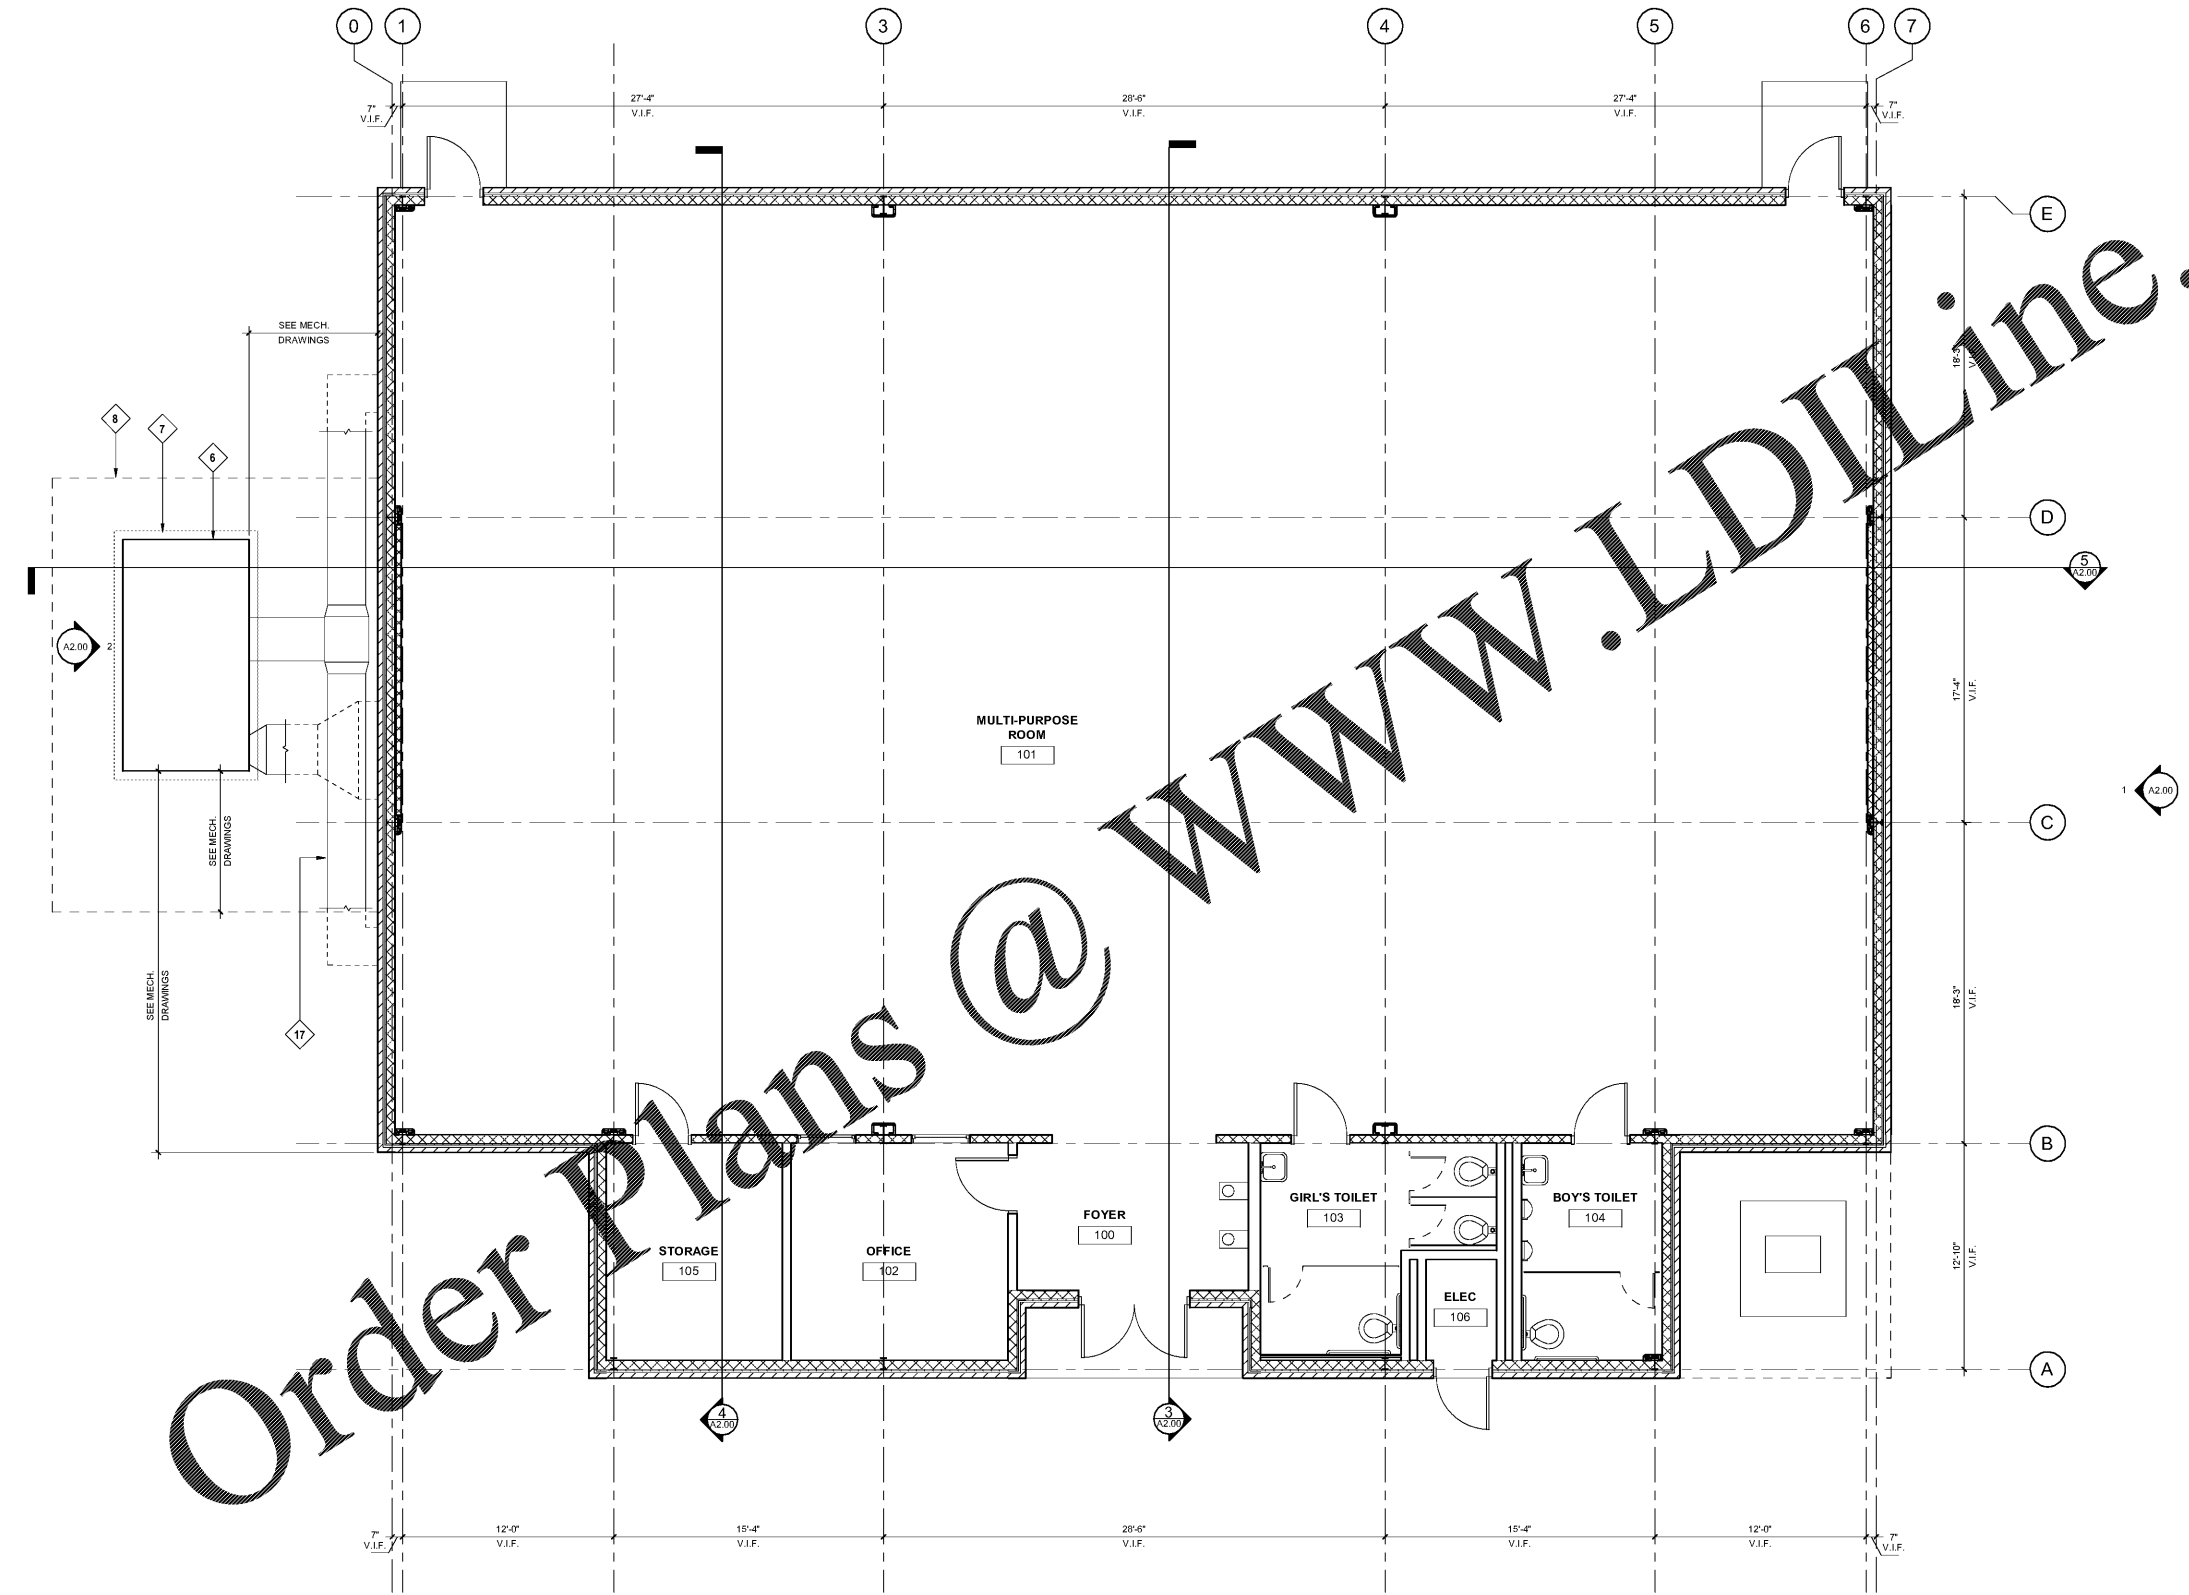

Order Plans @ [www.LDILine.com](http://www.LDILine.com)

**ELDRIDGE L. MILLER ELEMENTARY SCHOOL GYM HVAC DESIGN**  
 919 Martin Road  
 Stone Mountain, Georgia 30088

**STANLEY LOVE STANLEY P A C**  
 ARCHITECTURE  
 INTERIORS PLANNING  
 PROGRAM MANAGEMENT  
 1586 SPRING STREET, N.W.  
 ATLANTA, GEORGIA 30309  
 404-875-0508  
 www.stanleylove.com

DRAWING TITLE  
**FLOOR PLAN**

PROFESSIONAL SEAL

CONSULTANT

SCALES AS STATED HEREON ARE VALID ON THE ORIGINAL DRAWING. THE DIMENSIONS OF WHICH ARE SHOWN ON THE SCALY. NOTED HEREON ARE HEREBY CHANGE BY THE PART OF THE OVERALL SHEET DIMENSIONS OF THE PRINT TO CORRESPONDING DIMENSIONS OF THE ORIGINAL DRAWING.

THIS DRAWING IS THE PROPERTY OF STANLEY LOVE STANLEY P.A.C. AND IS NOT TO BE REPRODUCED OR COPIED IN WHOLE OR IN PART. IT IS ON LY TO BE USED FOR THE PROJECT AND SITE SPECIFICALLY IDENTIFIED HEREON AND IS NOT TO BE USED ON ANY OTHER PROJECT. IT IS TO BE RETURNED UPON REQUEST.

COPYRIGHT © 2018. ALL RIGHTS RESERVED.  
 STANLEY LOVE STANLEY P.A.C.  
 DRAWING NO.

DATE  
 01/31/2020  
 PROJECT NO.  
 6919.1  
 DRAWING NO.

**A1.00**

1/31/2020 3:33:32 PM

1 FLOOR PLAN  
 1/4" = 1'-0"



RELEASED FOR CONSTRUCTION 01/31/2020