


Keynote Legend	
Key Value	Keynote Text
2	FABRIC DUCT. COORDINATE SIZE, LOCATION AND ATTACHMENT WITH MECHANICAL DRAWINGS.
3	NEW RETURN AIR LOUVER. COORDINATE SIZE AND LOCATION WITH MECHANICAL DRAWINGS.
17	NEW EXTERIOR SUPPLY AIR DUCTWORK AND SUPPORT AS SHOWN ON DETAILS 7, 9 AND 10 ON MECHANICAL DRAWING M-401.
NOTE: REFER TO A 2.00 AND A3.00 FOR LOCATIONS AND EXTENT OF NEW METAL WALL PANEL(S) AND LINER PANEL(S).	

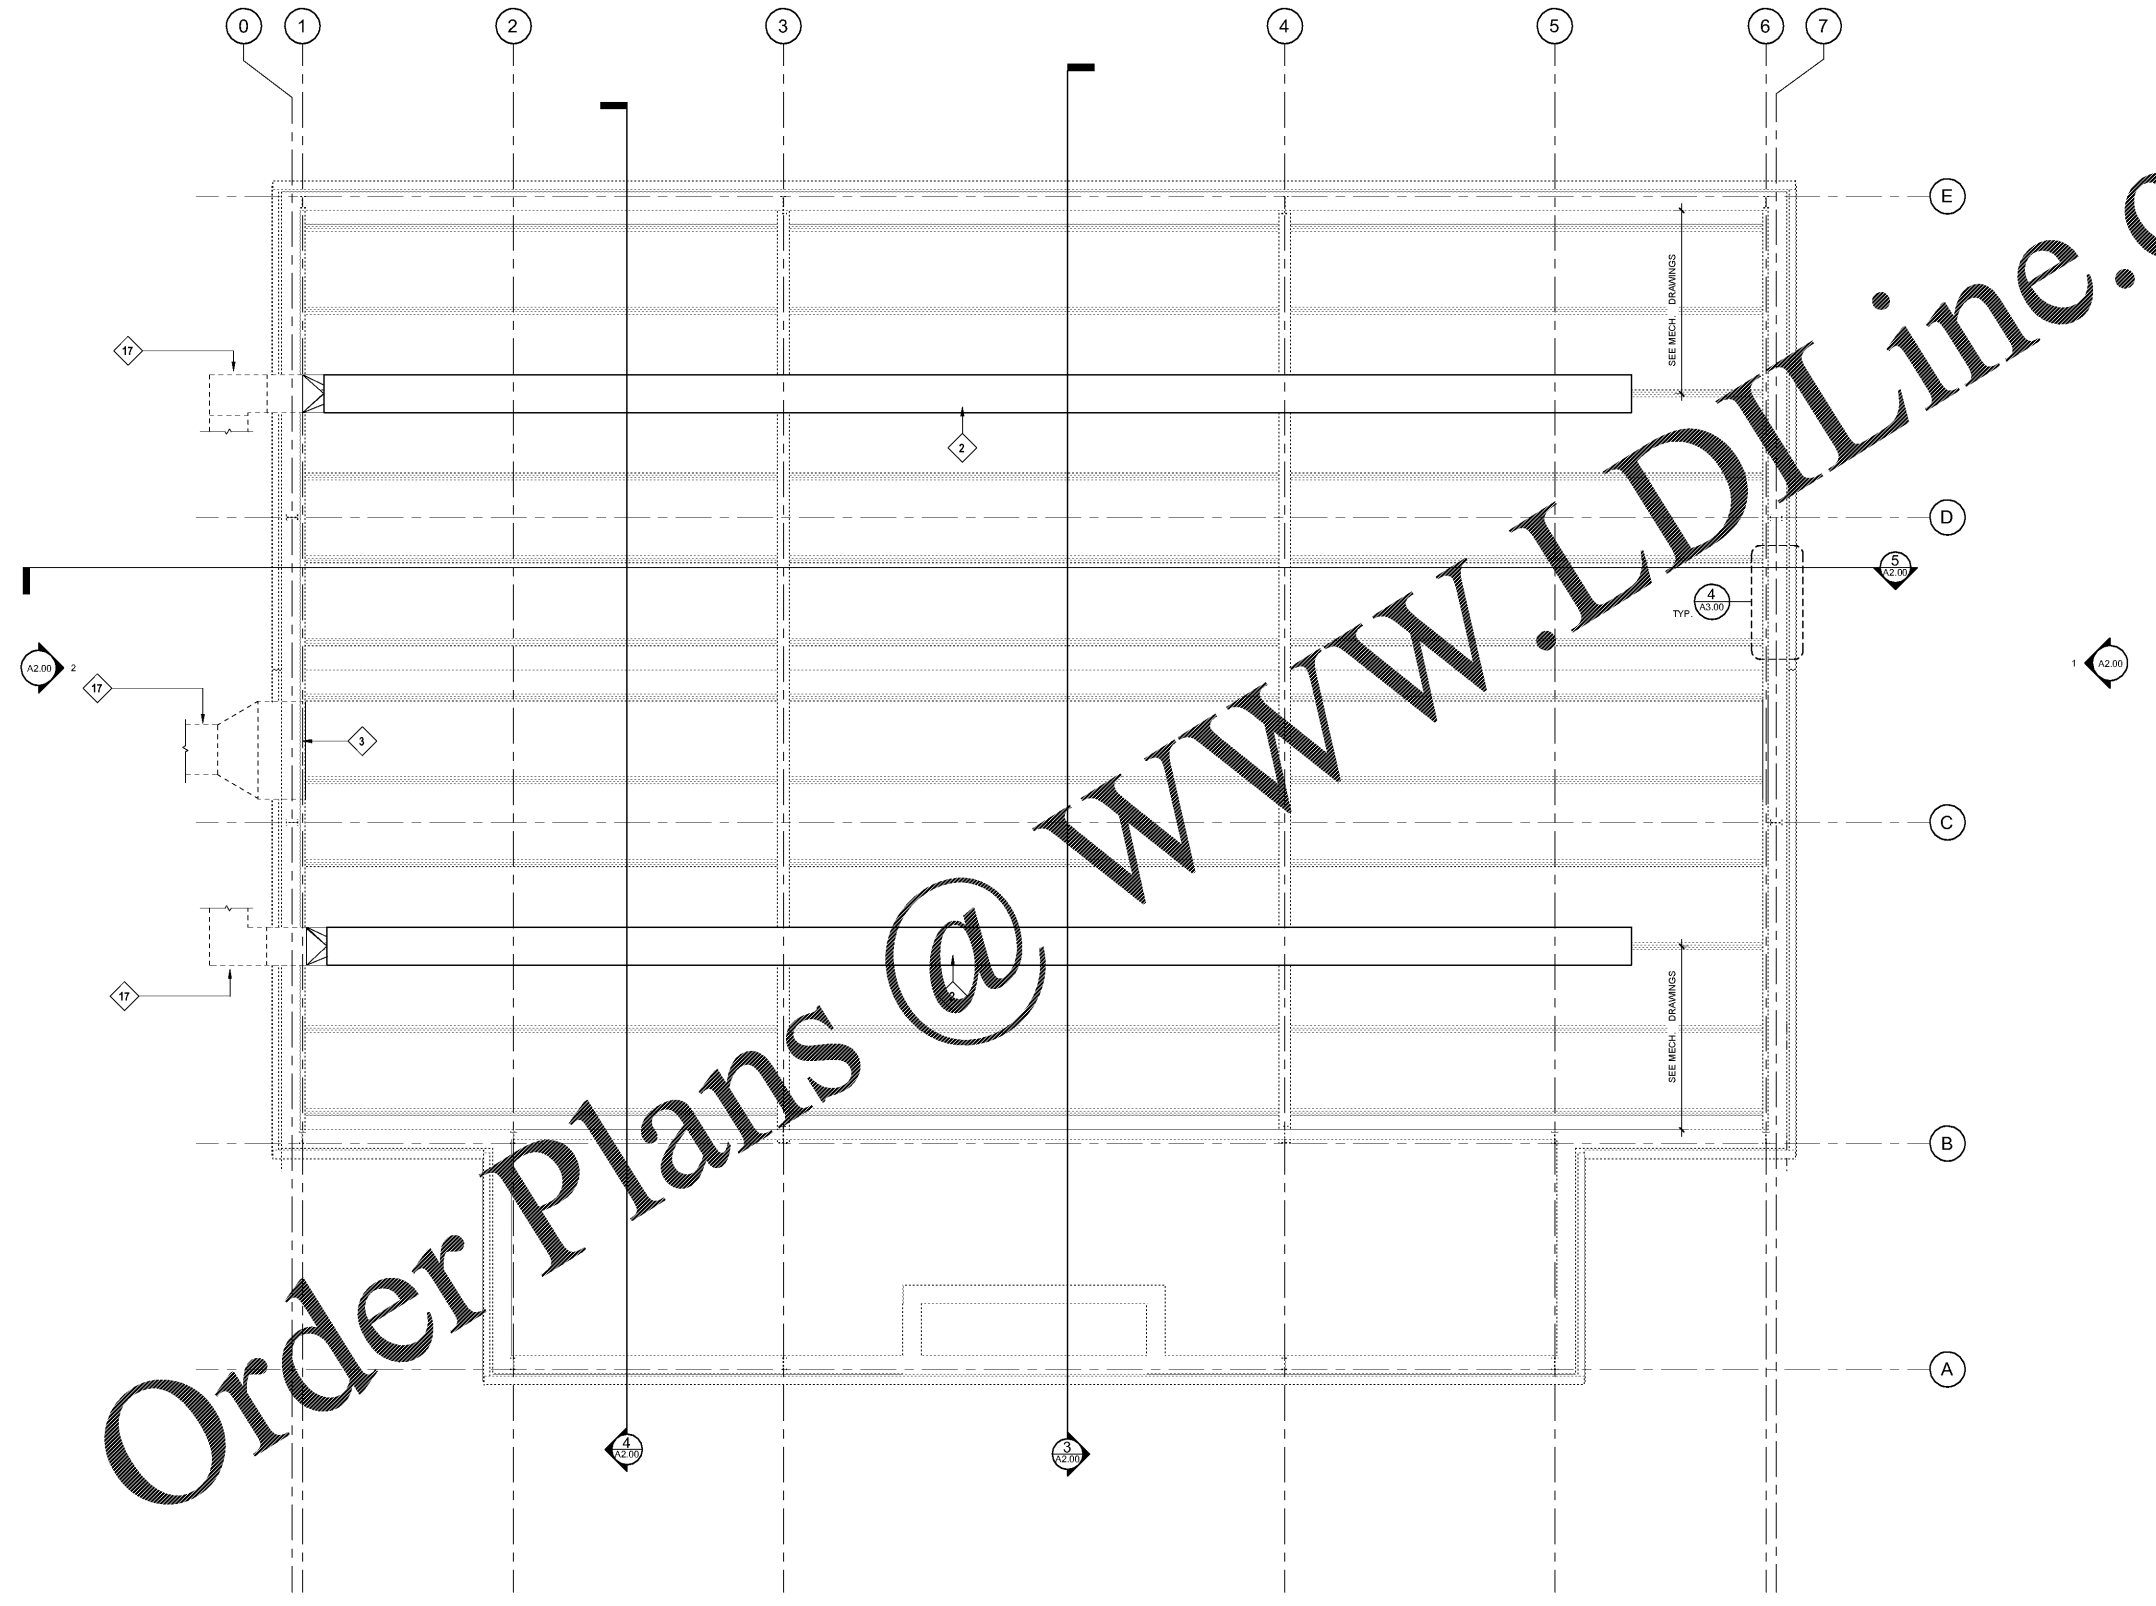

Order Plans @ www.LDILine.com

1 REFLECTED CEILING PLAN
1/4" = 1'-0"



**ELDRIDGE L. MILLER ELEMENTARY
SCHOOL GYM HVAC DESIGN**
919 Martin Road
Stone Mountain, Georgia 30088

**STANLEY
LOVE
STANLEY
P A C**
ARCHITECTURE
INTERIORS PLANNING
PROGRAM MANAGEMENT
1586 SPRING STREET, N.W.
ATLANTA, GEORGIA 30309
404-875-0508
www.stanleylove-stanley.com

DRAWING TITLE
**REFLECTED CEILING
PLAN**

PROFESSIONAL SEAL

CONSULTANT

SCALES AS STATED HEREON ARE VALID ON THE ORIGINAL DRAWING. THE DIMENSIONS OF WHICH ARE SHOWN ON THE SCALE. NOTED HEREON ARE HEREBY CHANGE BY THE PART OF THE OVERALL SHEET DIMENSIONS OF THE PRINT TO CORRESPONDING DIMENSIONS OF THE ORIGINAL DRAWING.
THE DRAWING IS THE PROPERTY OF STANLEY, LOVE & STANLEY, P.C. AND IS NOT TO BE REPRODUCED OR COPIED IN WHOLE OR IN PART. IT IS ONLY TO BE USED FOR THE PROJECT AND SITE SPECIFICALLY IDENTIFIED HEREON AND IS NOT TO BE USED ON ANY OTHER PROJECT. IT IS TO BE RETURNED UPON REQUEST.
COPYRIGHT © 2018 - ALL RIGHTS RESERVED
STANLEY, LOVE & STANLEY, P.C.
DRAWING NO.

DATE
01/31/2020
PROJECT NO.
6919.1
DRAWING NO.

A1.10