


GENERAL NOTES

1. REFER TO CIVIL PLANS FOR INFORMATION ON FENCE AROUND AHU-1.
2. CONTRACTOR TO PROVIDE STRUCTURAL SUPPORT TO EXTERIOR DUCTWORK AS NECESSARY. REFER TO SPECIFICATIONS FOR INFORMATION ON EXTERIOR DUCTWORK AND REQUIREMENTS.

 
DRAWING NOTES

- ① NEW ROUND DUCT TO BE FABRIC DUCT WITH INTERNAL SUPPORT. SEE M-401 FOR FABRIC DUCT DETAILS.
- ② ADD ALTERNATE: PROVIDE NEW DOOR LOUVER AND INSTALL IN RESTROOM DOORS. SEE SCHEDULE FOR LOUVER DIMENSIONS AND LOCATION.

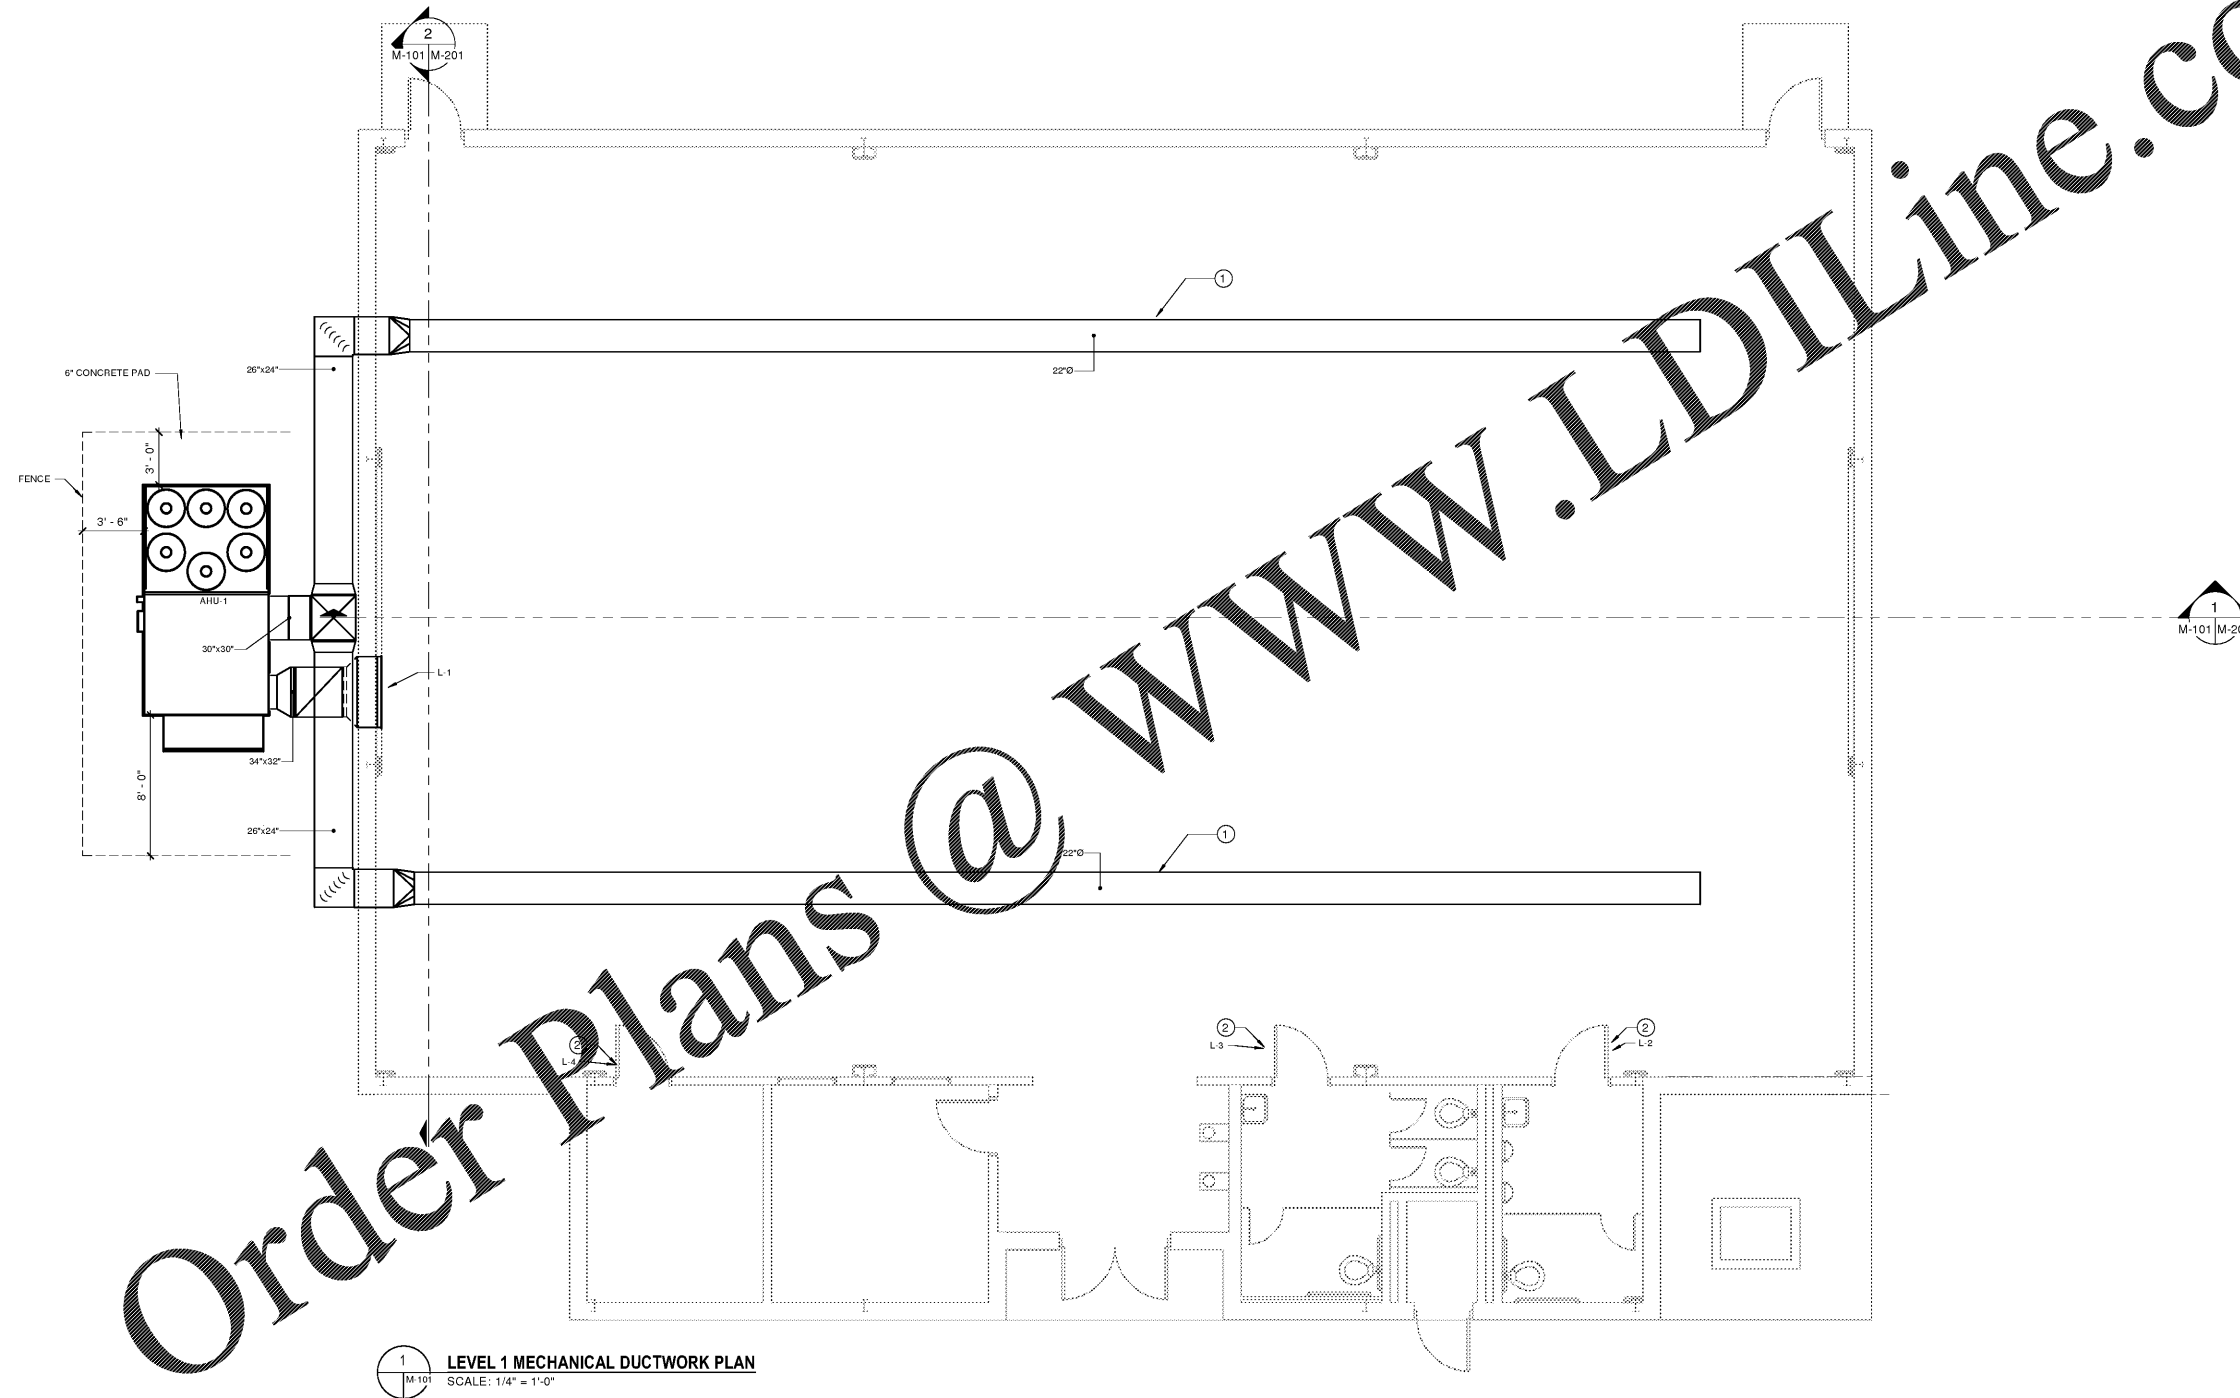

Order Plans @ www.LDILine.com

① M-101
LEVEL 1 MECHANICAL DUCTWORK PLAN
 SCALE: 1/4" = 1'-0"



**ELDRIDGE L MILLER ELEMENTARY
 SCHOOL GYM HVAC DESIGN**
 919 Martin Road
 Stone Mountain, Georgia 30088

**STANLEY
 LOVE
 STANLEY
 P A C**

ARCHITECTURE
 INTERIORS PLANNING
 PROGRAM MANAGEMENT
 1186 SPRING STREET, N.W.
 ATLANTA, GEORGIA 30309-3818
 404.876.0598
 404.876.0847 Fax
 www.stanleylove-stanleypac.com

DRAWING TITLE
**MECHANICAL LEVEL 1
 DUCTWORK PLAN**

PROFESSIONAL SEAL

 ENGINEER
DANIEL NOTO

rmf Engineering
 888 HARRISON DRIVE SUITE 725
 ATLANTA, GA 30328 878.915.0228

SCALES AS STATED HEREON ARE VALID ON THE ORIGINAL DRAWING. THE DIMENSIONS OF THIS DRAWING SHALL BE THE DIMENSIONS OF THE ORIGINAL DRAWING. THE DIMENSIONS OF THIS DRAWING SHALL BE THE DIMENSIONS OF THE ORIGINAL DRAWING. THE DIMENSIONS OF THIS DRAWING SHALL BE THE DIMENSIONS OF THE ORIGINAL DRAWING.

THE DRAWING IS THE PROPERTY OF STANLEY LOVE STANLEY P A C AND IS NOT TO BE REPRODUCED OR COPIED IN WHOLE OR IN PART, IF FOUND TO BE USED ON THE PROJECT AND IT IS FOUND TO BE USED ON ANY OTHER PROJECT, IT IS TO BE RETURNED UPON REQUEST.

COPYRIGHT © 2016. ALL RIGHTS RESERVED BY STANLEY LOVE STANLEY P A C.

DRAWING NO.	M-101
DATE	01/31/2020
PROJECT NO.	6919.1
DRAWING NO.	M-101

RELEASED FOR CONSTRUCTION 01/31/2020