



DRAWING NOTES

- ① DEMOLISH EXISTING NATURAL GAS UNIT HEATER AND ALL ASSOCIATED DUCTWORK, PIPING, CONTROLS, AND WIRING. SEE MD-101 FOR EXTENT OF DEMOLITION.

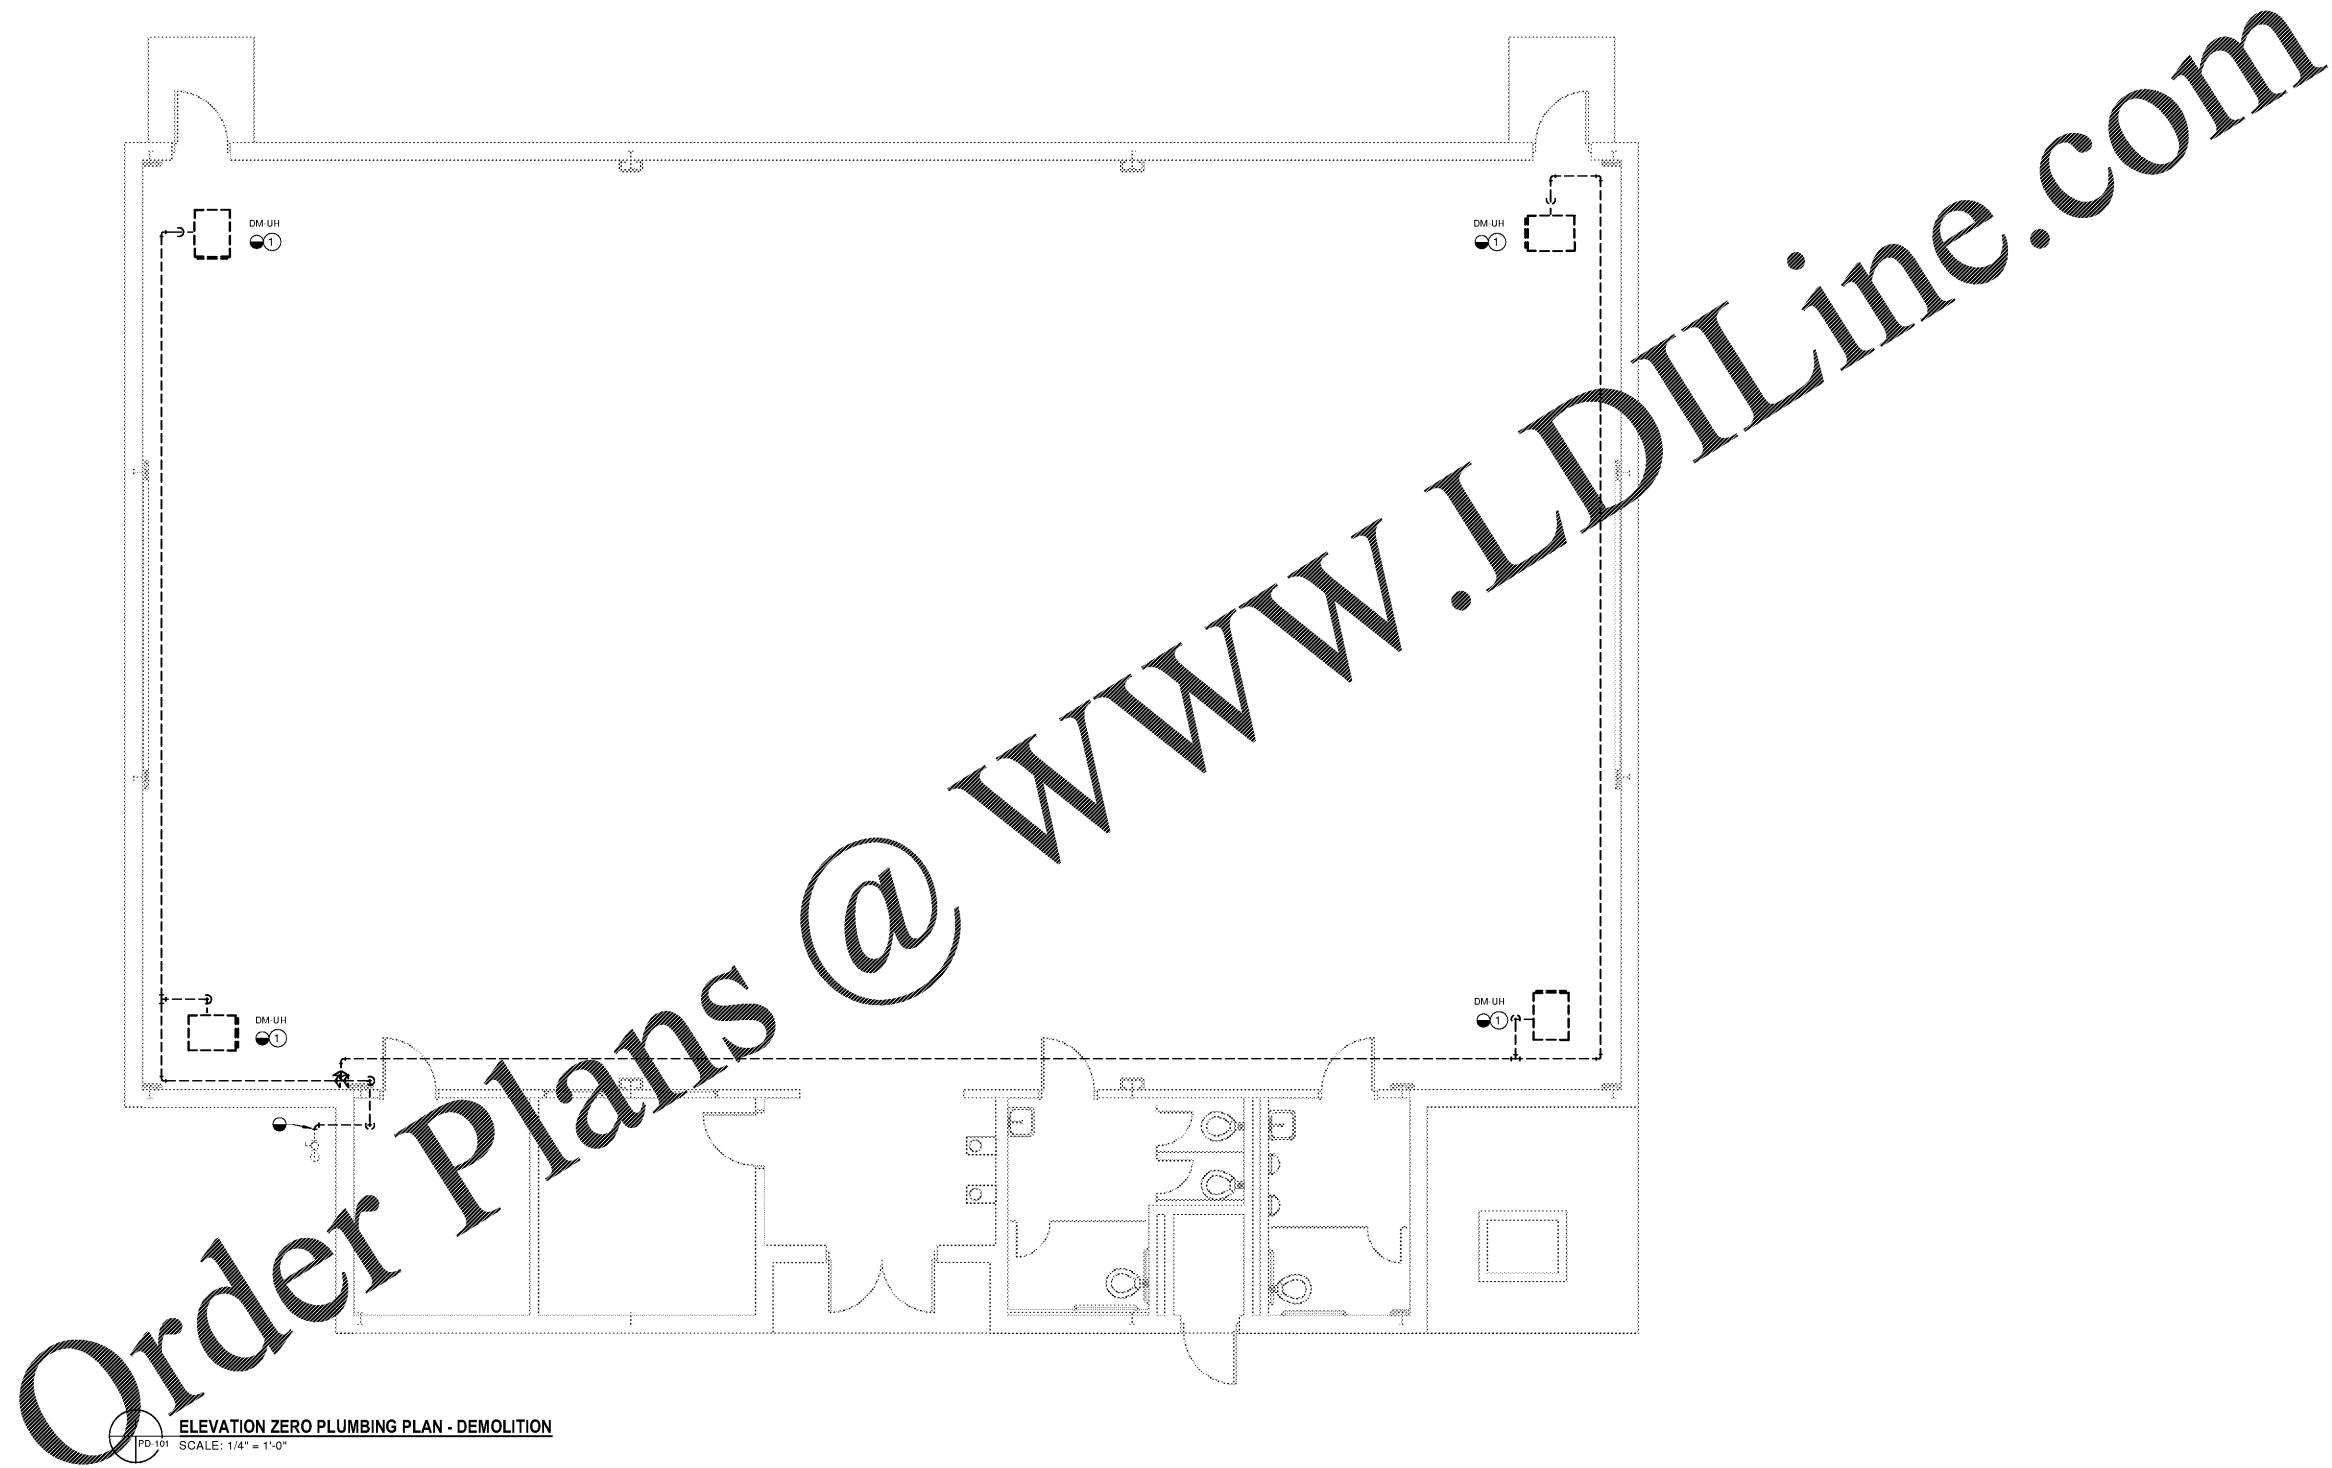

ELEVATION ZERO PLUMBING PLAN - DEMOLITION

 PD-101 SCALE: 1/4" = 1'-0"



**ELDRIDGE L MILLER ELEMENTARY
SCHOOL GYM HVAC DESIGN**
919 Martin Road
Stone Mountain, Georgia 30088



ARCHITECTURE
INTERIORS PLANNING
PROGRAM MANAGEMENT
1186 SPRING STREET, N.W.
ATLANTA, GEORGIA 30309-3818
404.876.0596
www.stanleylove-stanley.com

DRAWING TITLE
**PLUMBING LEVEL 1
DEMOLITION**



CONSULTANT



SCALES AS STATED HEREON ARE VALID ON THE ORIGINAL DRAWING. THE DIMENSIONS OF THIS DRAWING SHALL BE THE SCALE OF THE RATIO OF THE OVERALL SHEET DIMENSIONS OF THE PRINT TO CORRESPONDING DIMENSIONS OF THE ORIGINAL DRAWING.

THIS DRAWING IS THE PROPERTY OF STANLEY LOVE STANLEY P & C AND IS NOT TO BE REPRODUCED OR COPIED IN WHOLE OR IN PART, IT IS TO BE USED ONLY FOR THE PROJECT AND SITE SPECIFICALLY IDENTIFIED HEREIN AND IS NOT TO BE USED ON ANY OTHER PROJECT. IT IS TO BE RETURNED UPON REQUEST.

COPYRIGHT © 2016. ALL RIGHTS RESERVED BY STANLEY LOVE STANLEY P & C.

DRAWING NO.

DATE

01/31/2020

PROJECT NO.

6919.1

DRAWING NO.

PD-101

RELEASED FOR CONSTRUCTION 01/31/2020