

D1	100% CD SET	01/31/2020

**HAWTHORNE ELEMENTARY SCHOOL
GYM HVAC DESIGN**
2335 Caladium Drive NE
Atlanta, Georgia 30345

**STANLEY
LOVE
STANLEY
P R C**

ARCHITECTURE
INTERIORS PLANNING
PROGRAM MANAGEMENT

1386 SPRING STREET, N.W.
ATLANTA, GEORGIA 30309
404-875-0508
404-875-0509 fax
www.stanleylove-stanley.com

DRAWING TITLE
**EXTERIOR
ELEVATIONS &
BUILDING SECTIONS -
DEMOLITION**



CONSULTANT

SCALES AS SHOWN HEREIN ARE VALID ON THE ORIGINAL DRAWING. THE DIMENSIONS OF WHICH ARE SHOWN HEREIN. THE SCALES NOTED HEREIN ARE HEREBY CHANGE BY THE RATIO OF THE OVERALL SHEET DIMENSIONS OF THE PRINT TO CORRESPONDING DIMENSIONS OF THE ORIGINAL DRAWING.

THIS DRAWING IS THE PROPERTY OF STANLEY LOVE STANLEY P.C. AND IS NOT TO BE REPRODUCED OR COPIED IN WHOLE OR IN PART. IT IS TO BE USED ONLY FOR THE PROJECT AND SITE SPECIFICALLY IDENTIFIED HEREIN AND IS NOT TO BE USED ON ANY OTHER PROJECT. IT IS TO BE RETURNED UPON REQUEST.


COPYRIGHT © 2018. ALL RIGHTS RESERVED.
STANLEY LOVE STANLEY P.C.
DRAWING NO.

DATE
01/31/2020


PROJECT NO.
6919.2

DRAWING NO.


AD2.00

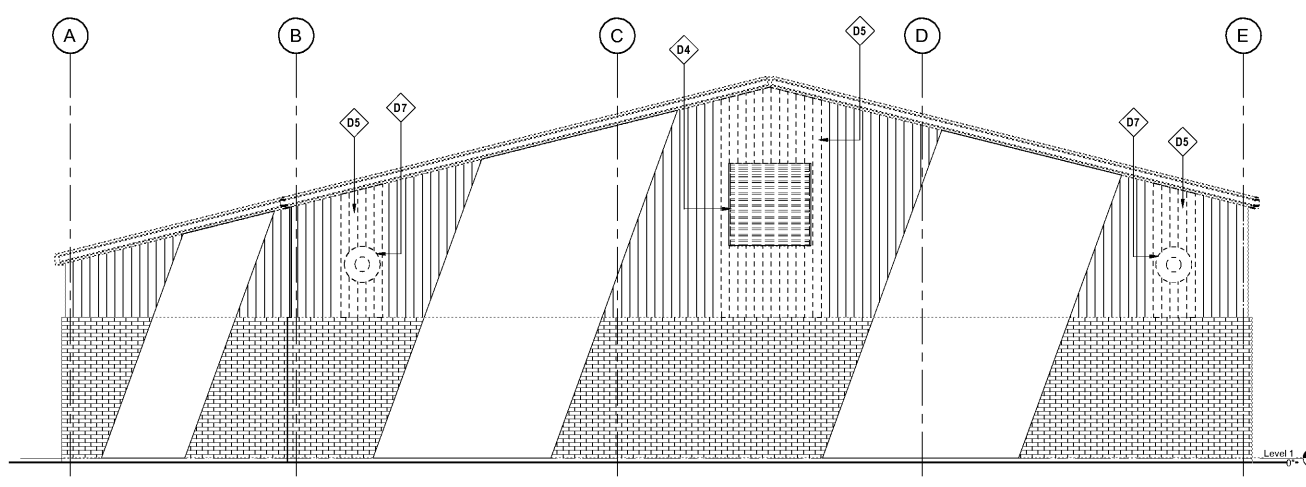


1 DEMOLITION WEST ELEVATION
1/4" = 1'-0"

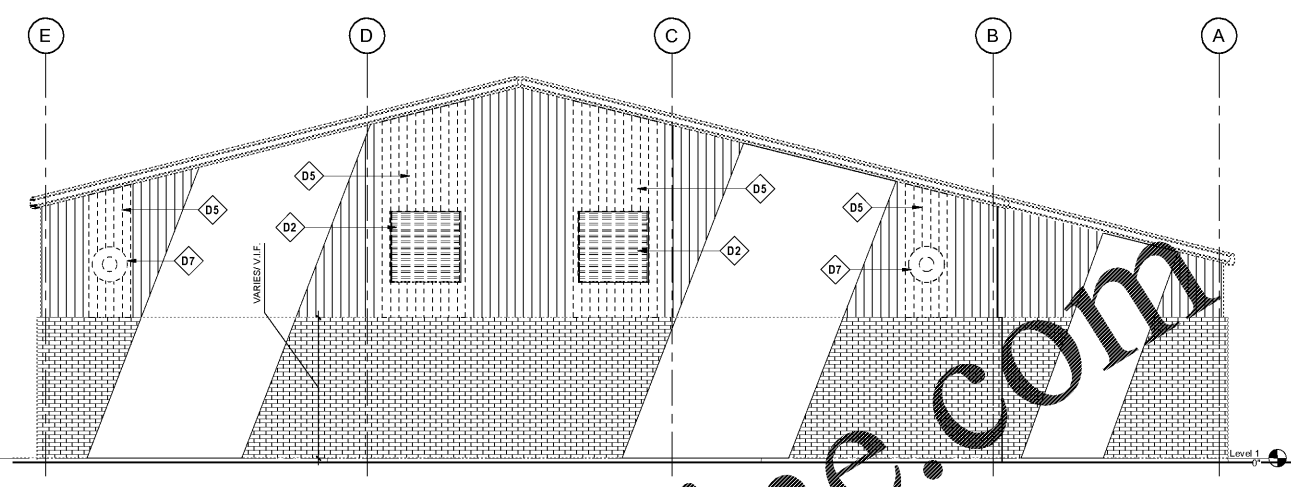

2 DEMOLITION EAST ELEVATION
1/4" = 1'-0"

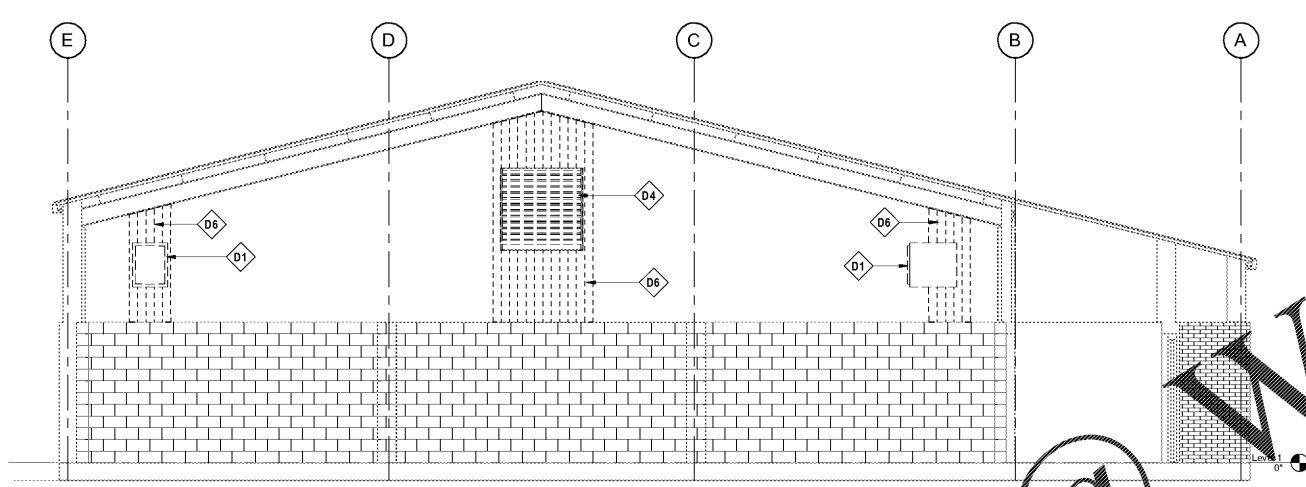

3 DEMOLITION SECTION 3
1/4" = 1'-0"

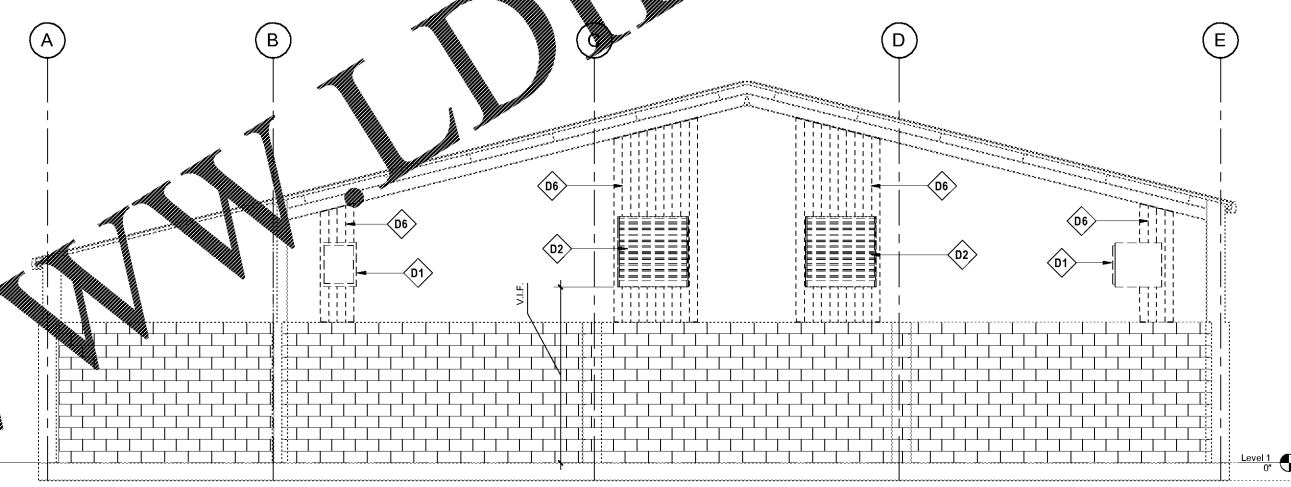

4 DEMOLITION SECTION 4
1/4" = 1'-0"

Order Plans @ www.LDILine.com

Keynote Legend	
Key Value	Keynote Text
D1	REMOVE EXISTING GAS-FIRED UNIT HEATERS. SEE MECHANICAL DRAWINGS.
D2	REMOVE EXISTING INTAKE LOUVER SYSTEM TO EXTENT INDICATED. SEE MECHANICAL DRAWINGS.
D4	REMOVE EXISTING WALL-MOUNTED EXHAUST FAN SYSTEM TO EXTENT INDICATED. SEE MECHANICAL DRAWINGS.
D5	REMOVE FULL METAL WALL PANEL(S) IN THIS AREA, AS REQUIRED, FOR INSTALLATION OF NEW EXTERIOR METAL WALL PANEL(S).
D6	REMOVE FULL LINER WALL PANEL(S) IN THIS AREA, AS REQUIRED, FOR INSTALLATION OF NEW METAL LINER PANEL(S).
D7	REMOVE GAS HEATER VENT PIPING THROUGH WALL. FIELD VERIFY LOCATION. SEE PLUMBING DRAWINGS.