


| Keynote Legend | |
|----------------|---|
| Key Value | Keynote Text |
| 6 | AIR HANDLING UNIT. SEE MECHANICAL DRAWINGS. |
| 7 | CONCRETE PAD. SEE CIVIL AND MECHANICAL DRAWINGS. |
| 8 | CHAIN LINK FENCE. SEE CIVIL DRAWINGS. |
| 17 | NEW EXTERIOR SUPPLY AIR DUCTWORK AND SUPPORT AS SHOWN ON DETAILS 7, 9 AND 10 ON MECHANICAL DRAWING M-401. |

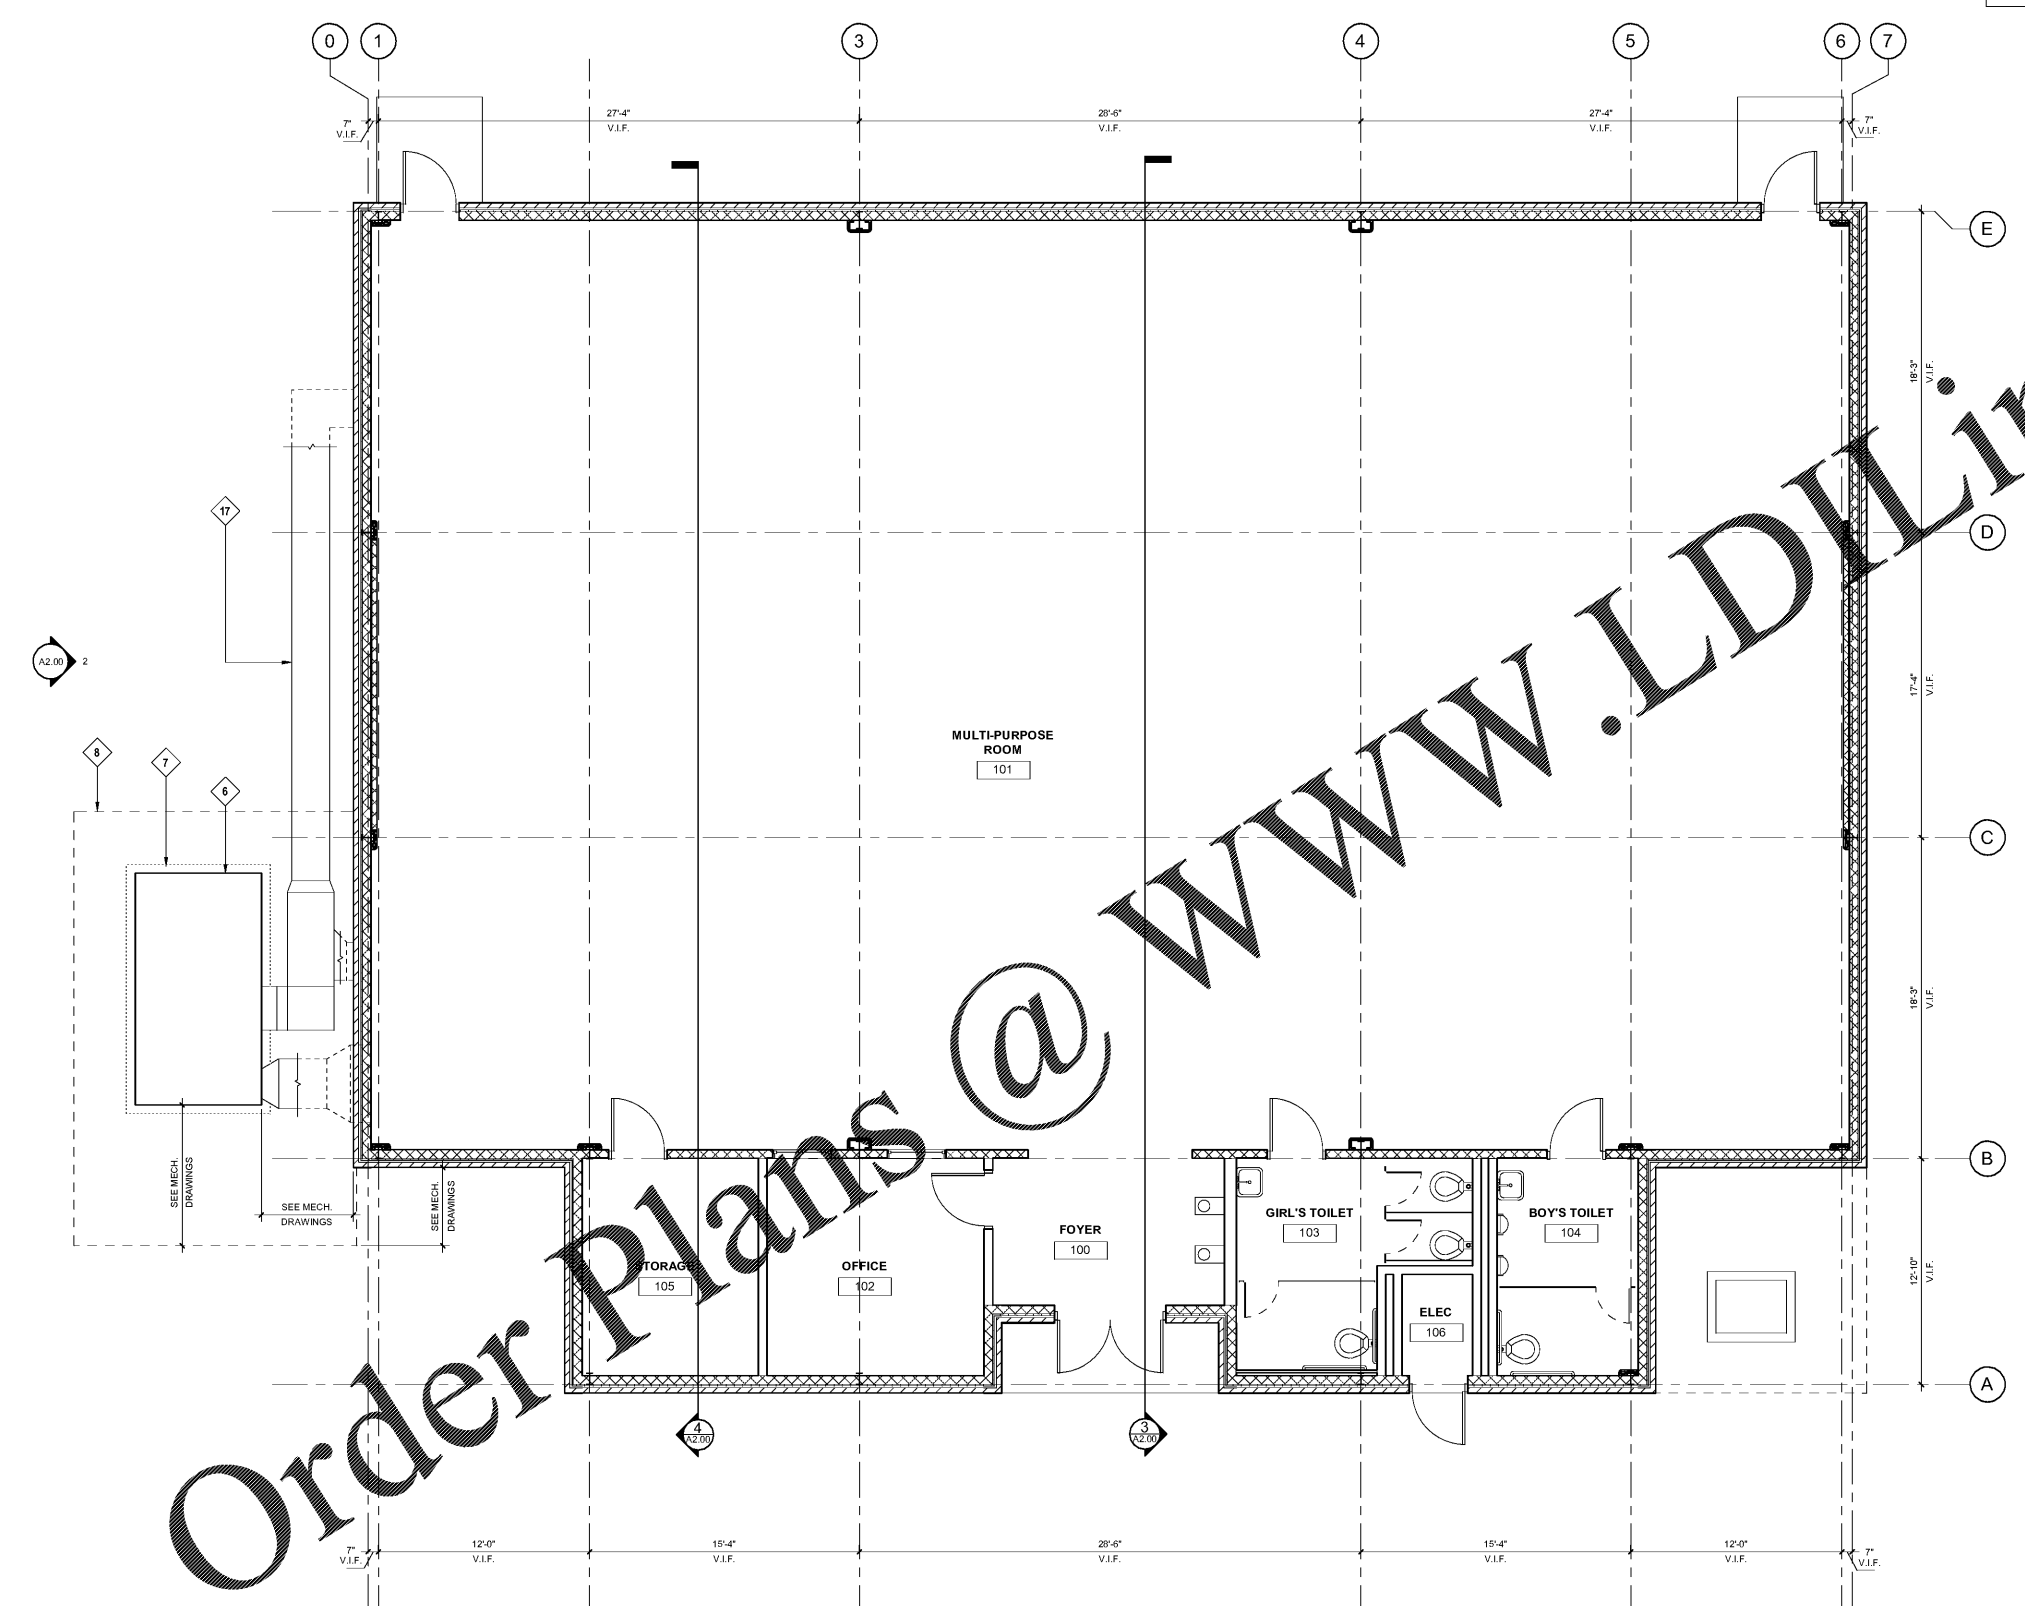

www.LDILine.com

Order Plans @

1 FLOOR PLAN
1/4" = 1'-0"



**HAWTHORNE ELEMENTARY SCHOOL
GYM HVAC DESIGN**
2535 Caladium Drive NE
Atlanta, Georgia 30345

**STANLEY
LOVE
STANLEY
P A C**

ARCHITECTURE
INTERIORS PLANNING
PROGRAM MANAGEMENT

1586 SPRING STREET, N.W.
ATLANTA, GEORGIA 30309
404-875-0208
www.stanleylove-stanley.com

DRAWING TITLE
FLOOR PLAN



SCALES AS STATED HEREON ARE VALID ON THE ORIGINAL DRAWING. THE DIMENSIONS OF WHICH ARE SHOWN ON THE SCALY. NOTED HEREON ARE HEREBY CHANGE BY THE PART OF THE OVERALL SHEET DIMENSIONS OF THE PRINT TO CORRESPONDING DIMENSIONS OF THE ORIGINAL DRAWING.

THE DRAWING IS THE PROPERTY OF STANLEY, LOVE & STANLEY, P.C. AND IS NOT TO BE REPRODUCED OR COPIED IN WHOLE OR IN PART. IT IS ON TO BE USED FOR THE PROJECT AND SITE SPECIFICALLY IDENTIFIED HEREON AND IS NOT TO BE USED ON ANY OTHER PROJECT. IT IS TO BE RETURNED UPON REQUEST.

COPYRIGHT © 2018. ALL RIGHTS RESERVED
STANLEY, LOVE & STANLEY, P.C.
DRAWING NO.

DATE
01/31/2020
PROJECT NO.
6919.2
DRAWING NO.

A1.00