


Keynote Legend	
Key Value	Keynote Text
2	FABRIC DUCT, COORDINATE SIZE, LOCATION AND ATTACHMENT WITH MECHANICAL DRAWINGS.
3	NEW RETURN AIR LOUVER, COORDINATE SIZE AND LOCATION WITH MECHANICAL DRAWINGS.
17	NEW EXTERIOR SUPPLY AIR DUCTWORK AND SUPPORT AS SHOWN ON DETAILS 7, 9 AND 10 ON MECHANICAL DRAWING M-401.
NOTE: REFER TO A 2.00 AND A3.00 FOR LOCATIONS AND EXTENT OF NEW METAL WALL PANEL(S) AND LINER PANEL(S).	

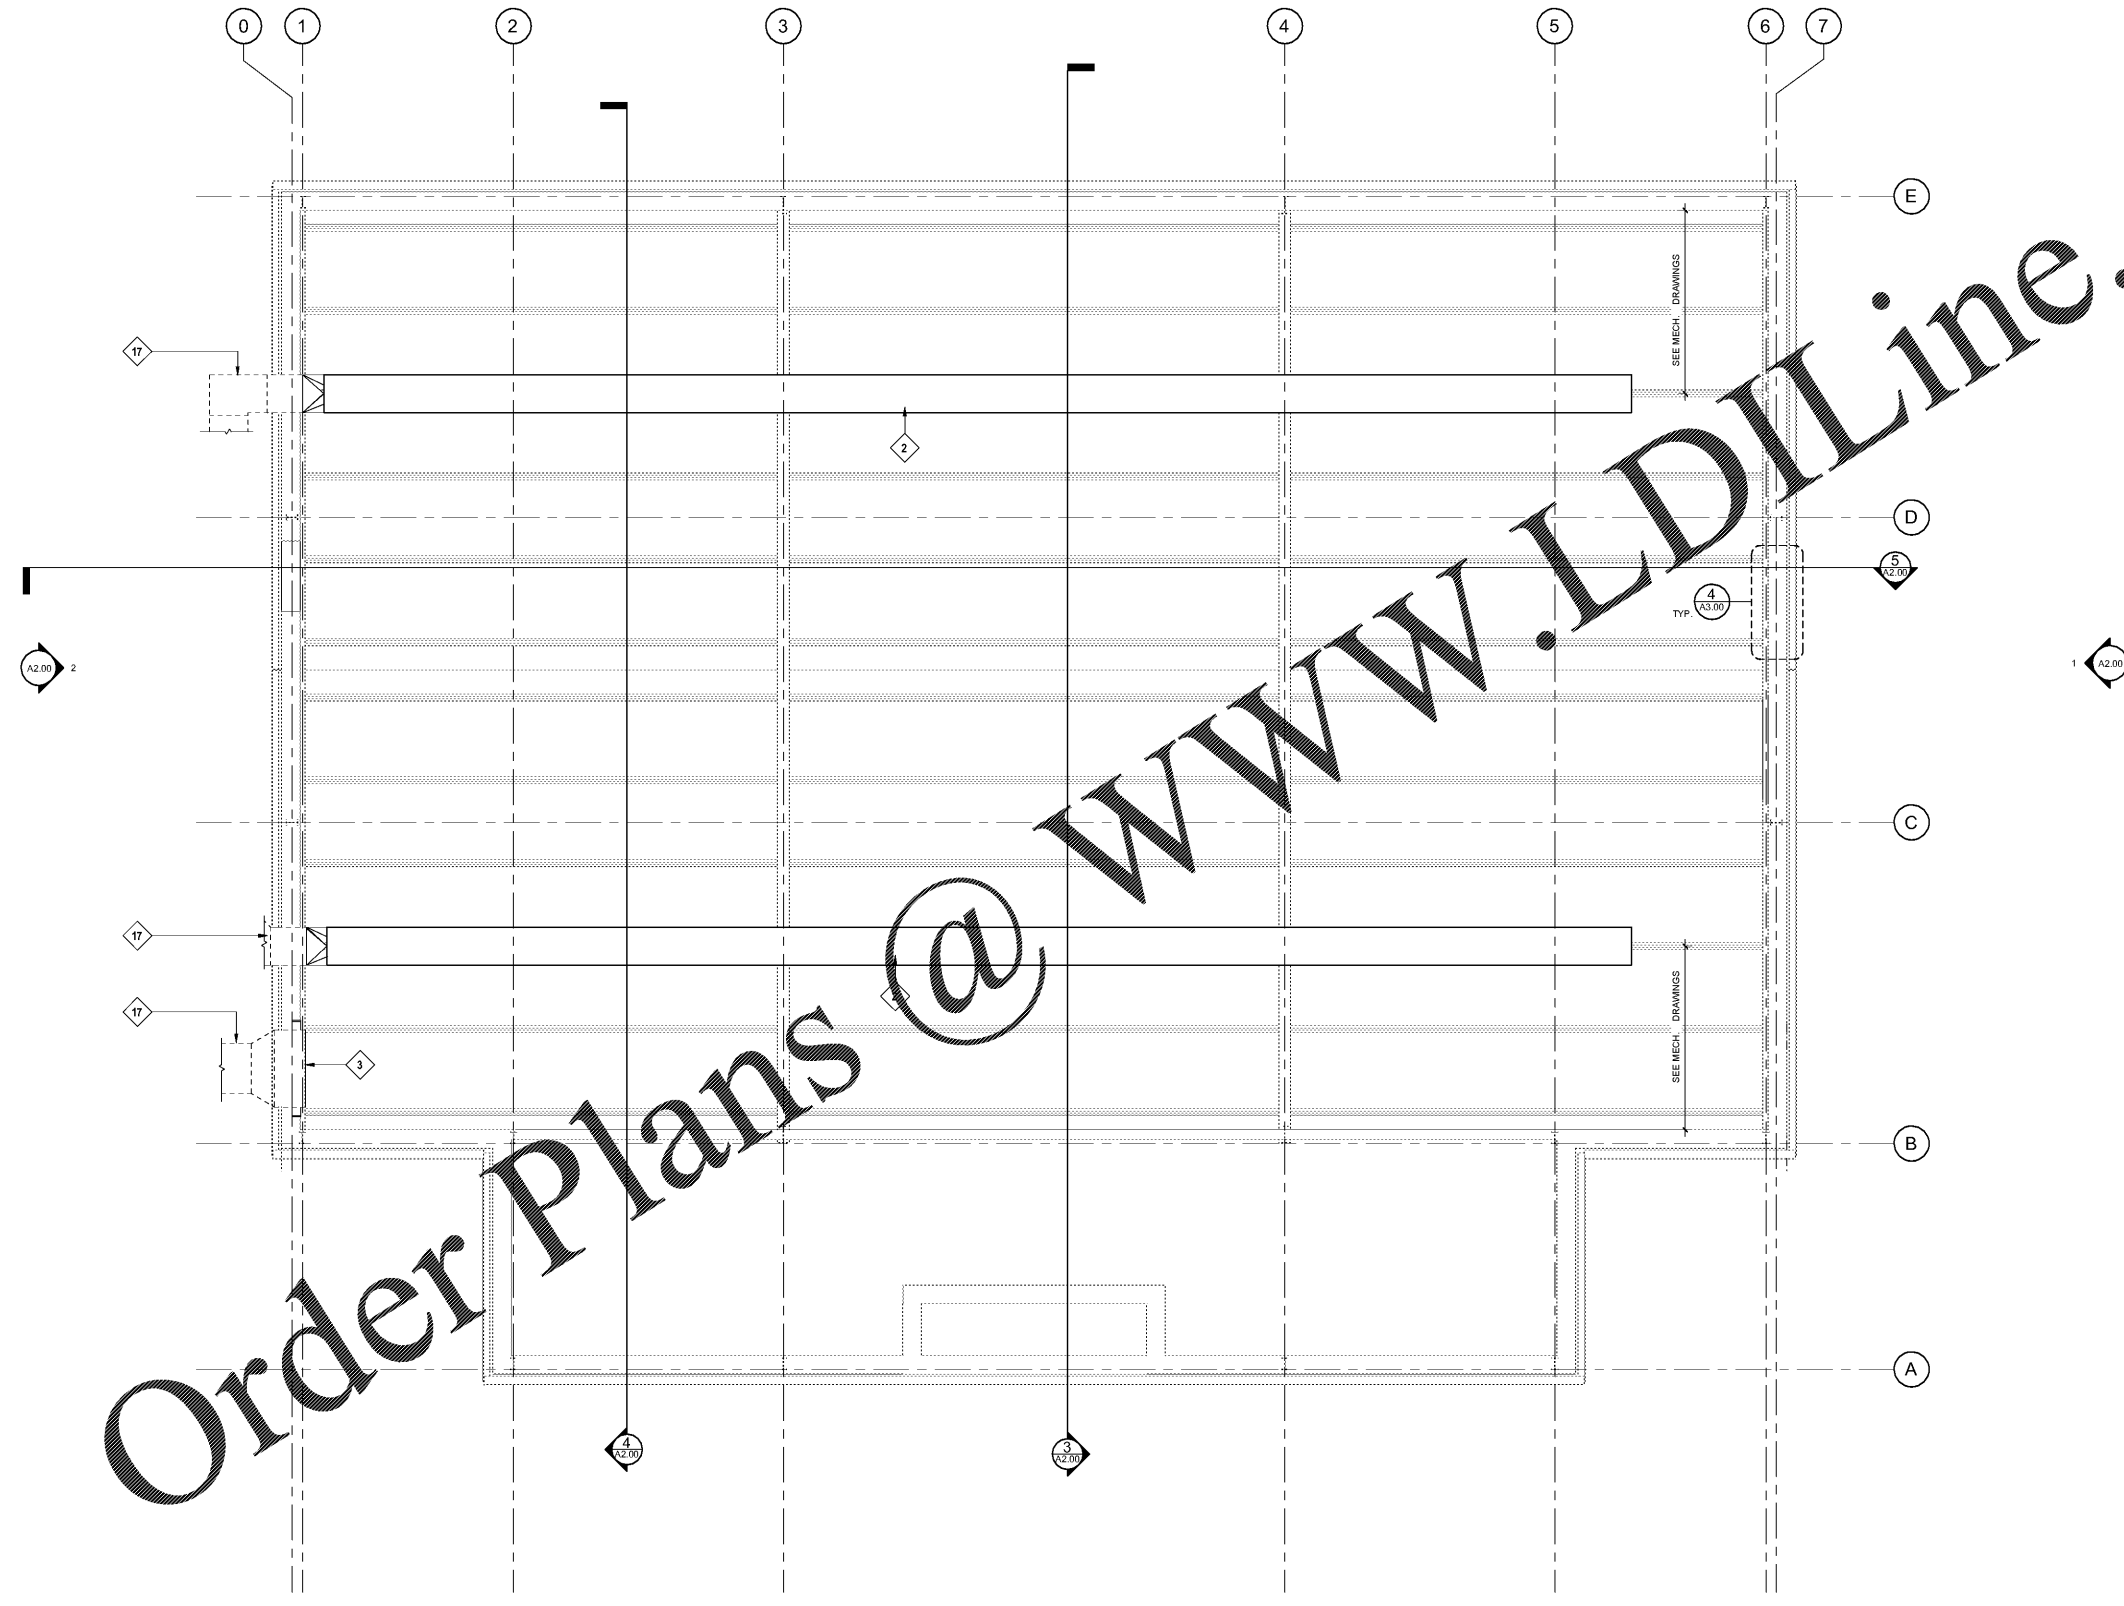

Order Plans @ www.LDILine.com

1 REFLECTED CEILING PLAN
1/4" = 1'-0"



1/31/2020 5:03:50 PM

100% CD SET	01/31/2020
-------------	------------

**HAWTHORNE ELEMENTARY SCHOOL
GYM HVAC DESIGN**
2535 Caladium Drive NE
Atlanta, Georgia 30345

**STANLEY
LOVE
STANLEY
P A C**

ARCHITECTURE
INTERIORS PLANNING
PROGRAM MANAGEMENT

1586 SPRING STREET, N.W.
ATLANTA, GEORGIA 30309
404-875-0508
www.stanleylove-stanley.com

DRAWING TITLE
REFLECTED CEILING PLAN



CONSULTANT

SCALES AS STATED HEREON ARE VALID ON THE ORIGINAL DRAWING. THE DIMENSIONS OF WHICH ARE SHOWN ON THE SCALY. NOTED HEREON ARE HEREBY CHANGE BY THE PART OF THE OVERALL SHEET DIMENSIONS OF THE PRINT TO CORRESPONDING DIMENSIONS OF THE ORIGINAL DRAWING.

THIS DRAWING IS THE PROPERTY OF STANLEY, LOVE & STANLEY P.C. AND IS NOT TO BE REPRODUCED OR COPIED IN WHOLE OR IN PART. IT IS ONLY TO BE USED FOR THE PROJECT AND SITE SPECIFICALLY IDENTIFIED HEREON AND IS NOT TO BE USED ON ANY OTHER PROJECT. IT IS TO BE RETURNED UPON REQUEST.

COPYRIGHT © 2018. ALL RIGHTS RESERVED.
STANLEY, LOVE & STANLEY P.C.
DRAWING NO.

DATE
01/31/2020
PROJECT NO.
6919.2
DRAWING NO.

A1.10

RELEASED FOR CONSTRUCTION 01/31/2020