


GENERAL NOTES

 
1. REFER TO CIVIL PLANS FOR INFORMATION ON FENCE AROUND AHU-1.
2. CONTRACTOR TO PROVIDE STRUCTURAL SUPPORT TO EXTERIOR DUCTWORK AS NECESSARY. REFER TO SPECIFICATIONS FOR INFORMATION ON EXTERIOR DUCTWORK AND REQUIREMENTS.

DRAWING NOTES

- ① NEW ROUND DUCT TO BE FABRIC DUCT WITH INTERNAL SUPPORT. SEE M-401 FOR FABRIC DUCT DETAILS.
- ② ADD ALTERNATE: PROVIDE NEW DOOR LOUVER AND INSTALL IN RESTROOM DOORS. SEE SCHEDULE FOR LOUVER DIMENSIONS AND LOCATION.

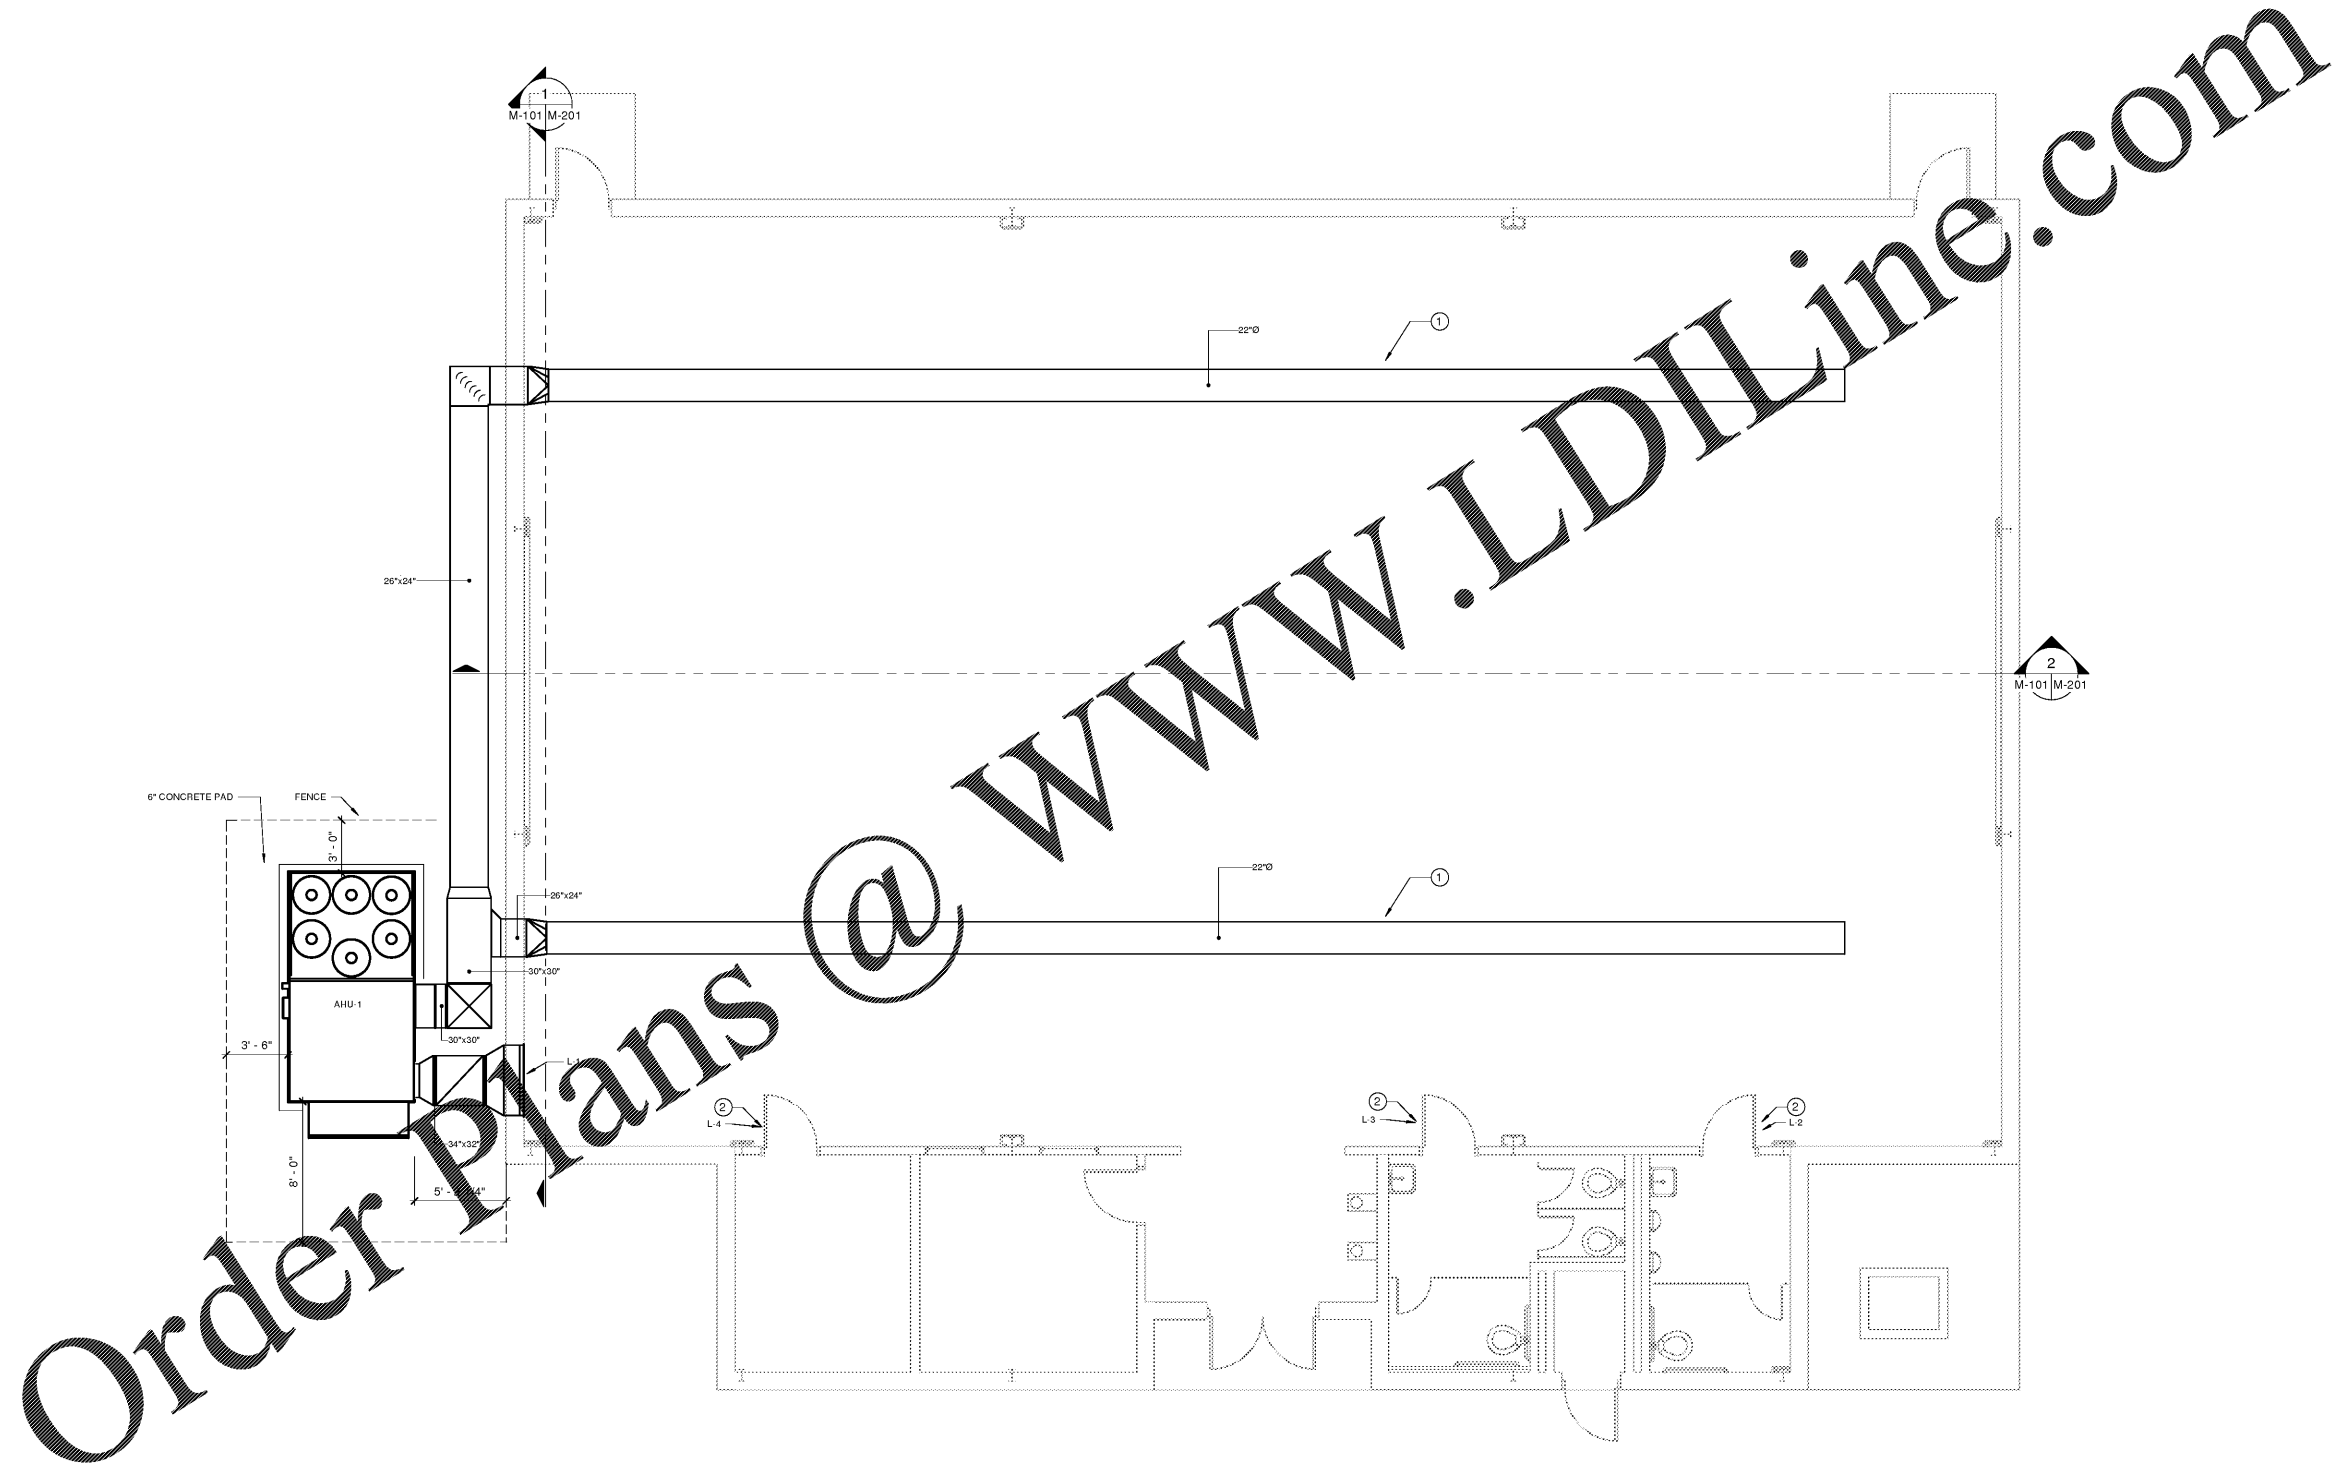

1 LEVEL 1 MECHANICAL DUCTWORK PLAN
SCALE: 1/4" = 1'-0"



HAWTHORNE ELEMENTARY SCHOOL
GYM HVAC DESIGN
2535 Caladium Drive NE
Atlanta, GA 30345

STANLEY LOVE STANLEY P & C
ARCHITECTURE
INTERIORS PLANNING
PROGRAM MANAGEMENT
1186 SPRING STREET, N.W.
ATLANTA, GEORGIA 30309-3819
404-576-0596
404-576-0987 fax
www.stanleylove-stanley.com

DRAWING TITLE
MECHANICAL LEVEL 1
DUCTWORK PLAN

PROFESSIONAL SEAL

ENGINEER
DANIEL NOTO

mf Engineering
810 HARRISON DRIVE SUITE 725
ATLANTA, GA 30308 878-815-0229

SCALES AS STATED HEREON ARE VALID ON THE ORIGINAL DRAWING. THE DIMENSIONS OF WHICH ARE SHOWN HEREON. THE SCALES OF THE RATIO OF THE OVERALL SHEET DIMENSIONS TO THE PRINT TO CORRESPONDING DIMENSIONS OF THE ORIGINAL DRAWING.
THIS DRAWING IS THE PROPERTY OF STANLEY LOVE STANLEY P.C. AND IS NOT TO BE REPRODUCED OR COPIED IN WHOLE OR IN PART. IT IS TO BE USED ONLY FOR THE PROJECT AND SITE SPECIFIC HEREON AND IS NOT TO BE USED ON ANY OTHER PROJECT. IT IS TO BE RETURNED UPON REQUEST.
COPYRIGHT © 2016. ALL RIGHTS RESERVED BY STANLEY LOVE STANLEY P.C.

DRAWING NO
DATE
01/31/2020
PROJECT NO
6919.2
DRAWING NO

M-101

RELEASED FOR CONSTRUCTION 01/31/2020