


Keynote Legend	
Key Value	Keynote Text
6	AIR HANDLING UNIT. SEE MECHANICAL DRAWINGS.
7	CONCRETE PAD. SEE CIVIL AND MECHANICAL DRAWINGS.
8	CHAIN LINK FENCE. SEE CIVIL DRAWINGS.

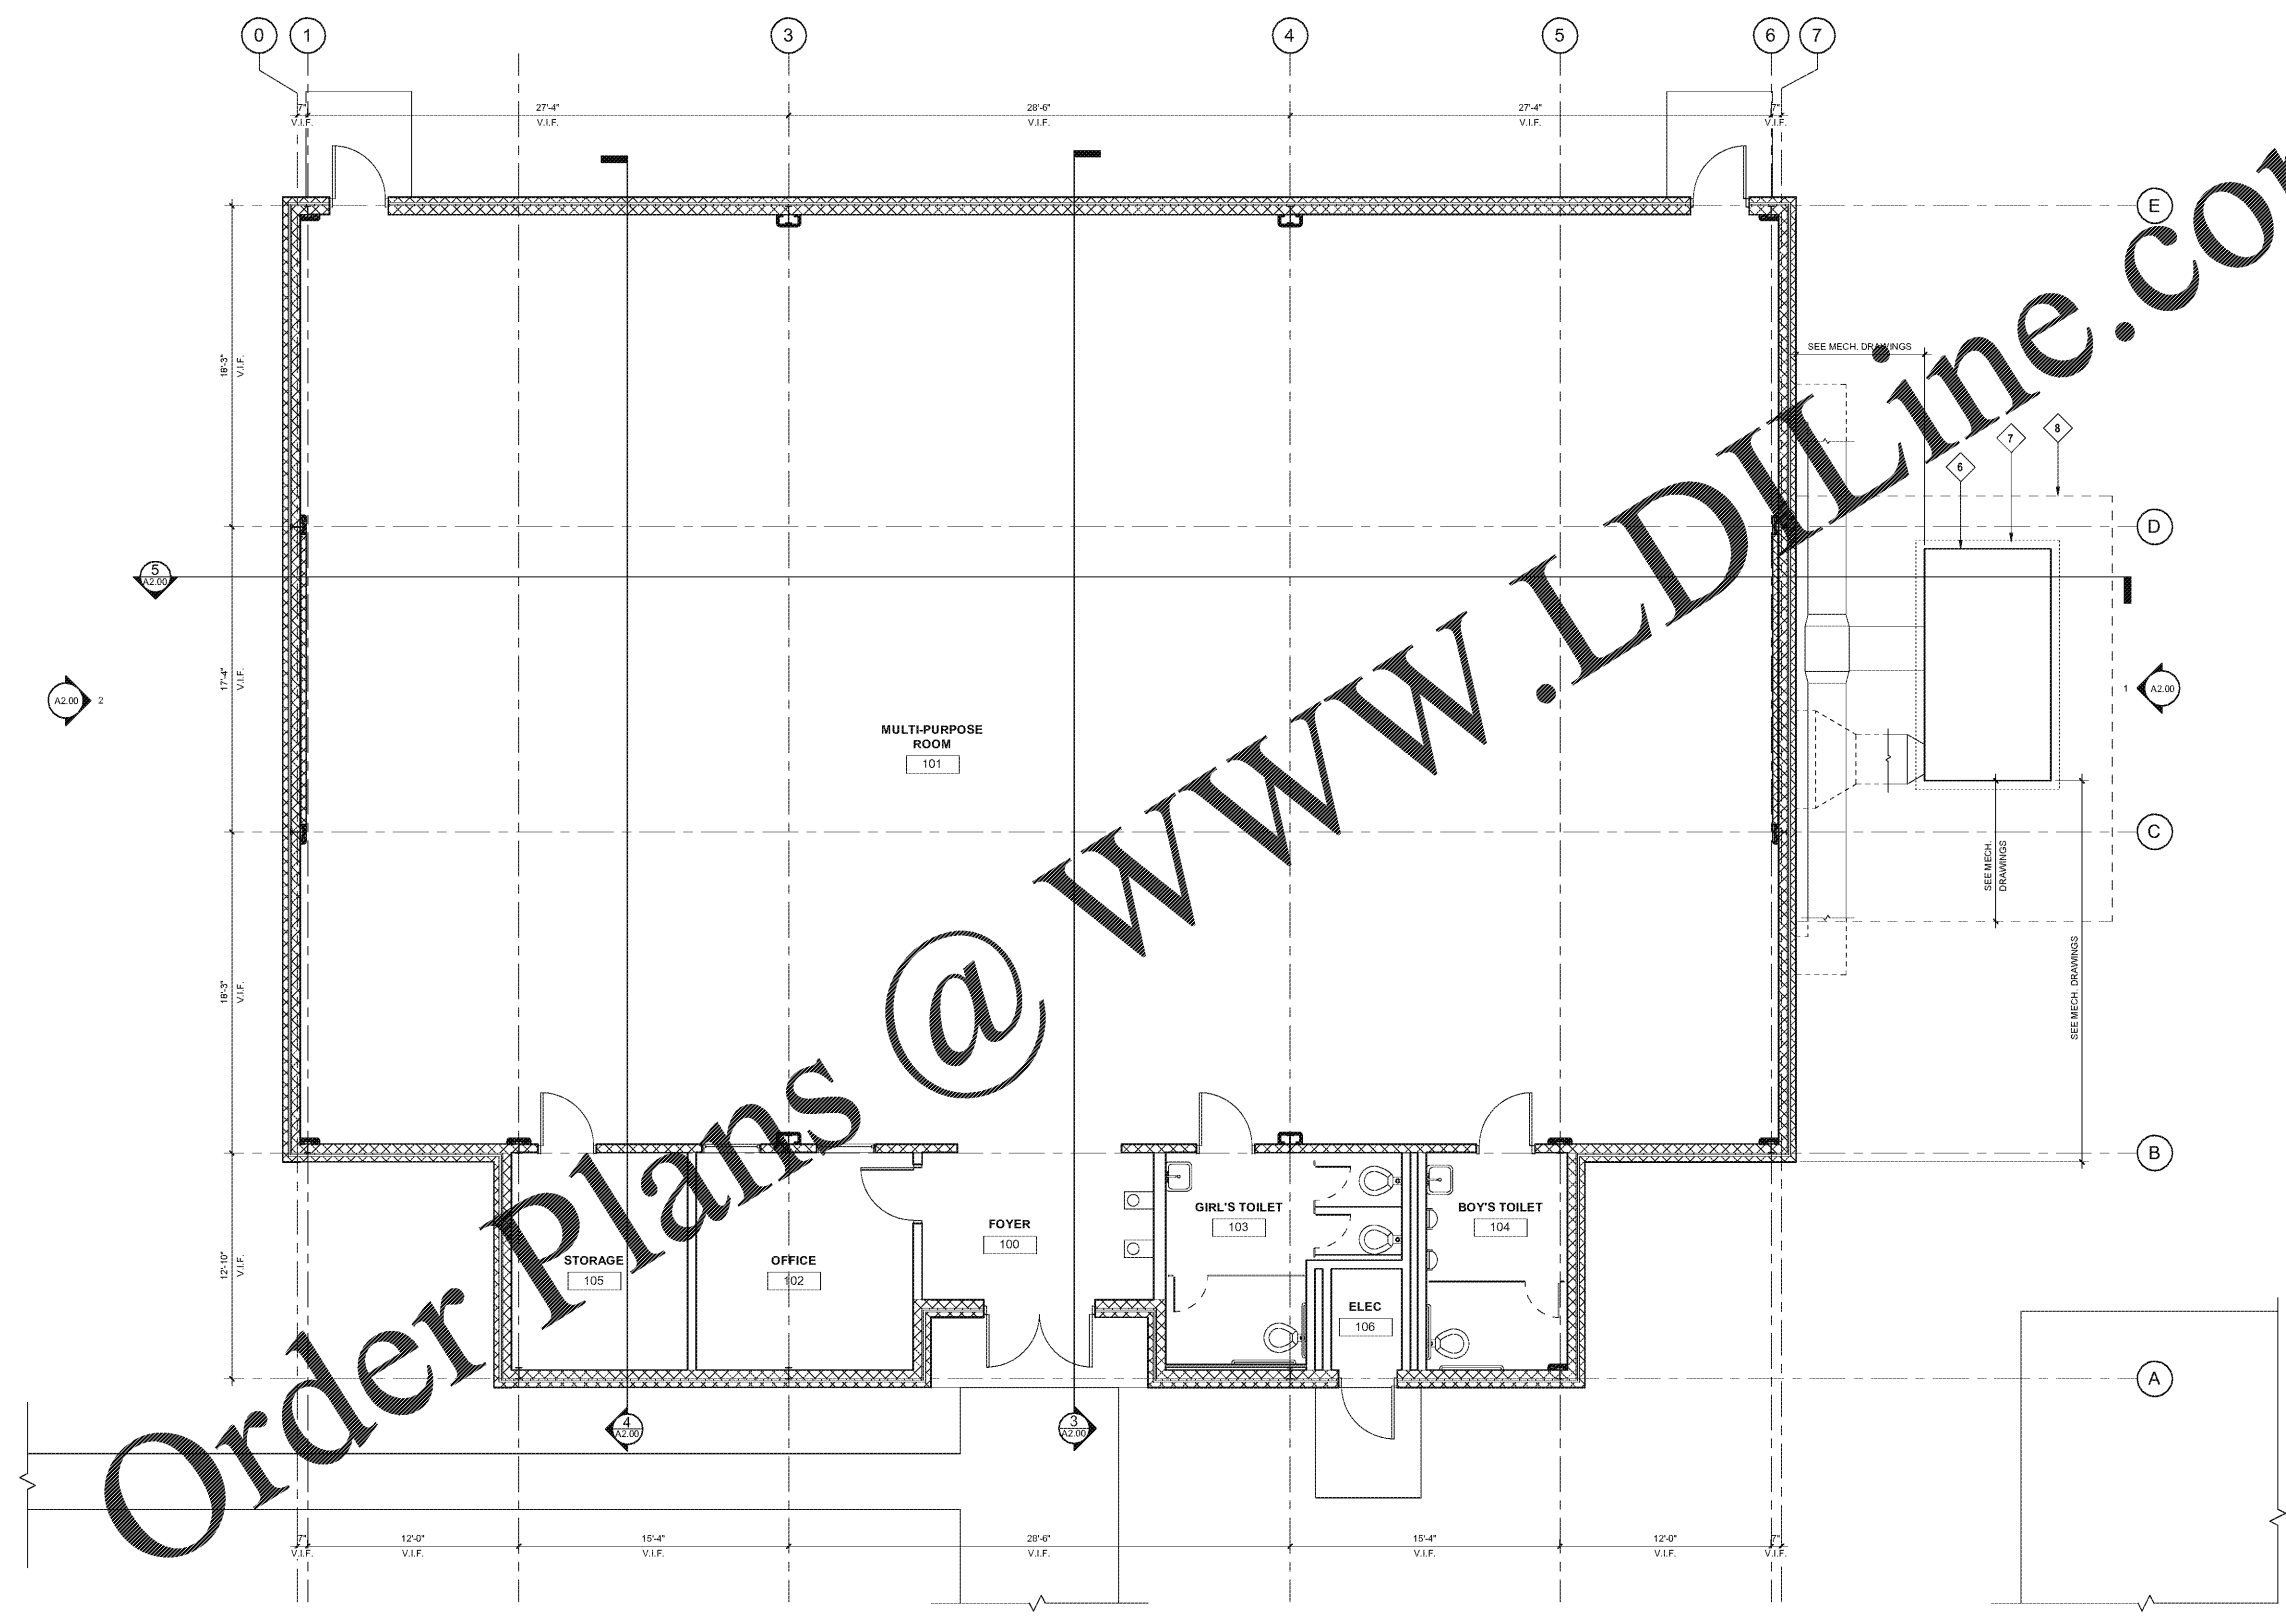

Order plans @ www.LDILine.com

1 FLOOR PLAN
1/4" = 1'-0"



100% CD SET	12/09/2019
JOLLY ES GYM HVAC DESIGN	
1070 Otello Ave, Clarkston, GA 30021	
 ARCHITECTURE INTERIORS PLANNING PROGRAM MANAGEMENT 1106 SPRING STREET, N.W. ATLANTA, GEORGIA 30309-2818 404-515-0508 404-515-0817 www.stanleylove-stanleypc.com	
DRAWING TITLE FLOOR PLAN	
SCALES AS STATED HEREON ARE VALID ON THE ORIGINAL DRAWING. THE DIMENSIONS OF ANYTHING SHOWN ON THESE DRAWINGS NOTED HEREON ARE HEREBY CHANGE BY THE HAND OF THE ORIGINAL SHEET CONSIDERING DIMENSIONS OF THE ORIGINAL DRAWING.	
THE DRAWING IS THE PROPERTY OF STANLEY LOVE STANLEY P.C. AND IS NOT TO BE REPRODUCED OR COPIED IN WHOLE OR IN PART. IT IS ON IT TO BE USED FOR THE PROJECT AND SITE SPECIFICALLY IDENTIFIED HEREON AND IS NOT TO BE USED ON ANY OTHER PROJECT. IT IS TO BE RETURNED UPON REQUEST.	
COPYRIGHT © 2019. ALL RIGHTS RESERVED. STANLEY LOVE STANLEY P.C. DRAWING NO.	
DATE	12/09/2019
PROJECT NO.	6919.3
DRAWING NO.	A1.00

RELEASED FOR CONSTRUCTION 12/09/2019