


GENERAL NOTES

 
1. REFER TO ARCHITECTURAL PLANS FOR INFORMATION ON FENCE AROUND AHU-1.
2. CONTRACTOR TO PROVIDE STRUCTURAL SUPPORT TO EXTERIOR DUCTWORK AS NECESSARY. REFER TO SPECIFICATIONS FOR INFORMATION ON EXTERIOR DUCTWORK AND REQUIREMENTS.

DRAWING NOTES

1. NEW ROUND DUCT TO BE FABRIC DUCT WITH INTERNAL SUPPORT. SEE M-401 FOR FABRIC DUCT DETAILS.
2. ADD ALTERNATE: PROVIDE NEW DOOR LOUVER AND INSTALL IN RESTROOM AND STORAGE DOORS. SEE SCHEDULE FOR LOUVER DIMENSIONS AND LOCATION.

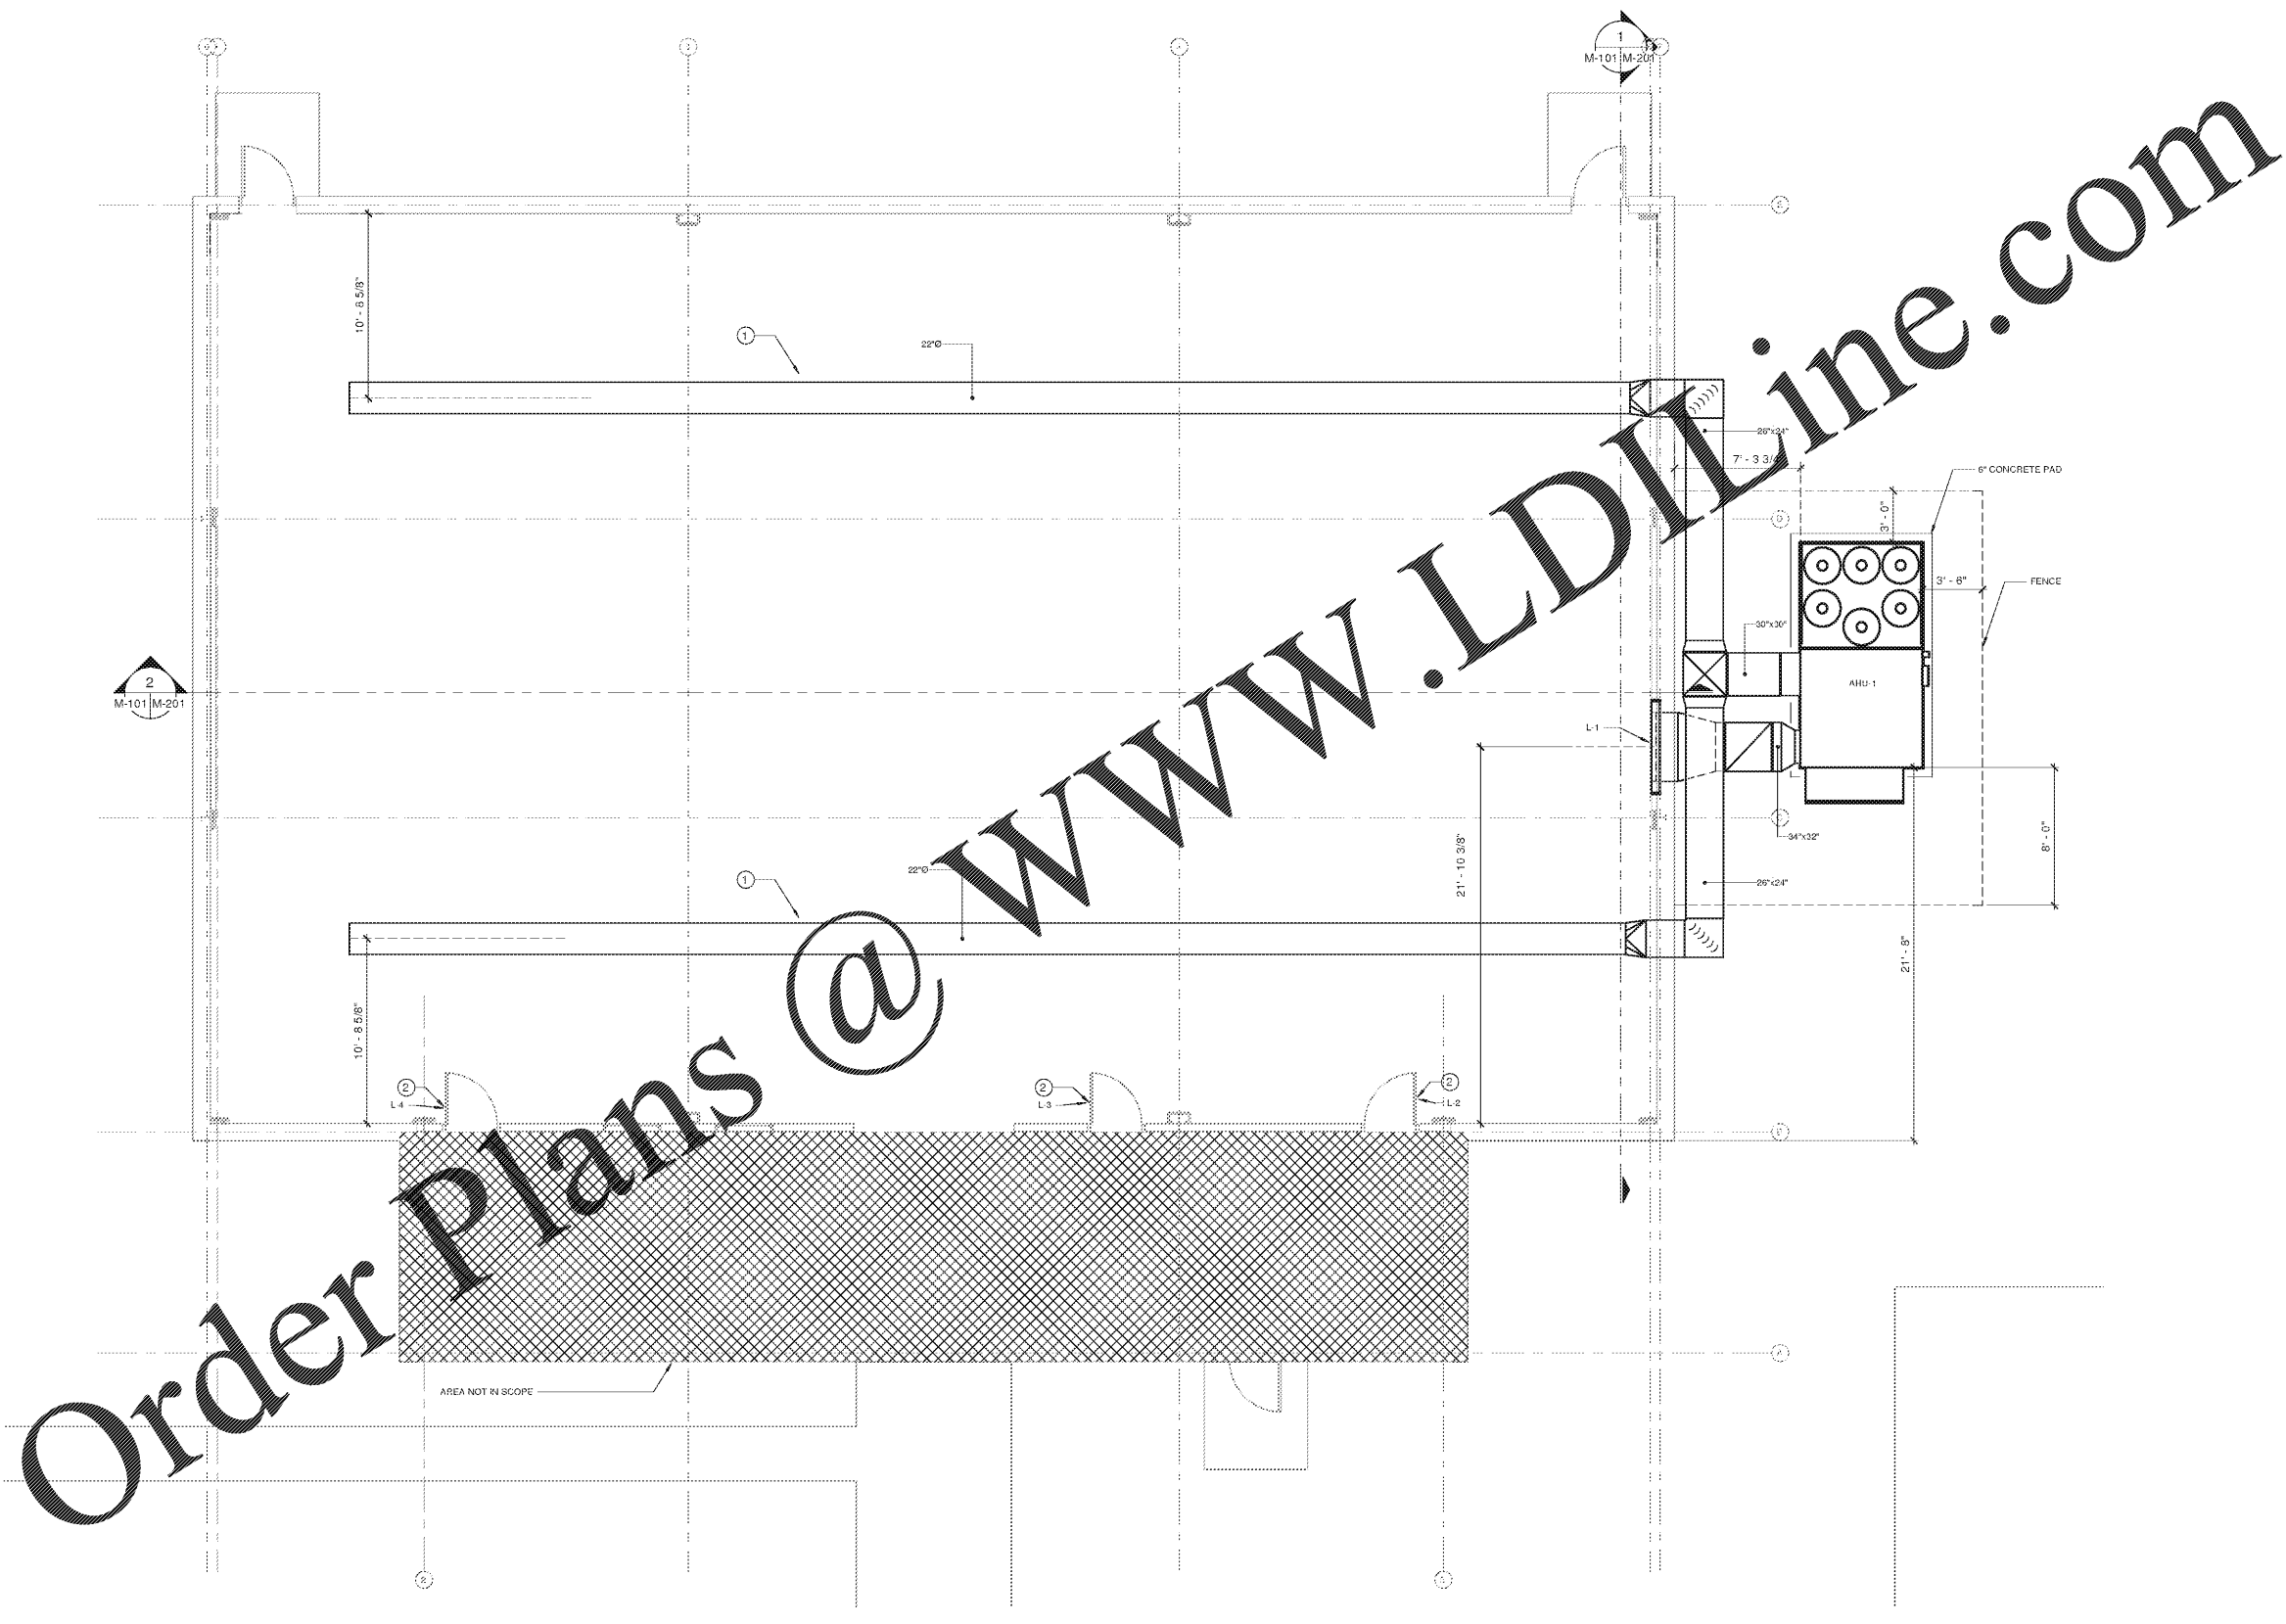

LEVEL 1 HVAC DUCTWORK PLAN
SCALE: 1/4" = 1'-0"



JOLLY ES GYM HVAC DESIGN
1070 Otello Ave, Clarkston, Ga 30021



ARCHITECTURE
INTERIORS PLANNING
PROGRAM MANAGEMENT
1100 SPRING STREET, N.W.
ATLANTA, GEORGIA 30309-3918
404.876.0288
www.stanleylove.com

DRAWING TITLE
**MECHANICAL LEVEL 1
DUCTWORK PLAN**



CONSULTANT
rmf Engineering
180 HARRISON DRIVE SUITE 720
ATLANTA, GA 30329 478.933.0020

SCALES AS STATED HEREON ARE VALID ON THE ORIGINAL DRAWING. THE DIMENSIONS OF WORK ARE AS SHOWN HEREON. THIS SCALE IS NOT TO BE USED FOR ANY OTHER PURPOSES. HEREON AND IS NOT TO BE USED ON ANY OTHER PROJECT. IT IS TO BE REPRODUCED UPON REQUEST.

COPYRIGHT © 2019. ALL RIGHTS RESERVED BY JOLLY ES GYM HVAC DESIGN, INC.
DRAWING NO.

DATE
12/09/2019
PROJECT NO.
6919.3
DRAWING NO.

M-101

12/09/2019
RELEASED FOR CONSTRUCTION