



Order Plans @ www.LDMLine.com

GENERAL NOTES

1. TOTAL DEVELOPED LENGTH OF NATURAL GAS PIPING IS 290 FEET, ACCOUNTING FOR FITTINGS. NATURAL GAS PIPING IS SIZED FOR PRESSURE OF 14" W.C. WITH A PRESSURE DROP OF 0.3" W.C.


DRAWING NOTES

① SET EXISTING PRESSURE REGULATOR TO 14" W.C.

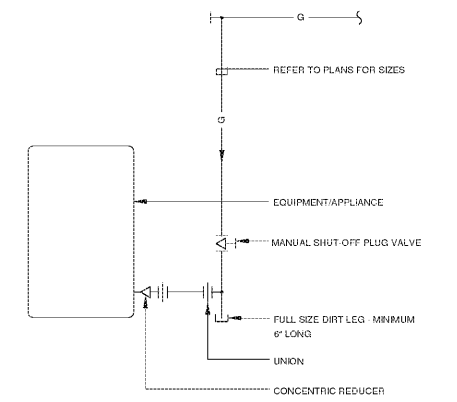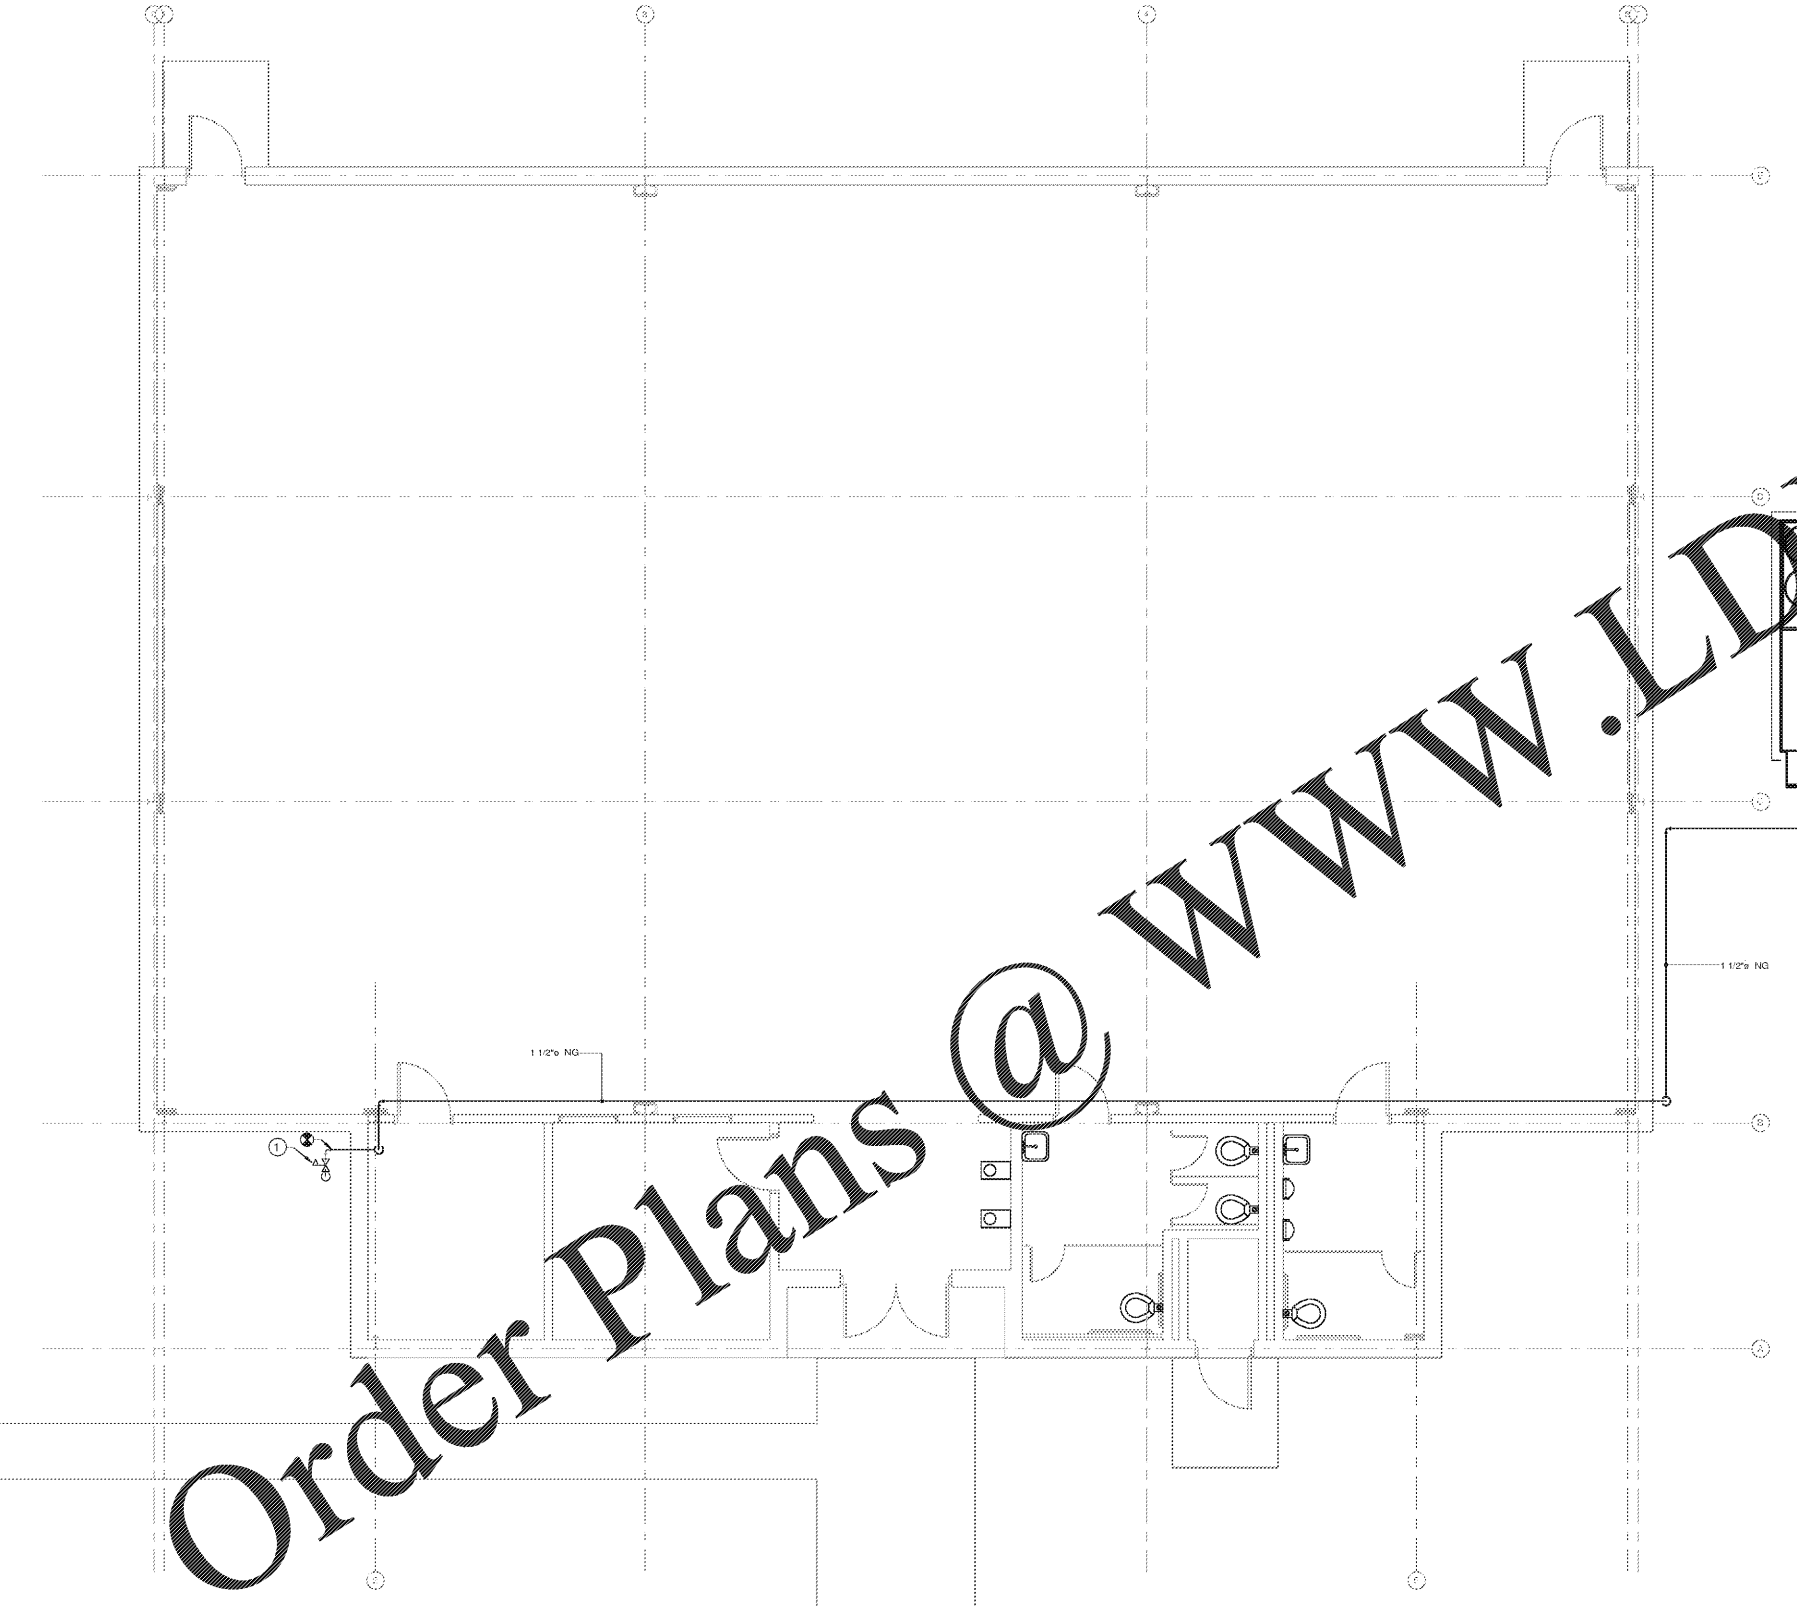

① **DETAIL - GAS EQUIPMENT CONNECTION**
SCALE: N.T.S.

 LEVEL 1 PLUMBING PLAN
SCALE: 1/4" = 1'-0"



| | |
|---|--|
| <p>JOLLY ES GYM HVAC DESIGN 1070 Otello Ave, Clarkston, Ga 30021</p> | <p>STANLEY LOVE STANLEY P & C ARCHITECTURE INTERIORS PLANNING PROGRAM MANAGEMENT 1188 SPRING STREET, N.W. ATLANTA, GEORGIA 30309 404.576.0286 www.stanleylove.com</p> |
| <p>GEORGIA PROFESSIONAL SEAL DANIEL W. WOOD</p> | |
| <p>rmf Engineering 882 HARRISON DRIVE SUITE 720 ATLANTA, GA 30329 678.932.0220</p> | |
| <p>12/09/2019 DATE 6919.3 PROJECT NO. DRAWING NO.</p> | |
| <p>P-101</p> | |

RELEASED FOR CONSTRUCTION