


**DRAWING NOTES**

- 1 LOCATION OF EXISTING PANELBOARD HP. REMOVE (3) EXISTING 20A/1P SPARE CIRCUIT BREAKERS AND PROVIDE 70A/3P CIRCUIT BREAKER FOR AHU-1. MATCH EXISTING CIRCUIT BREAKER CHARACTERISTICS INCLUDING MANUFACTURER, TYPE AND KAIC RATING.
- 2 PROVIDE DIRECT BURIED BRANCH CIRCUIT FOR AHU-1 IN SCHED 40 PVC AT MINIMUM 18 INCHES TO TOP OF DUCT BELOW FINISHED GRADE. ELBOWS AND FITTINGS SHALL BE DFC AT CHANGES OF DIRECTION IN DUCT RUN. RUN CONDUIT AS DIRECTLY AS POSSIBLE MINIMIZING DISTURBANCES TO HARDSCAPE. PROVIDE PULL BOXES OR HANDHOLES AS REQUIRED TO COMPLY WITH NEC 358.25. FIELD VERIFY EXACT ROUTING LOCATION. COORDINATE WITH EXISTING UTILITIES.

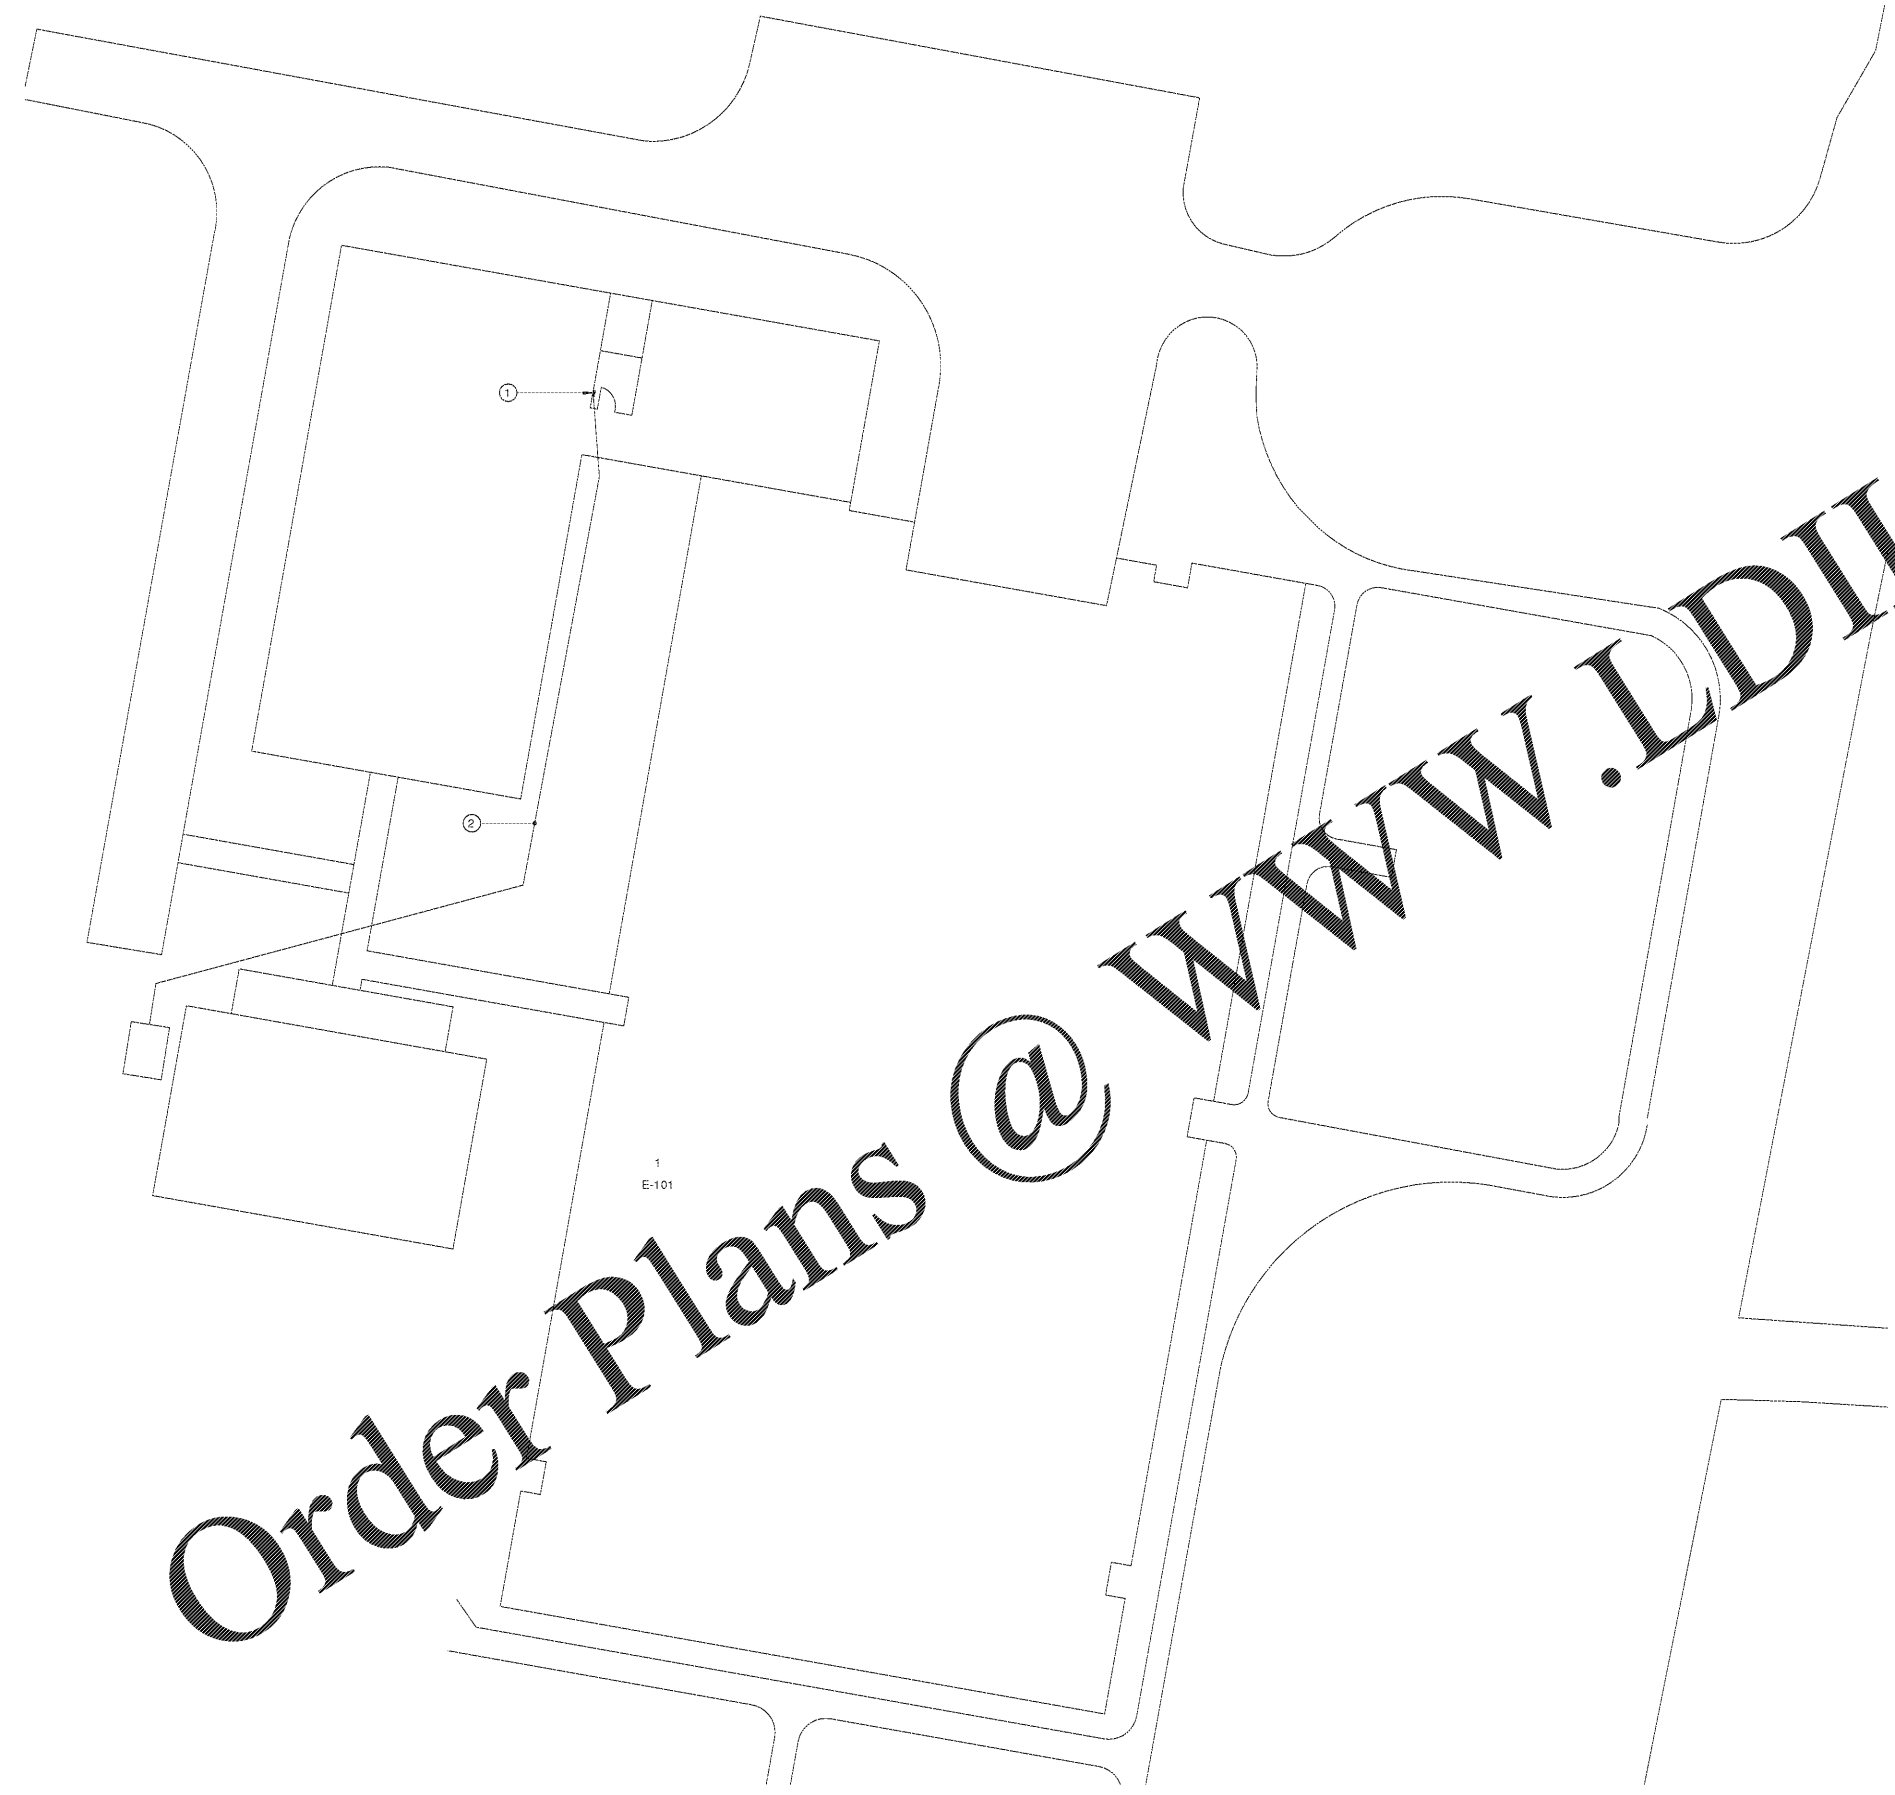

Order Plans @ www.LDILine.com

NO.	DATE	DESCRIPTION

**JOLLY ES GYM HVAC DESIGN**  
1070 Otello Ave, Clarkston, Ga 30021

**STANLEY LOVE STANLEY P & C**  
ARCHITECTURE  
INTERIORS PLANNING  
PROGRAM MANAGEMENT  
1188 SPRING STREET, N.W.  
ATLANTA, GEORGIA 30309  
404.876.0288  
www.stanleylove.com

DRAWING TITLE  
**ELECTRICAL SITE PLAN**



**mfEngineering**  
382 HARRISON DRIVE SUITE 170  
ATLANTA, GA 30328 678.919.9220

SCALES AS STATED HEREON ARE VALID ON THE ORIGINAL DRAWING. THE DIMENSIONS OF WORK ARE SHOWN HEREON. THE SCALES OF NOTED HEREON ARE SUBJECT TO THE SCALES OF THE OVERALL SHEET OR PORTIONS OF THE SHEET. NO CONFORMANCE DANGEROUS OF THE ORIGINAL DRAWING.

THE DRAWING IS THE PROPERTY OF STANLEY LOVE STANLEY P & C AND IS TO BE RETURNED TO THE OFFICE OF ORIGIN OR TO THE PROJECT MANAGER. IT IS TO BE USED ONLY FOR THE PROJECT AND IS NOT TO BE REPRODUCED OR COPIED FOR ANY OTHER PROJECT. IT IS TO BE RETURNED UPON REQUEST.

COPYRIGHT © 2019. ALL RIGHTS RESERVED BY STANLEY LOVE STANLEY P & C.  
DRAWING NO.

DATE  
12/09/2019  
PROJECT NO.  
6919.3  
DRAWING NO.

**E-100**

RELEASED FOR CONSTRUCTION