


Keynote Legend	
Key Value	Keynote Text
6	AIR HANDLING UNIT. SEE MECHANICAL DRAWINGS.
7	CONCRETE PAD. SEE CIVIL AND MECHANICAL DRAWINGS.
8	CHAIN LINK FENCE. SEE CIVIL DRAWINGS.
13	NEW SIDE WALK. SEE CIVIL DRAWINGS.
17	NEW EXTERIOR SUPPLY AIR DUCTWORK AND SUPPORT AS SHOWN ON DETAILS 7, 9 AND 10 ON MECHANICAL DRAWINGS M-401.

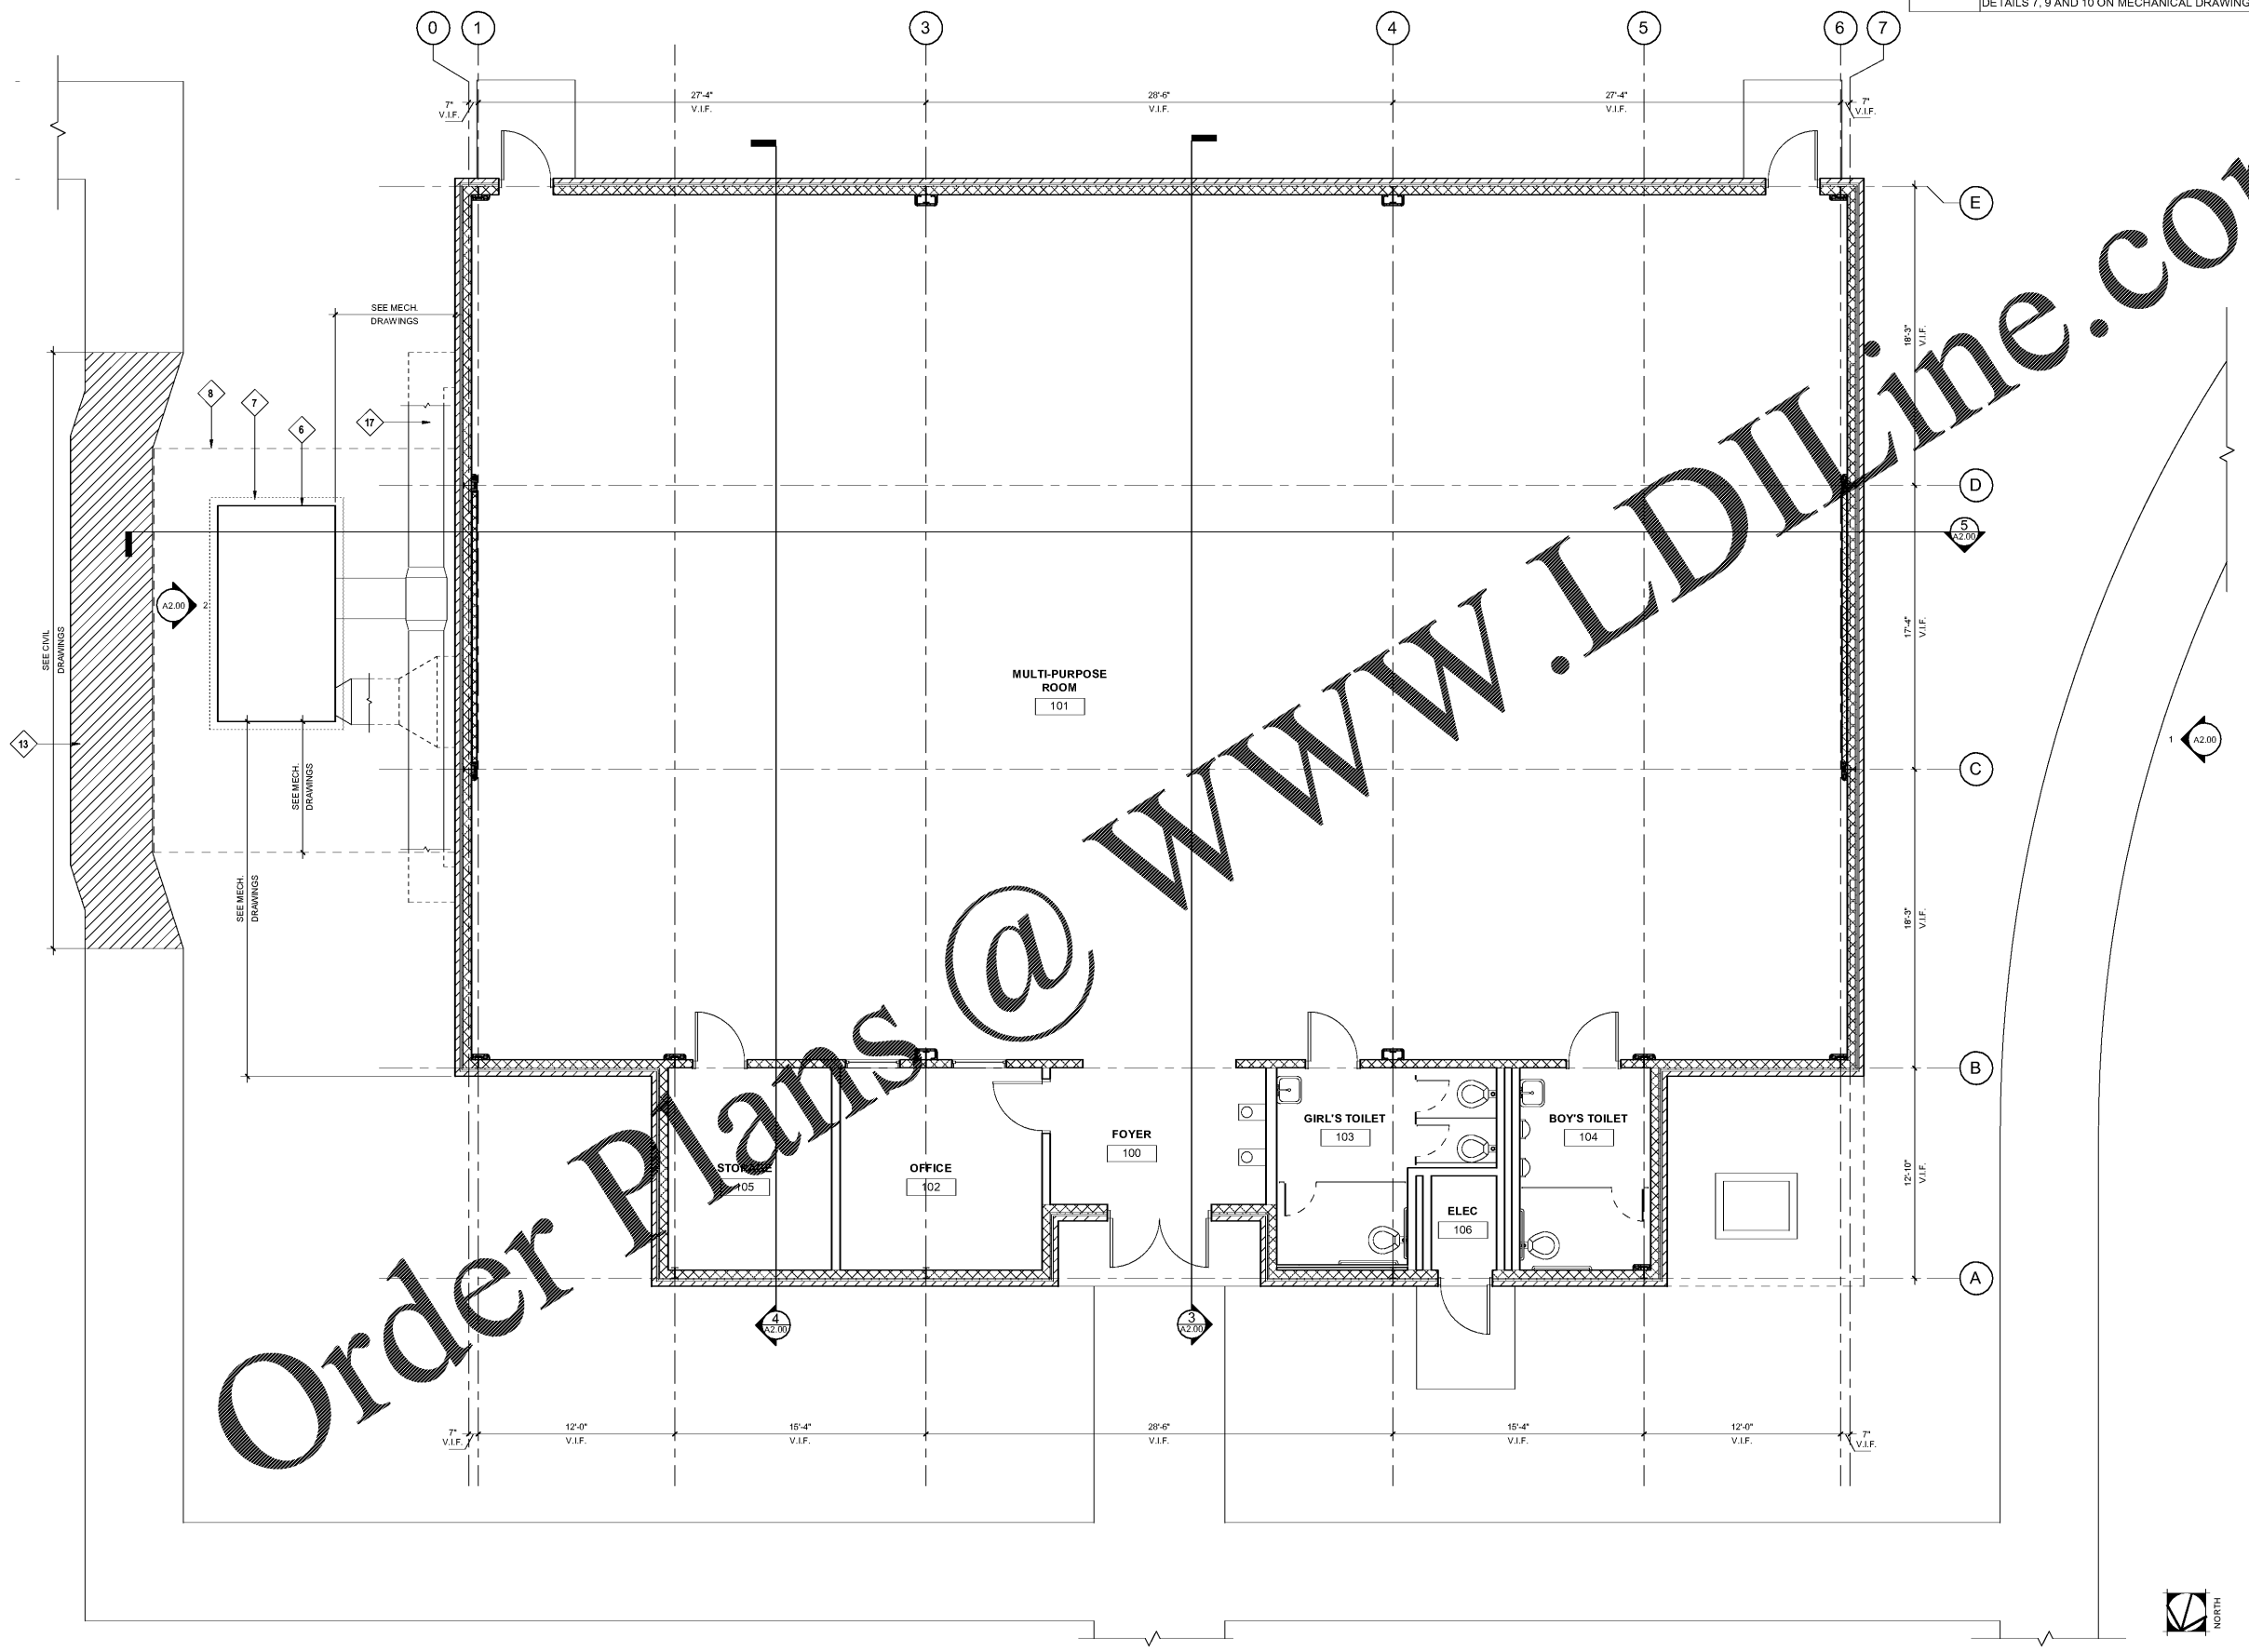

Order Plans @ WWW.LDILine.com

**KITTRIDGE MAGNET SCHOOL
GYM HVAC DESIGN**
1663 E. Nancy Creek Drive
Atlanta, Georgia 30319

**STANLEY
LOVE
STANLEY
P A C**
ARCHITECTURE
INTERIORS PLANNING
PROGRAM MANAGEMENT
1186 SPRING STREET, N.W.
ATLANTA, GEORGIA 30309
404-525-2526
www.stanleylove-stanley.com

DRAWING TITLE
FLOOR PLAN



SCALES AS STATED HEREIN ARE VALID ON THE ORIGINAL DRAWING. THE DIMENSIONS OF WHICH ARE INDICATED BY THE SCALE. NOTED HEREIN ARE HEREBY CHANGE BY THE HAND OF THE ORIGINAL SHEET CONTAINING OF THE PRINT TO CORRESPONDING DIMENSIONS OF THE ORIGINAL DRAWING.
THIS DRAWING IS THE PROPERTY OF STANLEY, LOVE & STANLEY, P.C. AND IS NOT TO BE REPRODUCED OR COPIED IN WHOLE OR IN PART, IT IS ON IT TO BE USED FOR THE PROJECT AND SITE SPECIFICALLY IDENTIFIED HEREIN AND IS NOT TO BE USED ON ANY OTHER PROJECT. IT IS TO BE RETURNED UPON REQUEST.
COPYRIGHT © 2018. ALL RIGHTS RESERVED.
STANLEY, LOVE & STANLEY, P.C.
DRAWING NO.

DATE
01/06/2020
PROJECT NO.
6919.4
DRAWING NO.

A1.00

1/24/2020 3:48:04 PM

① FLOOR PLAN
1/4" = 1'-0"

RELEASED FOR CONSTRUCTION 01/06/2020