


Keynote Legend	
Key Value	Keynote Text
2	FABRIC DUCT. COORDINATE SIZE, LOCATION AND ATTACHMENT WITH MECHANICAL DRAWINGS.
3	NEW RETURN AIR LOUVER. COORDINATE SIZE AND LOCATION WITH MECHANICAL DRAWINGS.
17	NEW EXTERIOR SUPPLY AIR DUCTWORK AND SUPPORT AS SHOWN ON DETAILS 7, 9 AND 10 ON MECHANICAL DRAWINGS M-401.

NOTE: REFER TO A 2.00 AND A3.00 FOR LOCATIONS AND EXTENT OF NEW METAL WALL PANEL(S) AND LINER PANEL(S).

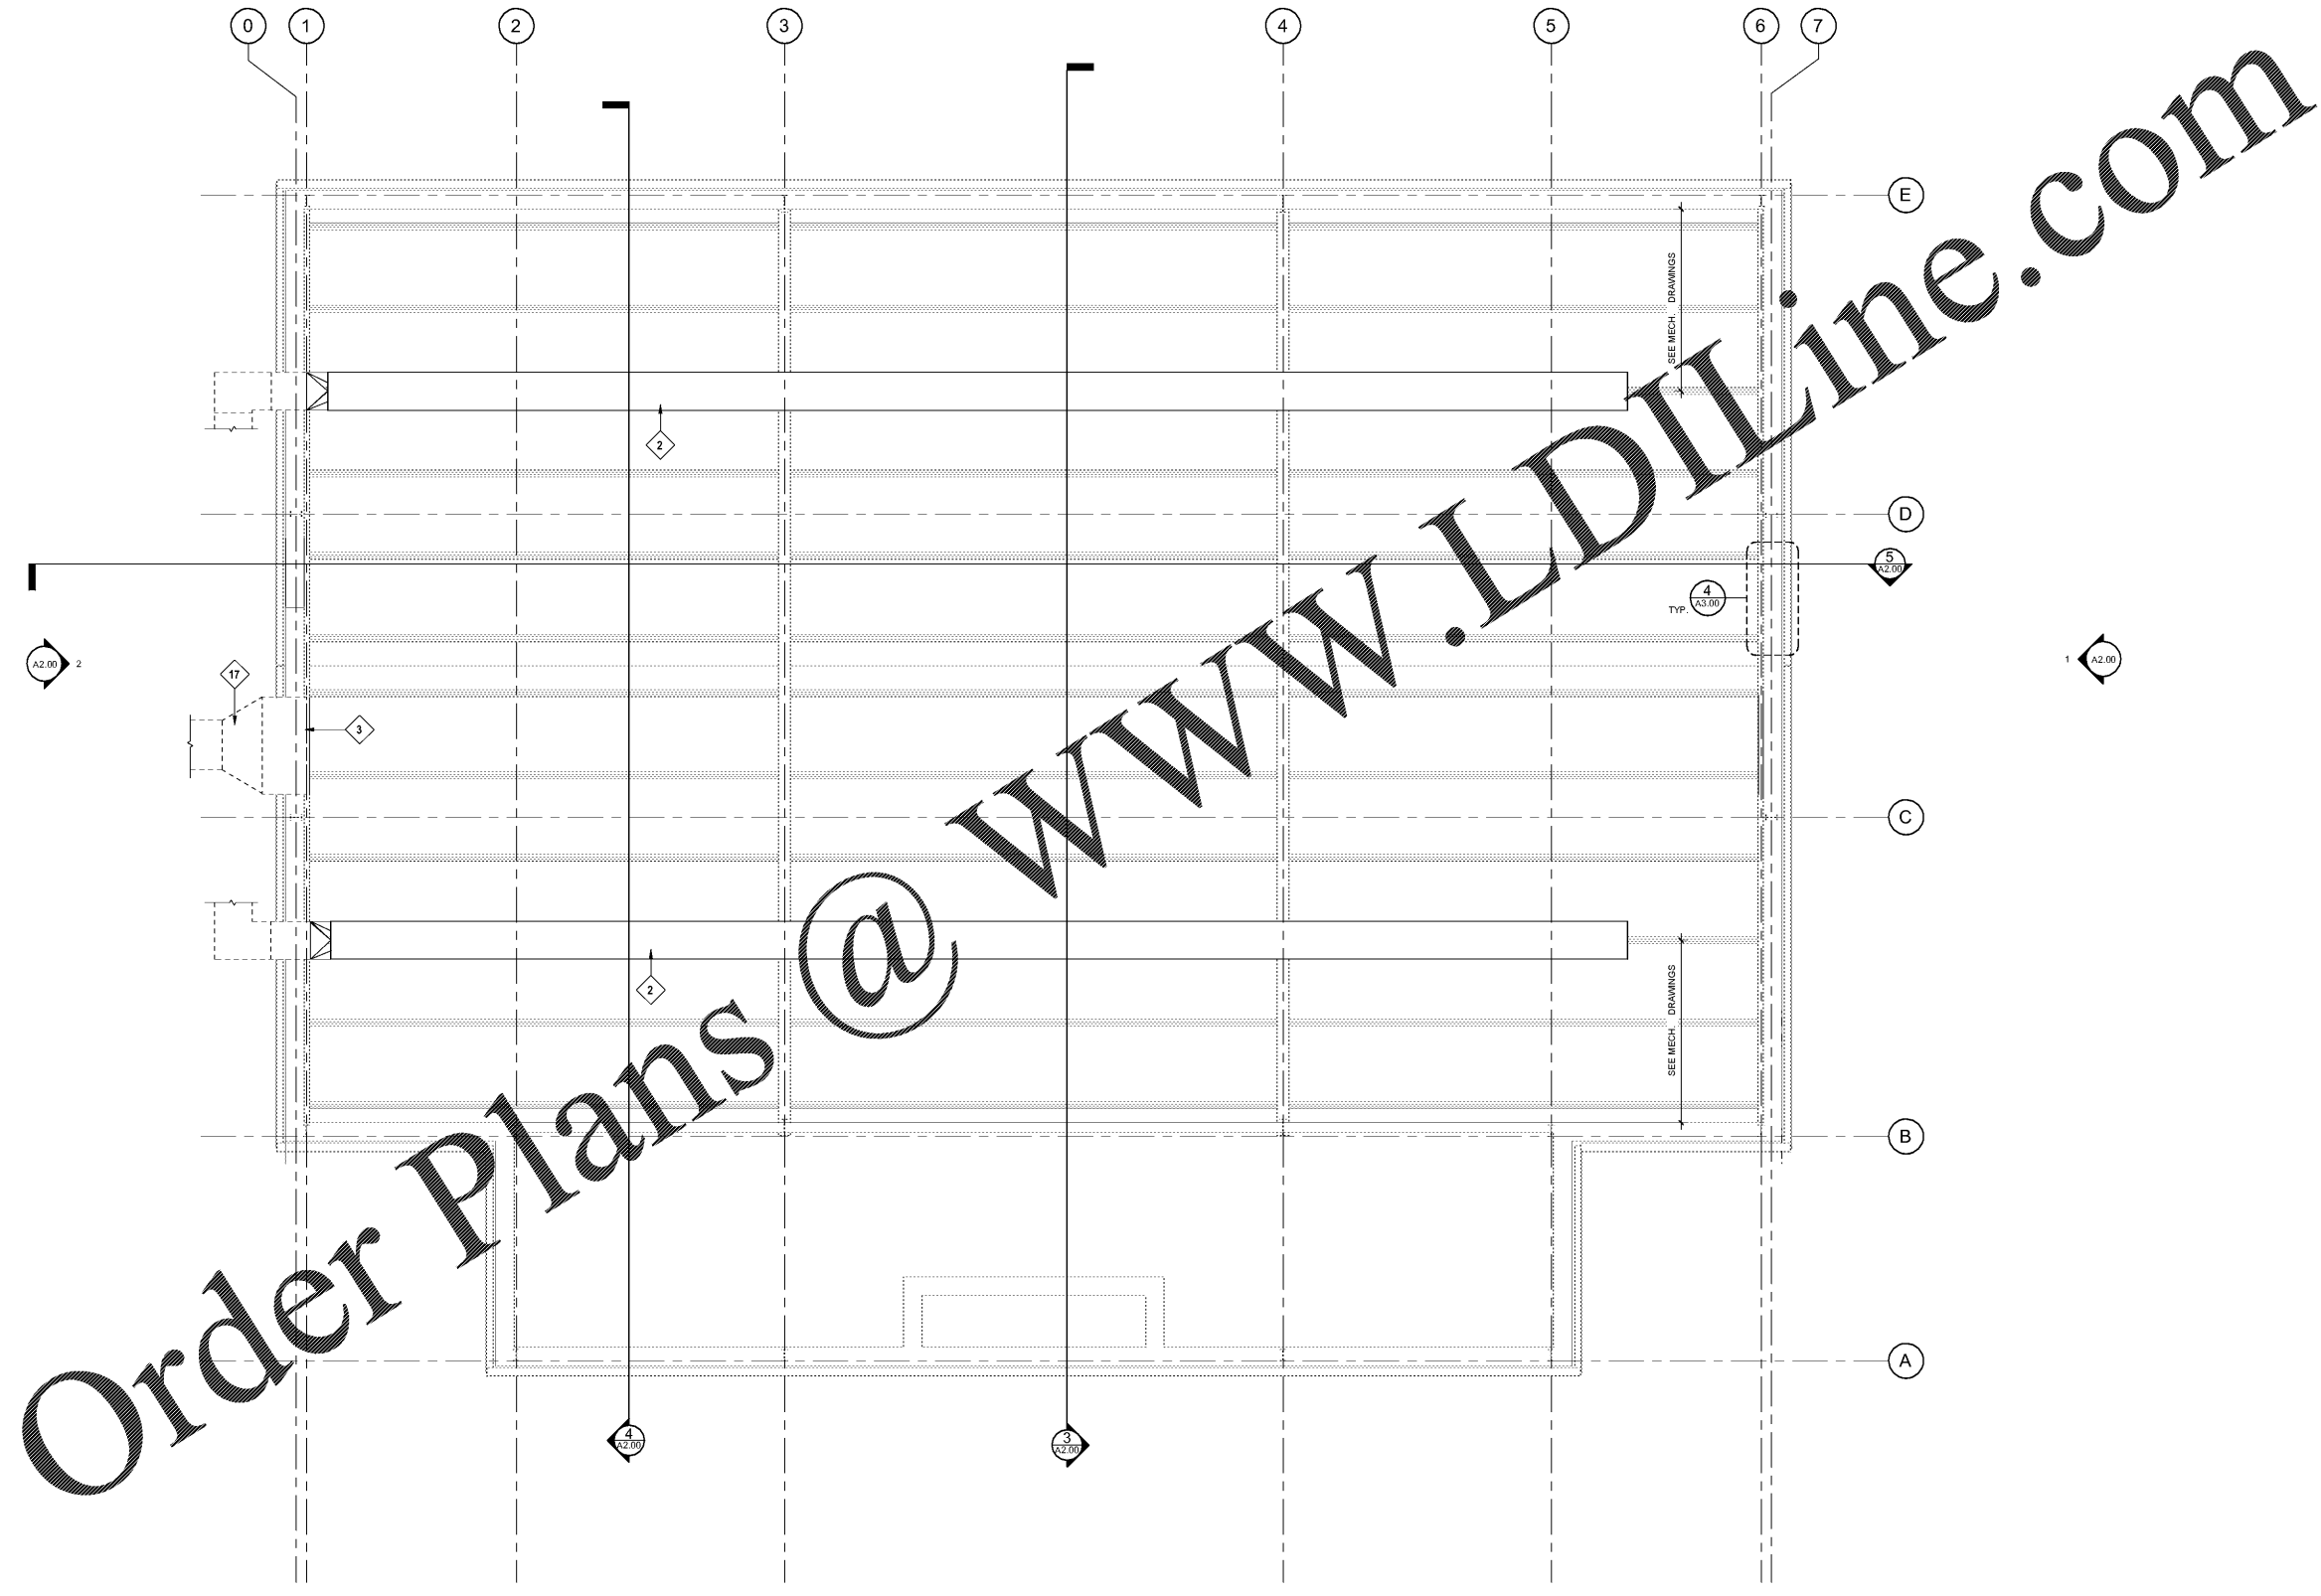

Order Plans @ WWW.LDILine.com

1/24/2020, 3:48:05 PM

REFLECTED CEILING PLAN
1/4" = 1'-0"



100% CD SET 01/06/2020

**KITTRIDGE MAGNET SCHOOL
GYM HVAC DESIGN**
1663 E. Nancy Creek Drive
Atlanta, Georgia 30319

STANLEY
LOVE
STANLEY
P A C

ARCHITECTURE
INTERIORS PLANNING
PROGRAM MANAGEMENT

1166 SPRING STREET, N.W.
ATLANTA, GEORGIA 30309-3818
404-515-2008
www.stanleylove-stanley.com

DRAWING TITLE
REFLECTED CEILING
PLAN

PROFESSIONAL SEAL
GEORGIA
REGISTERED
No. 2920
ARCHITECT
WILLIAM J. STANLEY
CONSULTANT

SCALES AS SHOWN HEREIN ARE VALID ON THE ORIGINAL DRAWING. THE DIMENSIONS OF WHICH ARE EXCEPTED. THE SCALE NOTED HEREIN ARE HEREBY CHANGE BY THE PART OF THE OVERALL SHEET CORRECTING OF THE PRINT TO CORRESPONDING DIMENSIONS OF THE ORIGINAL DRAWING.

THIS DRAWING IS THE PROPERTY OF STANLEY LOVE STANLEY P.C. AND IS NOT TO BE REPRODUCED OR COPIED IN WHOLE OR IN PART. IT IS TO BE USED ONLY FOR THE PROJECT AND SITE SPECIFICALLY IDENTIFIED HEREIN AND IS NOT TO BE USED ON ANY OTHER PROJECT. IT IS TO BE RETURNED UPON REQUEST.

COPYRIGHT © 2018. ALL RIGHTS RESERVED.
STANLEY, LOVE STANLEY P.C.
DRAWING NO.

DATE
01/06/2020

PROJECT NO.
6919.4

DRAWING NO.
A1.10

RELEASED FOR CONSTRUCTION 01/06/2020