


**DRAWING NOTES**

- ① EXISTING POLE MOUNTED UTILITY TRANSFORMER 300KVA, 20KV PRIMARY - 277/480V SECONDARY.
- ② EXISTING SERVICE ENTRANCE SWITCHBOARD PA, UTILITY PROVIDED 12 MONTH PEAK KW - 259KW, TOTAL LOAD REQUIRED = (259.8 KVA x 1.25) + 39.24KVA = 443.92KVA.
- ③ EXISTING MAIN DISTRIBUTION PANEL BOARD "PA" IS TO BE REPLACED. CONTRACTOR TO REPLACE PANEL AND CIRCUIT BREAKERS AND RECONNECT EXISTING LOADS.

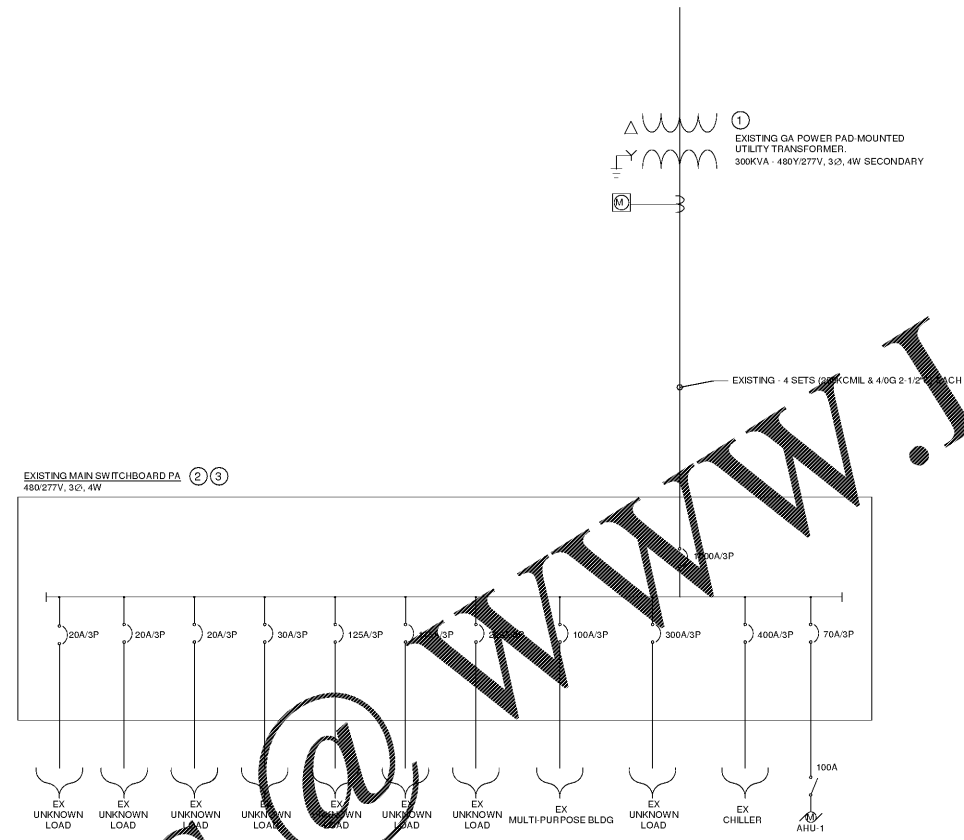

① **DETAIL - ONE-LINE DIAGRAM**  
SCALE: N.T.S.

Order Plans

WWW.LDILine.com

REV	DESCRIPTION	DATE

**KITTRIDGE MAGNET SCHOOL  
GYM HVAC DESIGN**  
1633 E. Nancy Creek Drive  
Atlanta, Georgia 30319

**STANLEY  
LOVE  
STANLEY  
P A C**

ARCHITECTURE  
INTERIORS PLANNING  
PROGRAM MANAGEMENT

1186 SPRING STREET, N.W.  
ATLANTA, GEORGIA 30309-3919  
404.576.0536  
404.576.0877  
www.stanleylove-stanley.com

DRAWING TITLE  
**ELECTRICAL ONE-LINE  
DIAGRAM**



CONSULTANT

SCALES AS STATED HEREON ARE VALID ON THE ORIGINAL DRAWING. THE DIMENSIONS OF ANY INSTRUMENTS SHOWN HEREON SHALL BE THE DIMENSIONS OF THE INSTRUMENTS AS SHOWN ON THE ORIGINAL DRAWING. THE DRAWING IS THE PROPERTY OF STANLEY LOVE-STANLEY, P.C. AND IS NOT TO BE REPRODUCED OR COPIED IN WHOLE OR IN PART, IN ANY MANNER, WITHOUT THE WRITTEN PERMISSION OF STANLEY LOVE-STANLEY, P.C. IF THIS DRAWING IS USED FOR ANY OTHER PROJECT, IT IS TO BE RETURNED UPON REQUEST.

COPYRIGHT © 2016. ALL RIGHTS RESERVED BY STANLEY LOVE-STANLEY, P.C.

DATE	01/06/2020
PROJECT NO.	6919.4
DRAWING NO.	E-501

E-501