


Keynote Legend	
Key Value	Keynote Text
D1	REMOVE EXISTING GAS-FIRED UNIT HEATERS. SEE MECHANICAL DRAWINGS.
D2	REMOVE EXISTING INTAKE LOUVER SYSTEM TO EXTENT INDICATED. SEE MECHANICAL DRAWINGS.
D4	REMOVE EXISTING WALL-MOUNTED EXHAUST FAN SYSTEM TO EXTENT INDICATED. SEE MECHANICAL DRAWINGS.
D5	REMOVE FULL METAL WALL PANEL(S) IN THIS AREA, AS REQUIRED, FOR INSTALLATION OF NEW EXTERIOR METAL WALL PANEL(S).
D6	REMOVE FULL LINER WALL PANEL(S) IN THIS AREA, AS REQUIRED, FOR INSTALLATION OF NEW METAL LINER PANEL(S).
D7	REMOVE GAS HEATER VENT PIPING THROUGH WALL. FIELD VERIFY LOCATION. SEE PLUMBING DRAWINGS.

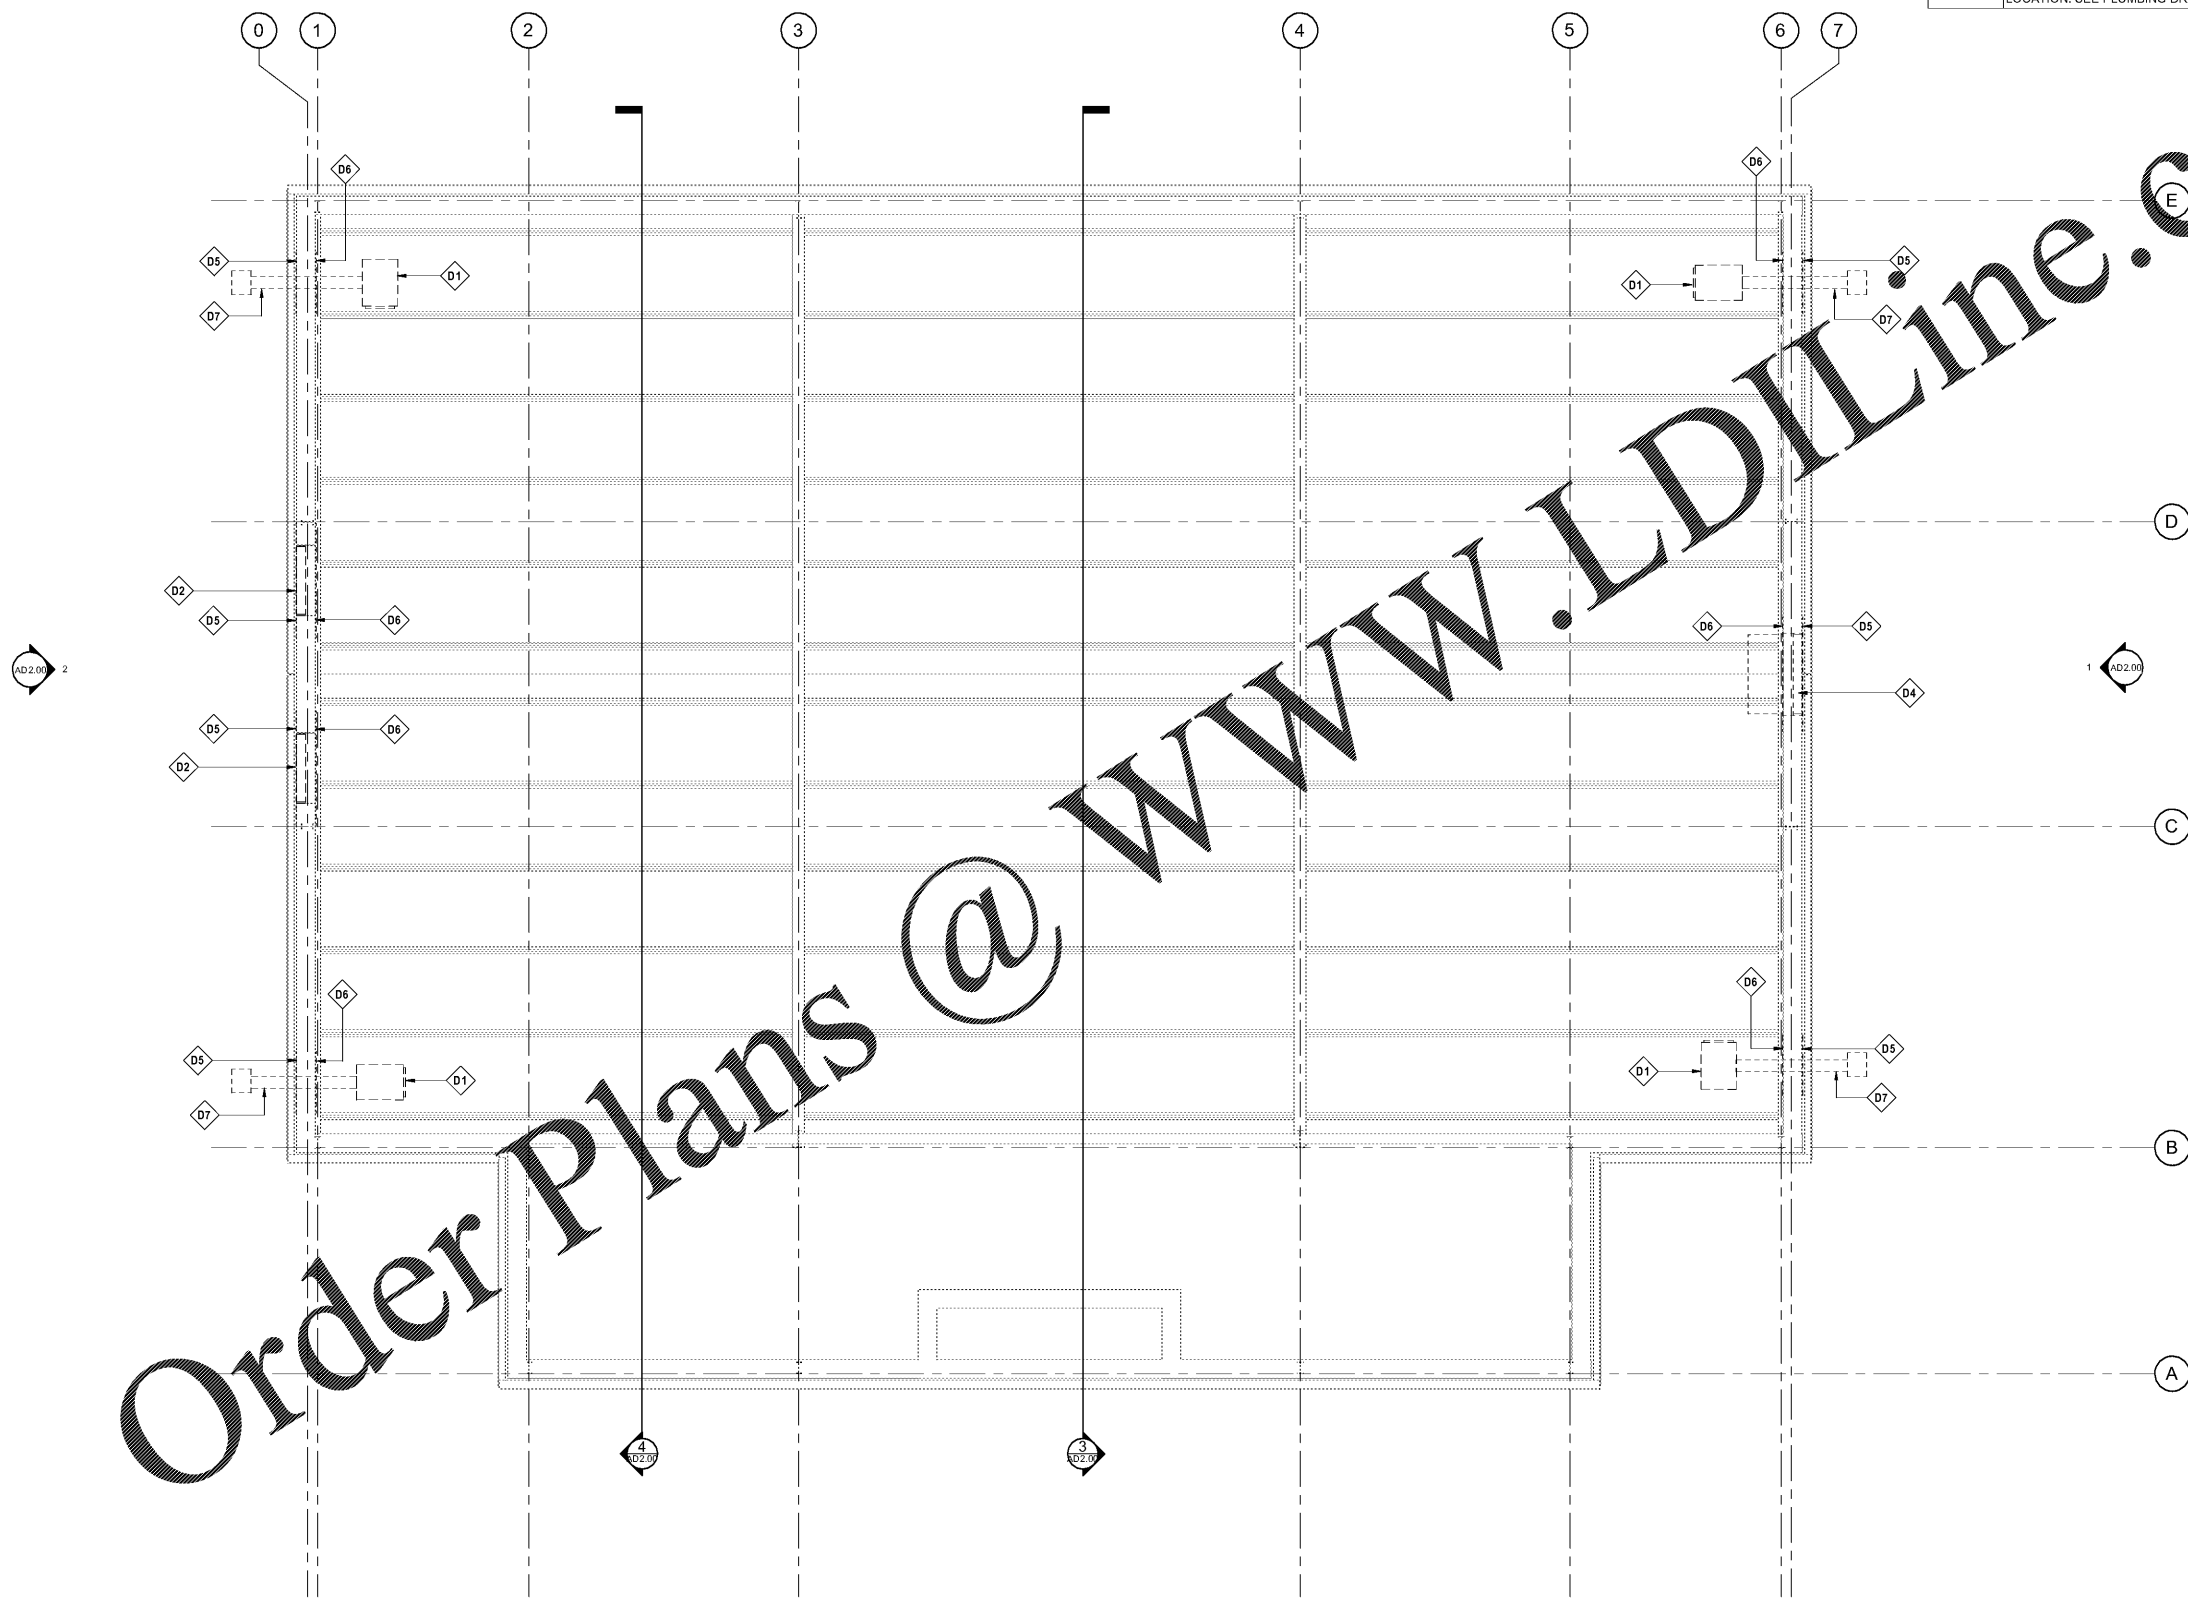

AD2.00 2

AD2.00 1

Order Plans @ www.LDILine.com

REFLECTED CEILING PLAN - DEMOLITION
1/4" = 1'-0"



SHADOW ROCK ELEMENTARY SCHOOL
GYM HVAC DESIGN
1040 Kingway Drive
Lithonia, Georgia 30058

STANLEY LOVE STANLEY P A C
ARCHITECTURE
INTERIORS PLANNING
PROGRAM MANAGEMENT
1186 SPRING STREET, N.W.
ATLANTA, GEORGIA 30309-3919
404-876-2506
www.stanleylove-stanley.com

DRAWING TITLE
REFLECTED CEILING PLAN - DEMOLITION



CONSULTANT

SCALES AS SHOWN HEREON ARE VALID ON THE ORIGINAL DRAWING. THE DIMENSIONS OF WHICH ARE INDICATED BY THE SCALE. NOTED HEREON ARE HEREBY CHANGE BY THE HAND OF THE ORIGINAL SHEET CONSIDERING OF THE PRINT TO CORRESPONDING DIMENSIONS OF THE ORIGINAL DRAWING.

THE DRAWING IS THE PROPERTY OF STANLEY LOVE STANLEY P C AND IS NOT TO BE REPRODUCED OR COPIED IN WHOLE OR IN PART. IT IS ONLY TO BE USED FOR THE PROJECT AND SITE SPECIFICALLY IDENTIFIED HEREON AND NOT TO BE USED ON ANY OTHER PROJECT. IT IS TO BE RETURNED UPON REQUEST.

COPYRIGHT © 2018. ALL RIGHTS RESERVED.
STANLEY LOVE STANLEY P C
DRAWING NO.

DATE: 01/31/2020
PROJECT NO: 6919.5
DRAWING NO:

AD1.00