


Keynote Legend	
Key Value	Keynote Text
2	FABRIC DUCT, COORDINATE SIZE, LOCATION AND ATTACHMENT WITH MECHANICAL DRAWINGS.
3	NEW RETURN AIR LOUVER, COORDINATE SIZE AND LOCATION WITH MECHANICAL DRAWINGS.
17	NEW EXTERIOR SUPPLY AIR DUCTWORK AND SUPPORT AS SHOWN ON DETAILS 7, 9 AND 10 ON MECHANICAL DRAWING M-401.
NOTE: REFER TO A 2.00 AND A3.00 FOR LOCATIONS AND EXTENT OF NEW METAL WALL PANEL(S) AND LINER PANEL(S).	

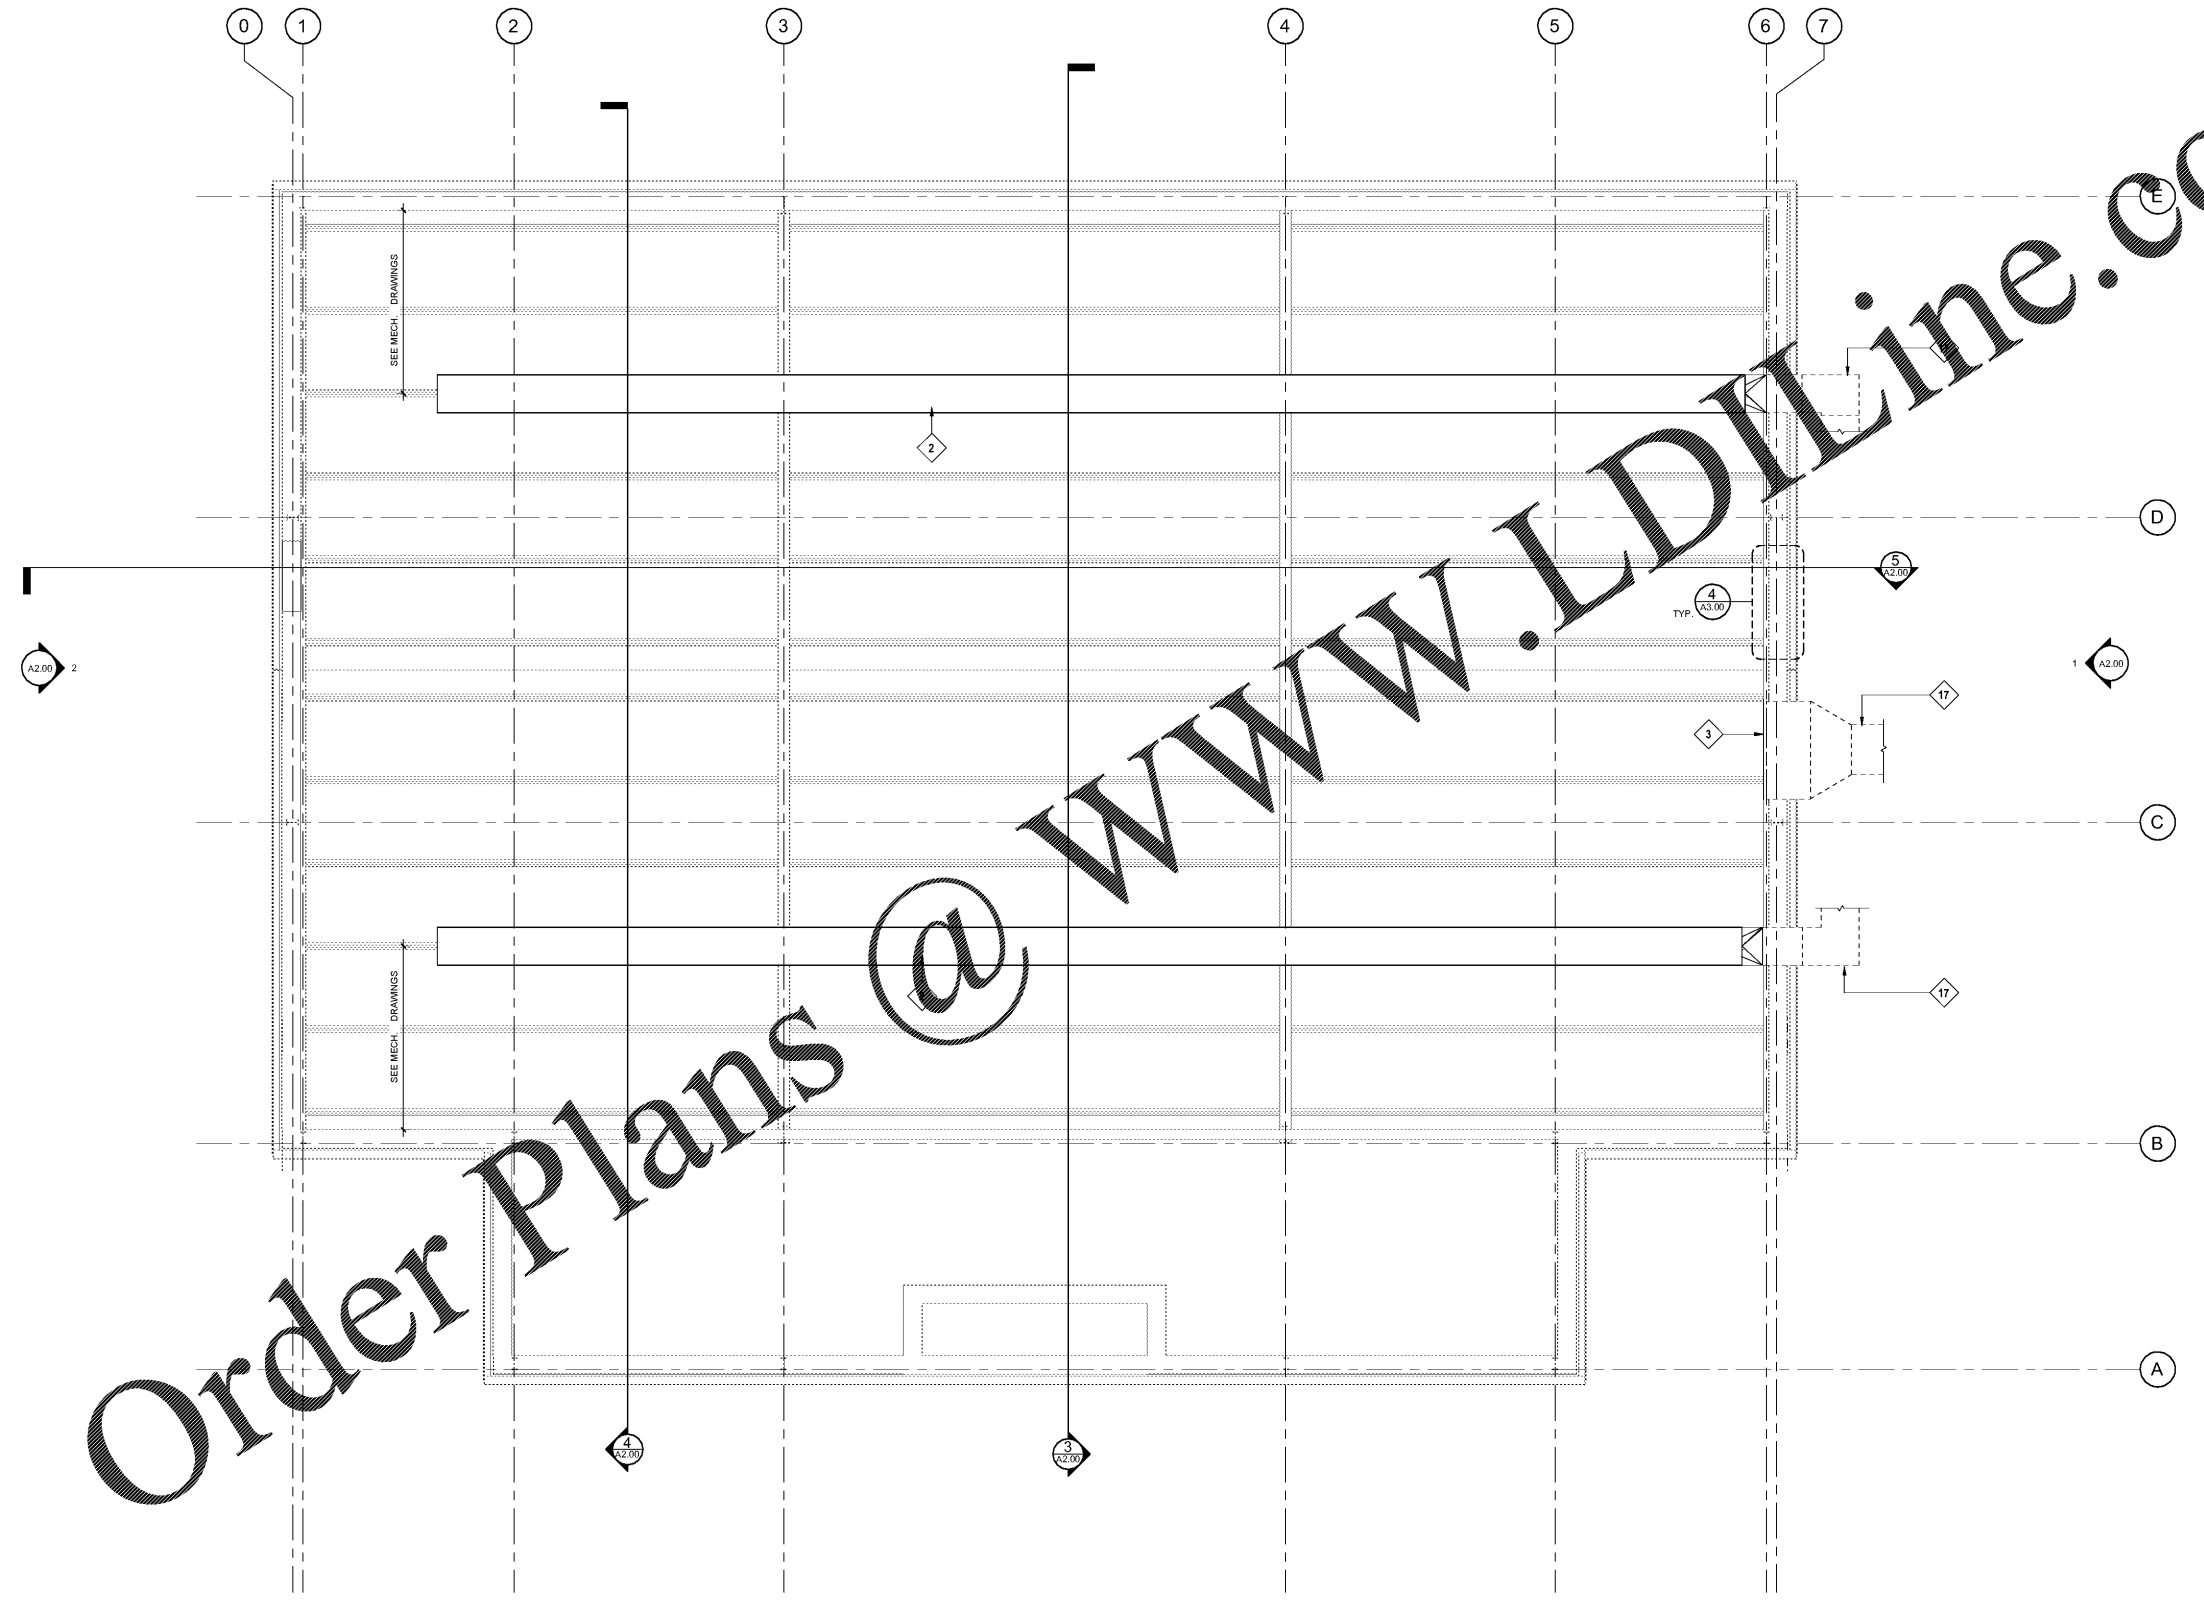

Order Plans @

WWW.LDILine.com

1 REFLECTED CEILING PLAN
1/4" = 1'-0"



100% CD SET 01/31/2020

**SHADOW ROCK ELEMENTARY SCHOOL
GYM HVAC DESIGN**
1040 Kingway Drive
Lithonia, Georgia 30058

**STANLEY
LOVE
STANLEY
P A C**

ARCHITECTURE
INTERIORS PLANNING
PROGRAM MANAGEMENT

1186 SPRING STREET, N.W.
ATLANTA, GEORGIA 30309-3918
404-875-2526
www.stanleylove-stanley.com

DRAWING TITLE
REFLECTED CEILING
PLAN

PROFESSIONAL SEAL
GEORGIA
REGISTERED
No. 23273
PROFESSIONAL
ARCHITECT
WILLIAM J. STANLEY
CONSULTANT

SCALES AS STATED HEREON ARE VALID ON THE ORIGINAL DRAWING. THE DIMENSIONS OF WHICH ARE INDICATED BY THE SCALE. NOTED HEREON ARE HEREBY CHANGE BY THE HAND OF THE OVERALL SHEET CONVENIENCE OF THE PRINT TO CORRESPONDING DIMENSIONS OF THE ORIGINAL DRAWING.

THIS DRAWING IS THE PROPERTY OF STANLEY, LOVE & STANLEY, P.C. AND IS NOT TO BE REPRODUCED OR COPIED IN WHOLE OR IN PART. IT IS TO BE USED ONLY FOR THE PROJECT AND SITE SPECIFICALLY IDENTIFIED HEREON AND NOT TO BE USED ON ANY OTHER PROJECT. IT IS TO BE RETURNED UPON REQUEST.

COPYRIGHT © 2018. ALL RIGHTS RESERVED.
STANLEY, LOVE & STANLEY, P.C.
DRAWING NO.

DATE
01/31/2020

PROJECT NO.
6919.5

DRAWING NO.
A1.10

RELEASED FOR CONSTRUCTION 01/31/2020

2/21/2020 9:46:48 AM