
 


DRAWING NOTES

- ① DEMOLISH EXISTING NATURAL GAS UNIT HEATER AND ALL ASSOCIATED DUCTWORK, PIPING, CONTROLS, AND WIRING. SEE PD-101 FOR EXTENT OF DEMOLITION.
- ② DEMOLISH EXISTING EXHAUST FAN AND ALL ASSOCIATED DUCTWORK, CONTROLS, AND WIRING.
- ③ DEMOLISH EXISTING OUTSIDE AIR LOUVER.

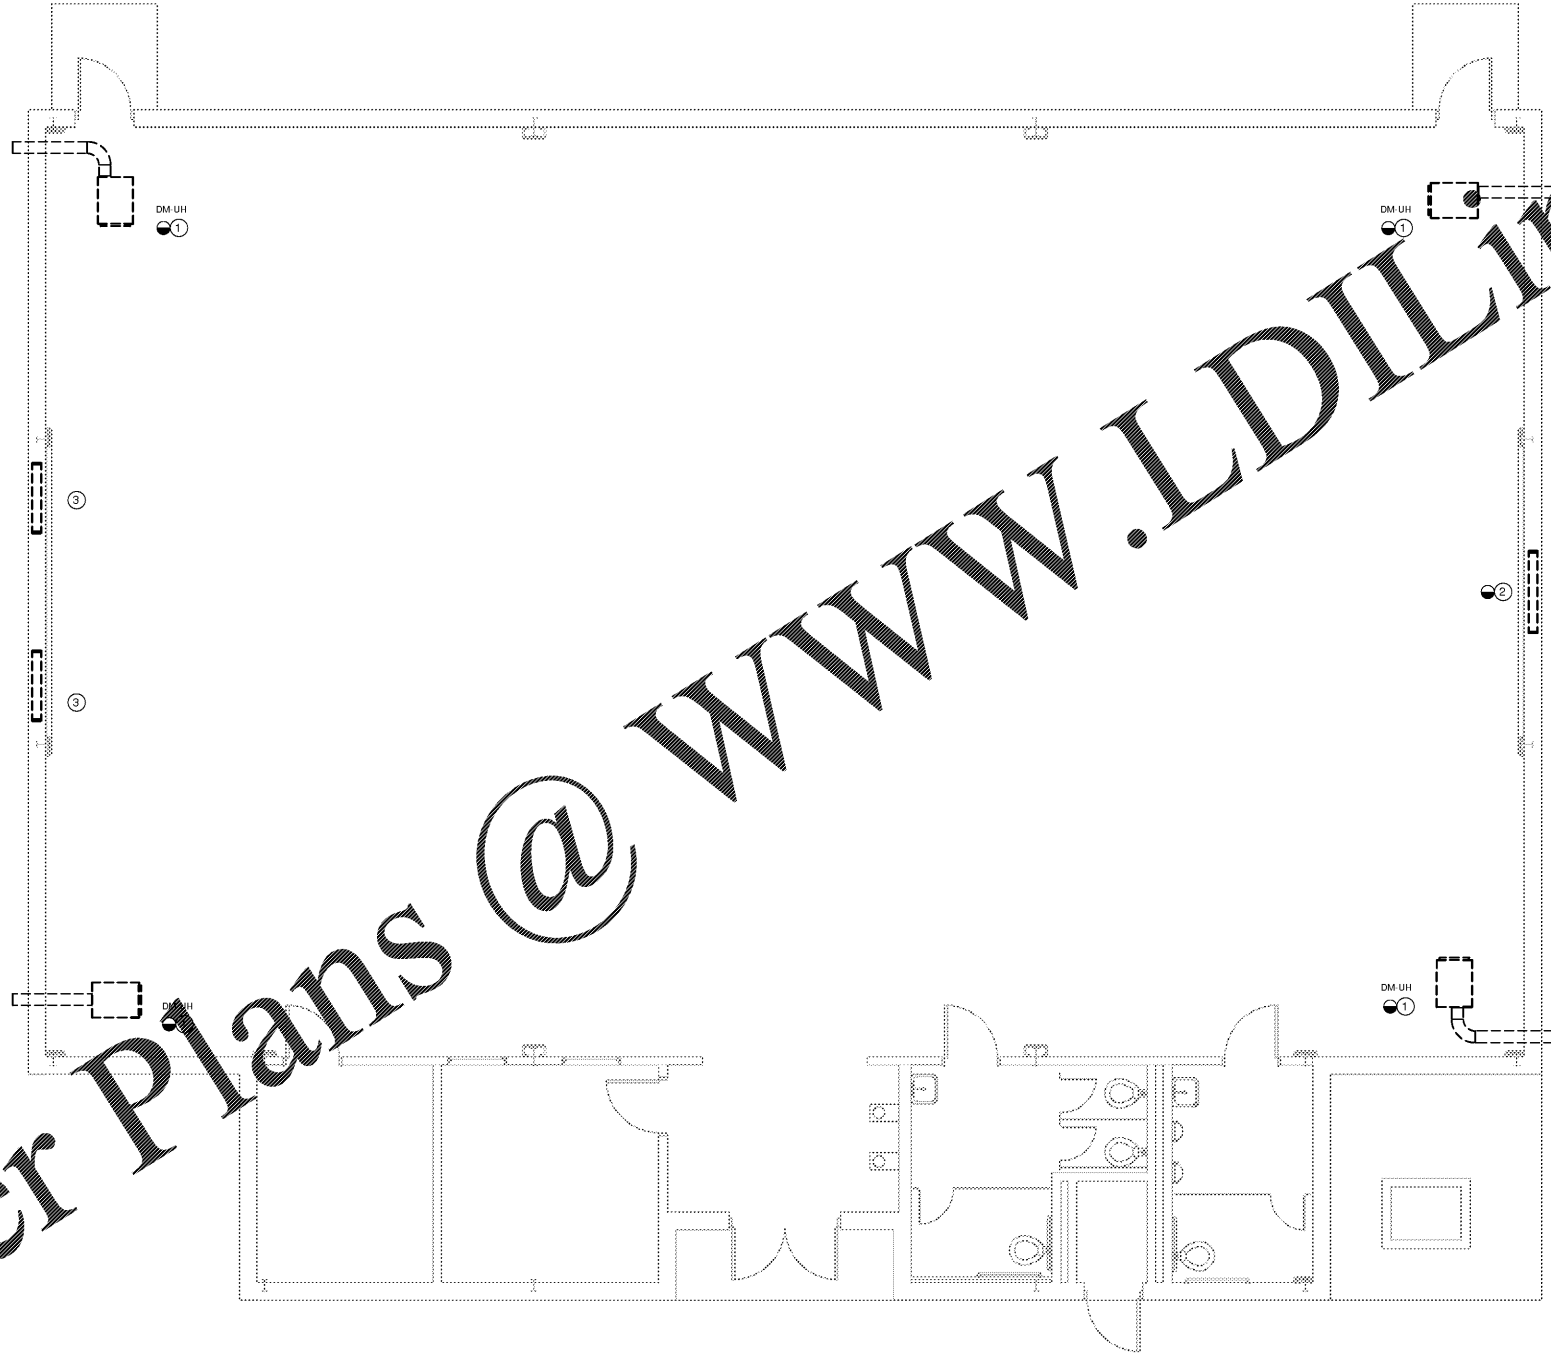

1 LEVEL 1 HVAC DEMOLITION PLAN
SCALE: 1/4" = 1'-0"



Order Plans @ www.LDILine.com

CD	100% CD SET	01/31/2020

SHADOW ROCK ELEMENTARY SCHOOL
GYM HVAC DESIGN
 1040 Kingway Drive
 Lithonia, Georgia 30058

STANLEY LOVE STANLEY P & C
 ARCHITECTURE
 INTERIORS PLANNING
 PROGRAM MANAGEMENT
 1186 SPRING STREET, N.W.
 ATLANTA, GEORGIA 30309-3813
 404.876.0088
 404.876.0087 fax
 www.stanleylove-stanley.com

DRAWING TITLE
 MECHANICAL LEVEL 1
 DUCTWORK PLAN -
 DEMOLITION



CONSULTANT
rmf Engineering
 880 HARRISON DRIVE SUITE 725
 ATLANTA, GA 30328 878.912.0035

SCALES AS STATED HEREON ARE VALID ON THE ORIGINAL DRAWING. THE DIMENSIONS OF ANYTHING SHOWN HEREON SHALL BE THE DIMENSIONS AS SHOWN ON THE ORIGINAL DRAWING. THIS DRAWING IS THE PROPERTY OF STANLEY LOVE STANLEY, P.C. AND IS NOT TO BE REPRODUCED, COPIED, OR IN ANY MANNER BE LOANED, REPRODUCED, HEREIN AND IS NOT TO BE USED ON ANY OTHER PROJECT. IT IS TO BE RETURNED UPON REQUEST.
 COPYRIGHT © 2016. ALL RIGHTS RESERVED BY STANLEY LOVE STANLEY, P.C.

DATE	01/31/2020
PROJECT NO.	6919.5
DRAWING NO.	MD-101

RELEASED FOR CONSTRUCTION 01/31/2020