
 


DRAWING NOTES

- 1 DEMOLISH EXISTING NATURAL GAS UNIT HEATER AND ALL ASSOCIATED DUCTWORK, PIPING, CONTROLS, AND WIRING. SEE MD-101 FOR EXTENT OF DEMOLITION.

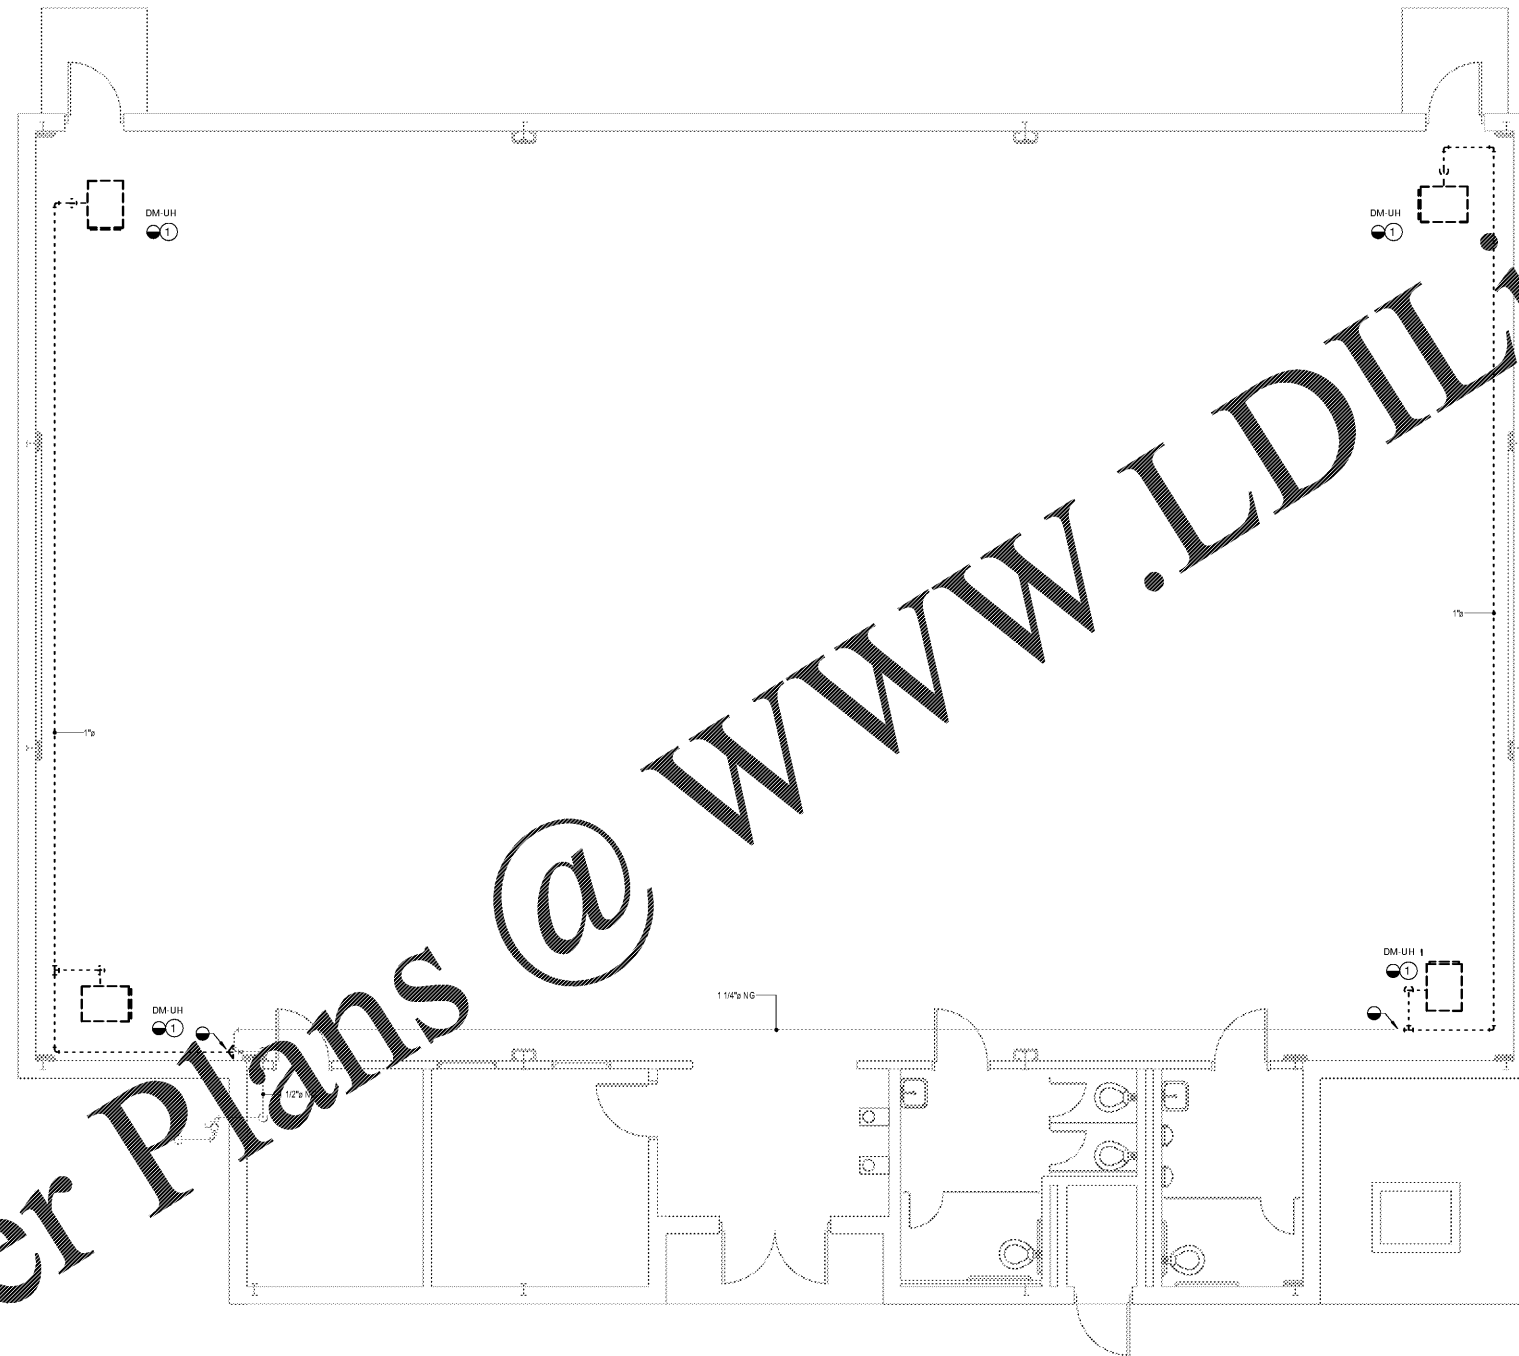

1 LEVEL 1 PLUMBING PLAN - DEMOLITION
SCALE: 1/4" = 1'-0"



**SHADOW ROCK ELEMENTARY SCHOOL
GYM HVAC DESIGN**
1040 Kingway Drive
Lithonia, Georgia 30058



ARCHITECTURE
INTERIORS PLANNING
PROGRAM MANAGEMENT
1186 SPRING STREET, N.W.
ATLANTA, GEORGIA 30309-3818
404.876.0596
www.stanleylove-stanley.com

DRAWING TITLE
PLUMBING LEVEL 1
DEMOLITION



CONSULTANT
rmf Engineering
888 HARRISON DRIVE SUITE 725
ATLANTA, GA 30328 678.913.0228

SCALES AS STATED HEREON ARE VALID ON THE ORIGINAL DRAWING. THE DIMENSIONS OF WHICH ARE SHOWN HEREON. THE SCALE IS NOT TO BE USED FOR ANY OTHER PURPOSE OR FOR ANY OTHER PROJECT. IT IS TO BE RETURNED UPON REQUEST.

THE DRAWING IS THE PROPERTY OF STANLEY LOVE STANLEY P & C AND IS NOT TO BE REPRODUCED OR COPIED IN WHOLE OR IN PART, IF FOUND TO BE LEGAL OR OTHERWISE. IT IS TO BE RETURNED UPON REQUEST.

COPYRIGHT © 2016. ALL RIGHTS RESERVED BY STANLEY LOVE STANLEY P & C.
DRAWING NO.
DATE
01/31/2020
PROJECT NO.
6919.5
DRAWING NO.

PD-101

RELEASED FOR CONSTRUCTION 01/31/2020