



| | |
|------|----|
| DATE | BY |
| | |
| | |
DRAWING NOTES

- ① EXISTING PAD MOUNTED UTILITY TRANSFORMER 500KVA, 277/480V SECONDARY.
- ② EXISTING SERVICE ENTRANCE SWITCHBOARD MSA, UTILITY PROVIDED 12 MONTH PEAK KW - 335KW. TOTAL LOAD REQUIRED = ((335/0.8) kVA x 1.25) + 39.24kVA = 562.6kVA.
- ③ PROVIDE A TAP IN ACCORDANCE WITH NEC 110.12, 110.14, AND 240.21(B) TO MAIN SWITCHBOARD BUSSES TO FEED NEW SAFETY SWITCH, TAP TO COMPLY WITH 10FT RULE. COORDINATE WITH DEKALB COUNTY BEFORE SHUTDOWN OF ELECTRICAL SYSTEM.
- ④ PROVIDE A 100A FUSS WITH A 70A FUSE. LABEL SAFETY SWITCH AS "AHU-1."
- ⑤ LOCATE NEW SAFETY SWITCH ON WALL IN THIS LOCATION IN ACCORDANCE WITH NEC 110.26 WITHIN 10FT OF MAIN SWITCHBOARD.
- ⑥ CONDUCTOR LENGTH NOT TO EXCEED 10FT.

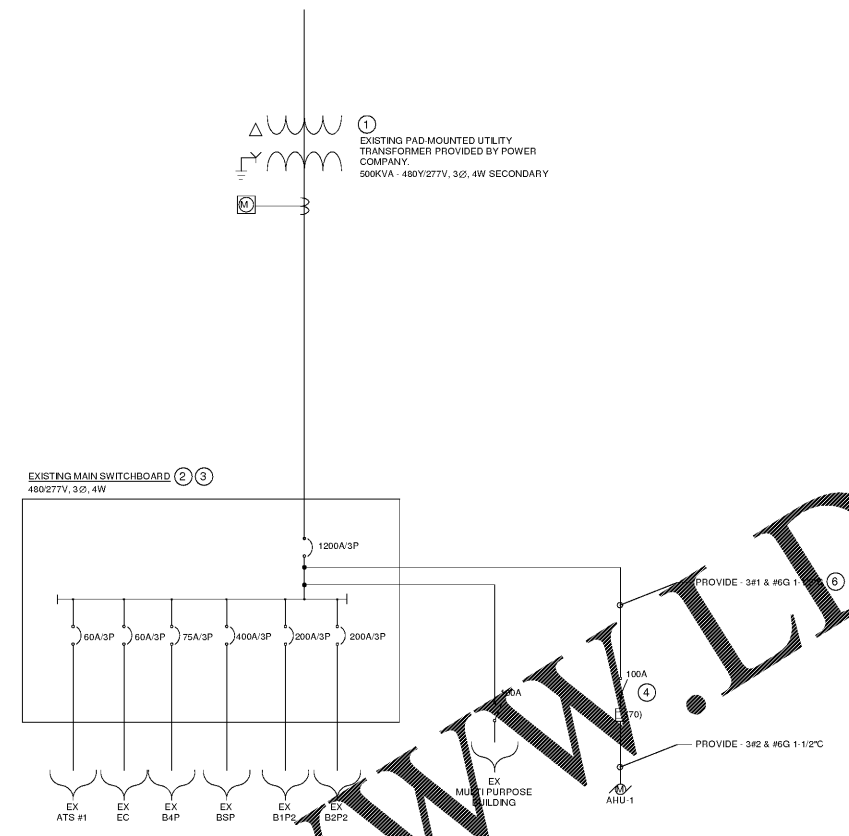

① **DETAIL ONE-LINE DIAGRAM**
SCALE: N.T.S.

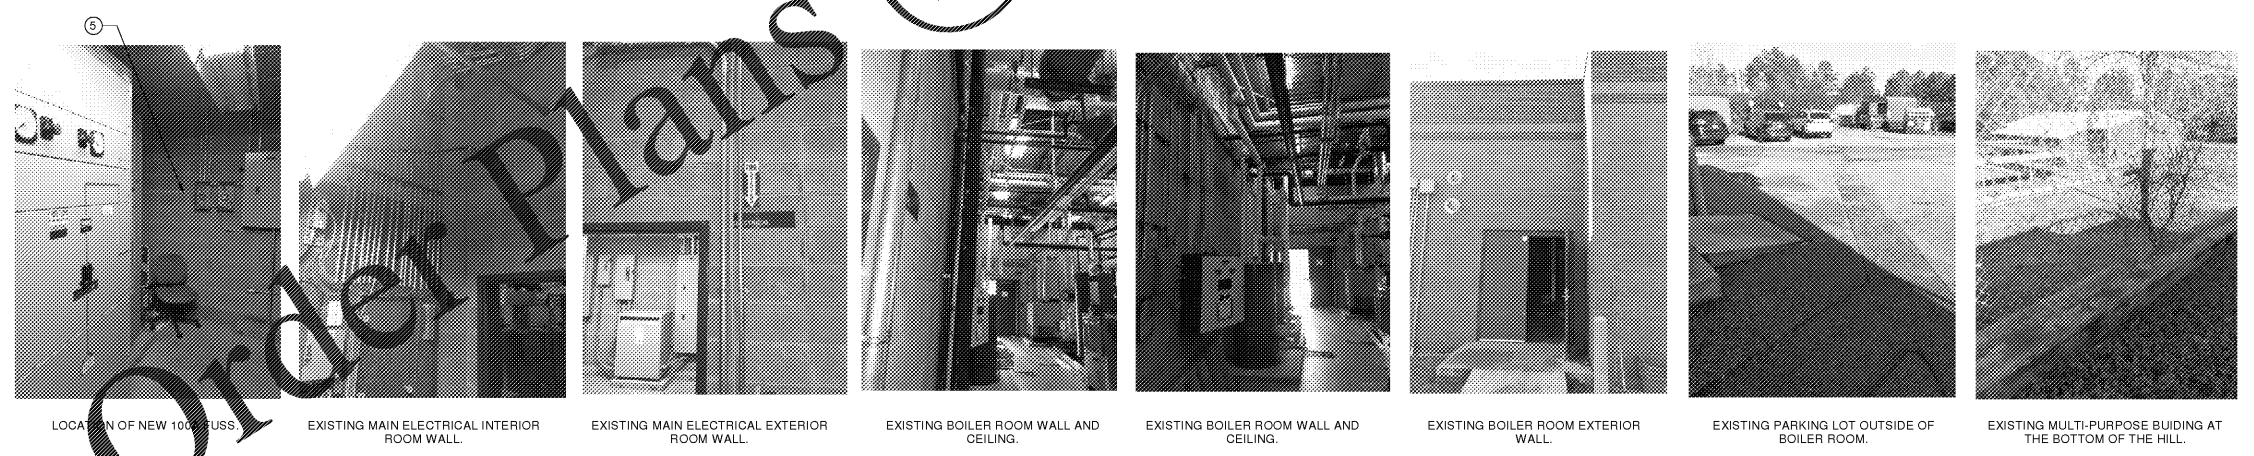

② **SITE SURVEY PHOTOS**
SCALE: N.T.S.

Order Plans

WWW.LDILine.com

**SHADOW ROCK ELEMENTARY SCHOOL
GYM HVAC DESIGN**
1040 Kingway Drive
Lithonia, Georgia 30058

**STANLEY
LOVE
STANLEY
P R C**
ARCHITECTURE
INTERIORS PLANNING
PROGRAM MANAGEMENT
1196 SPRING STREET, N.W.
ATLANTA, GEORGIA 30309-2819
404.476.0556
404.476.0567 Fax
www.stanleylove-stanleyprc.com

DRAWING TITLE:
**ELECTRICAL ONE-LINE
DIAGRAM**



rmf Engineering
1810 HARRISON DRIVE, SUITE 175
ATLANTA, GA 30329 678.919.0229

SCALES AS STATED HEREON ARE VALID ON THE ORIGINAL DRAWING. THE DIMENSIONS OF ANYTHING SHOWN HEREON SHALL BE THE DIMENSIONS SHOWN ON THE DRAWING. IF ANY DIMENSIONS ARE SHOWN ON THE DRAWING, THEY SHALL TAKE PRECEDENCE OVER ANY DIMENSIONS SHOWN ON THE ORIGINAL DRAWING.

THIS DRAWING IS THE PROPERTY OF STANLEY LOVE STANLEY P R C AND IS NOT TO BE REPRODUCED OR COPIED IN WHOLE OR IN PART, IF ANY PART IS REPRODUCED OR COPIED HEREON AND IS NOT TO BE USED ON ANY OTHER PROJECT. IT IS TO BE RETURNED UPON REQUEST.

COPYRIGHT © 2016. ALL RIGHTS RESERVED BY STANLEY LOVE STANLEY P R C.

DRAWING NO.
DATE
01/31/2020
PROJECT NO.
6919.5
DRAWING NO.

E-501

RELEASED FOR CONSTRUCTION 01/31/2020