


Keynote Legend	
Key Value	Keynote Text
6	AIR HANDLING UNIT. SEE MECHANICAL DRAWINGS.
7	CONCRETE PAD. SEE CIVIL AND MECHANICAL DRAWINGS.
8	CHAIN LINK FENCE. SEE CIVIL DRAWINGS.
17	NEW EXTERIOR SUPPLY AIR DUCTWORK AND SUPPORT AS SHOWN ON DETAILS 7, 9 AND 10 ON MECHANICAL DRAWINGS M-401.

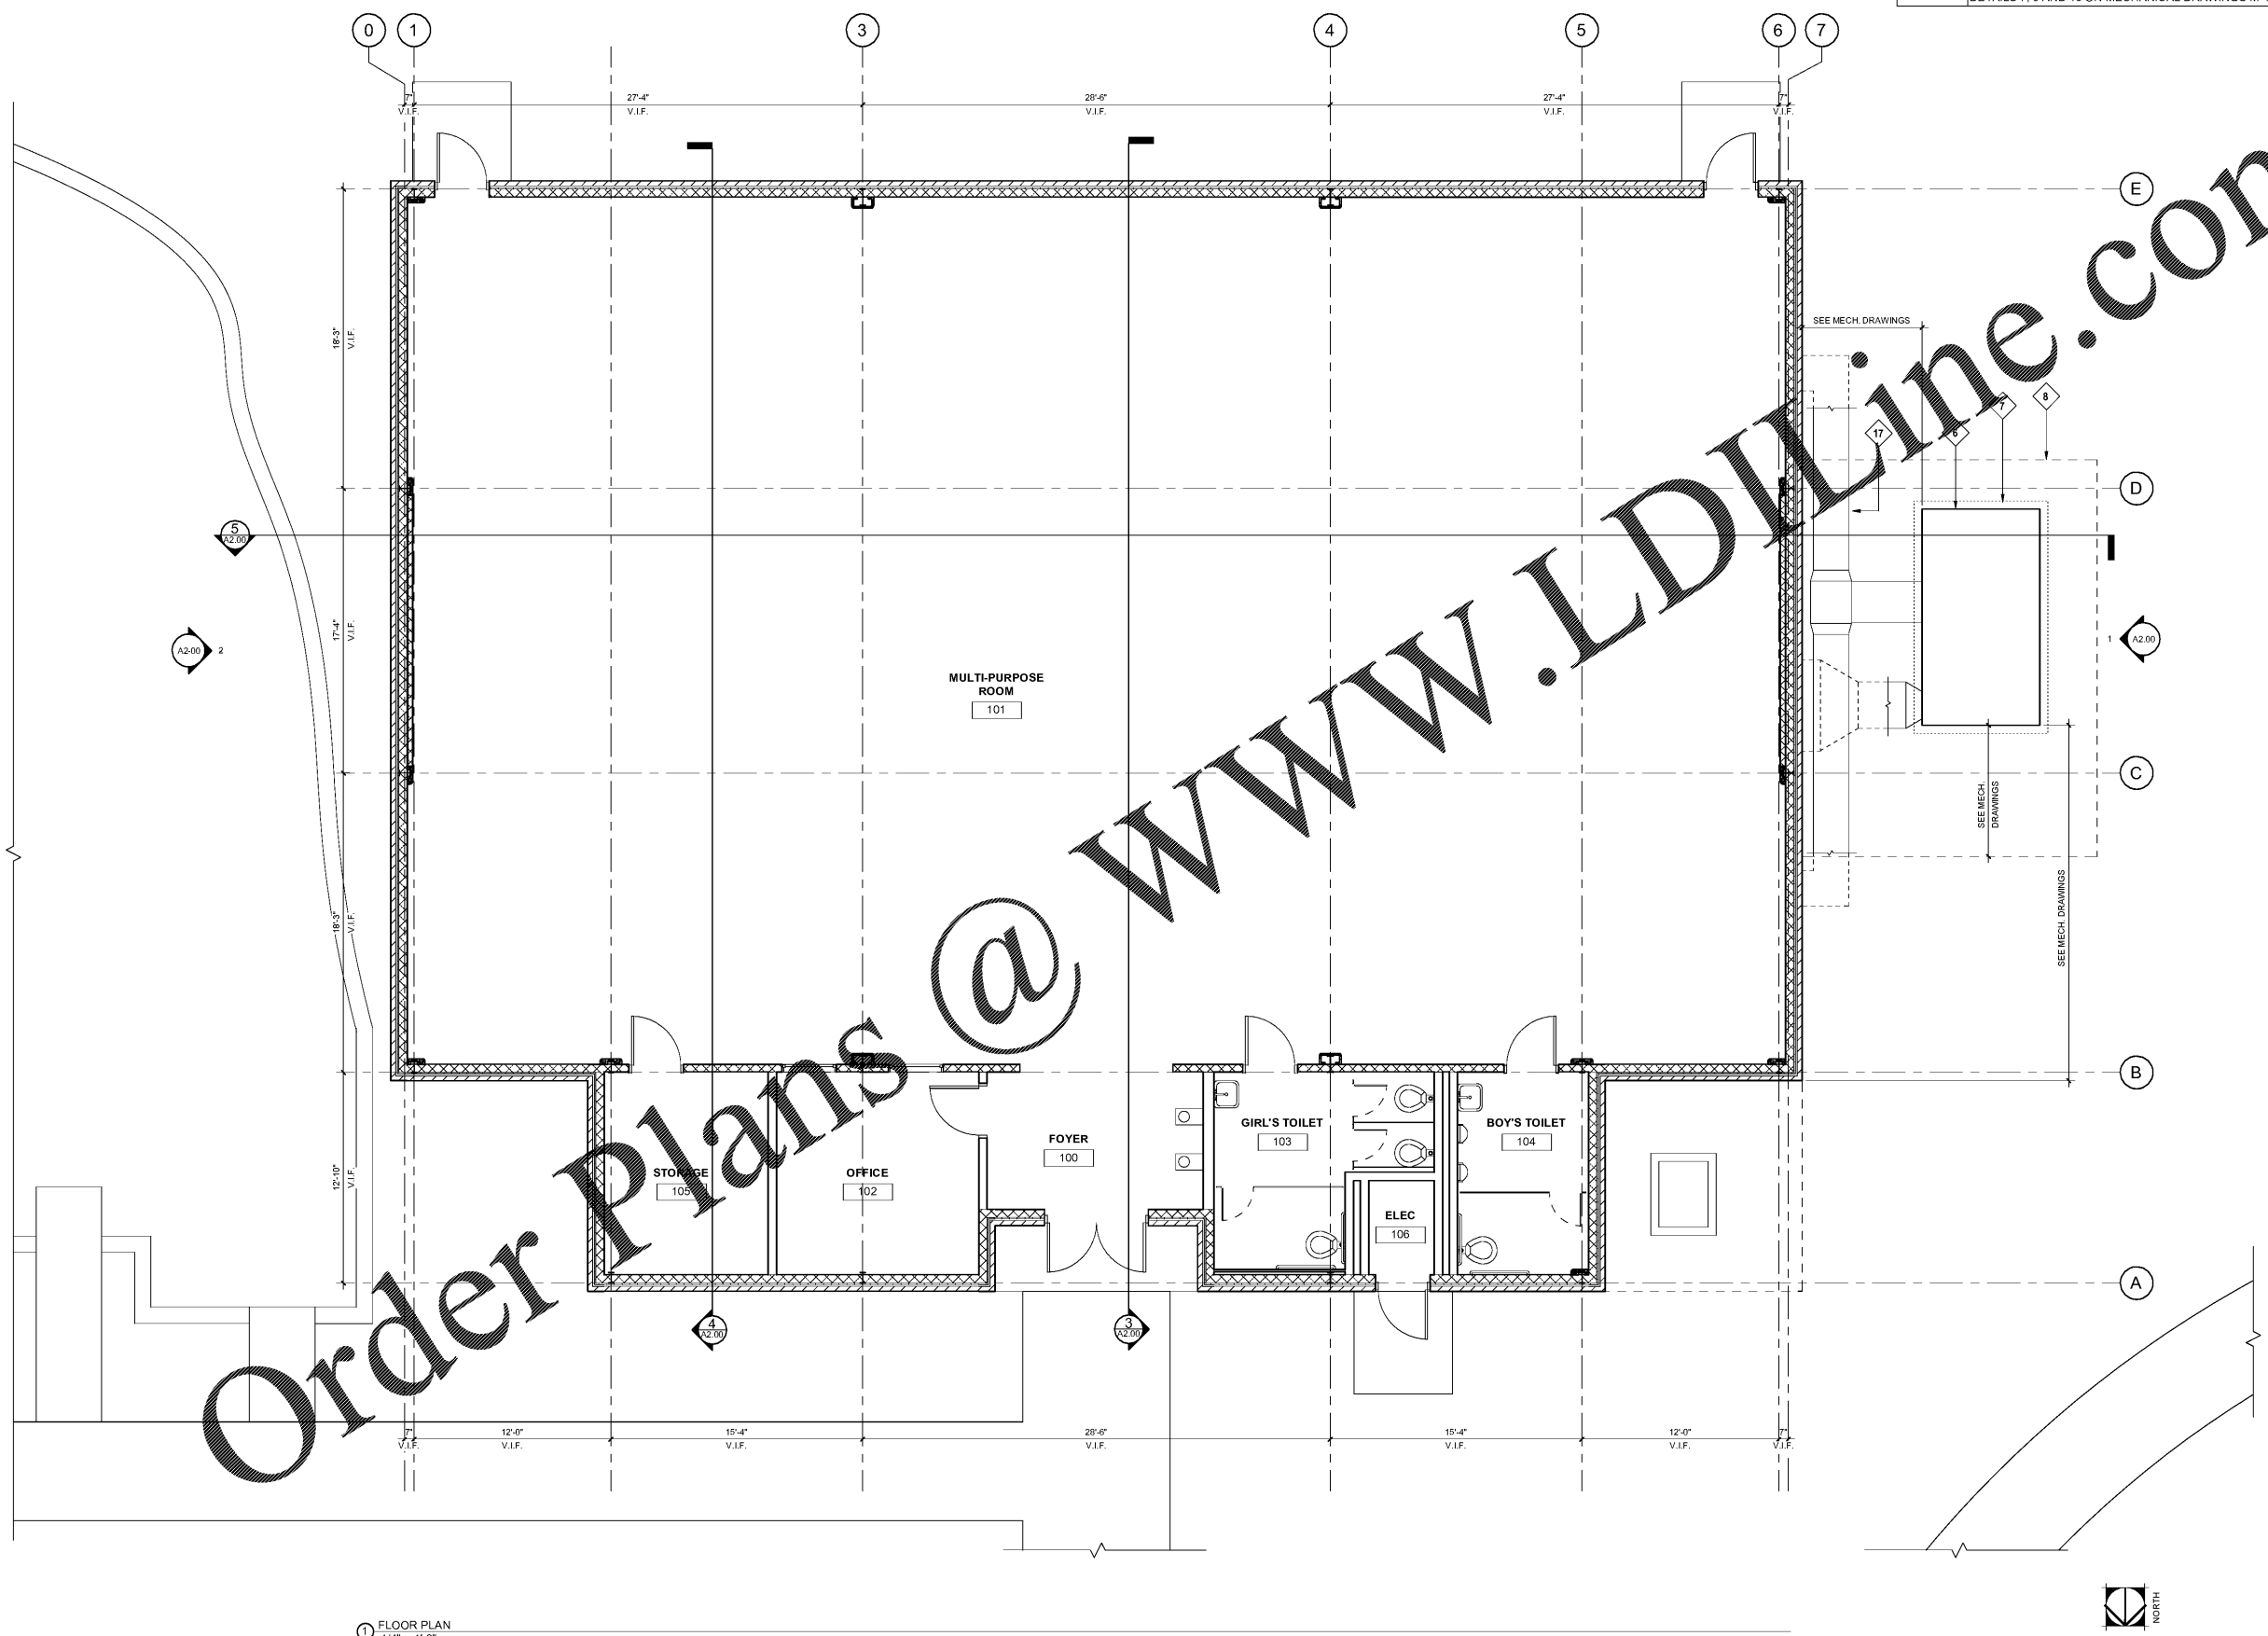

www.LDILine.com

Order Plans @

1 FLOOR PLAN
1/4" = 1'-0"

**VANDERLYN ELEMENTARY SCHOOL
GYM HVAC DESIGN**
1877 Vanderlyn Drive
Dunwoody, Georgia 30338

**STANLEY
LOVE
STANLEY
P A C**

ARCHITECTURE
INTERIORS PLANNING
PROGRAM MANAGEMENT

1586 SPRING STREET, N.W.
ATLANTA, GEORGIA 30309
404-275-0208
www.stanleylove.com

DRAWING TITLE
FLOOR PLAN



CONSULTANT

SCALES AS STATED HEREON ARE VALID ON THE ORIGINAL DRAWING. THE DIMENSION OF WHICH ARE SHOWN ON THE SCALE. NOTED HEREON ARE HEREBY CHANGE BY THE PART OF THE OVERALL SHEET DIMENSIONS OF THE PRINT TO CORRESPONDING DIMENSIONS OF THE ORIGINAL DRAWING.

THE DRAWING IS THE PROPERTY OF STANLEY LOVE STANLEY P.C. AND IS NOT TO BE REPRODUCED OR COPIED IN WHOLE OR IN PART. IT IS ON IT TO BE USED FOR THE PROJECT AND SITE SPECIFICALLY IDENTIFIED HEREON AND NOT TO BE USED ON ANY OTHER PROJECT. IT IS TO BE RETURNED UPON REQUEST.

COPYRIGHT © 2018. ALL RIGHTS RESERVED
STANLEY LOVE STANLEY P.C.
DRAWING NO.

DATE
01/06/2020

PROJECT NO.
6919.8

DRAWING NO.

A1.00

1/24/2020 3:44:29 PM

RELEASED FOR CONSTRUCTION 01/06/2020