


Keynote Legend	
Key Value	Keynote Text
2	FABRIC DUCT, COORDINATE SIZE, LOCATION AND ATTACHMENT WITH MECHANICAL DRAWINGS.
3	NEW RETURN AIR LOUVER, COORDINATE SIZE AND LOCATION WITH MECHANICAL DRAWINGS.
17	NEW EXTERIOR SUPPLY AIR DUCTWORK AND SUPPORT AS SHOWN ON DETAILS 7, 9 AND 10 ON MECHANICAL DRAWINGS M-401.
NOTE: REFER TO A 2.00 AND A3.00 FOR LOCATIONS AND EXTENT OF NEW METAL WALL PANEL(S) AND LINER PANEL(S).	

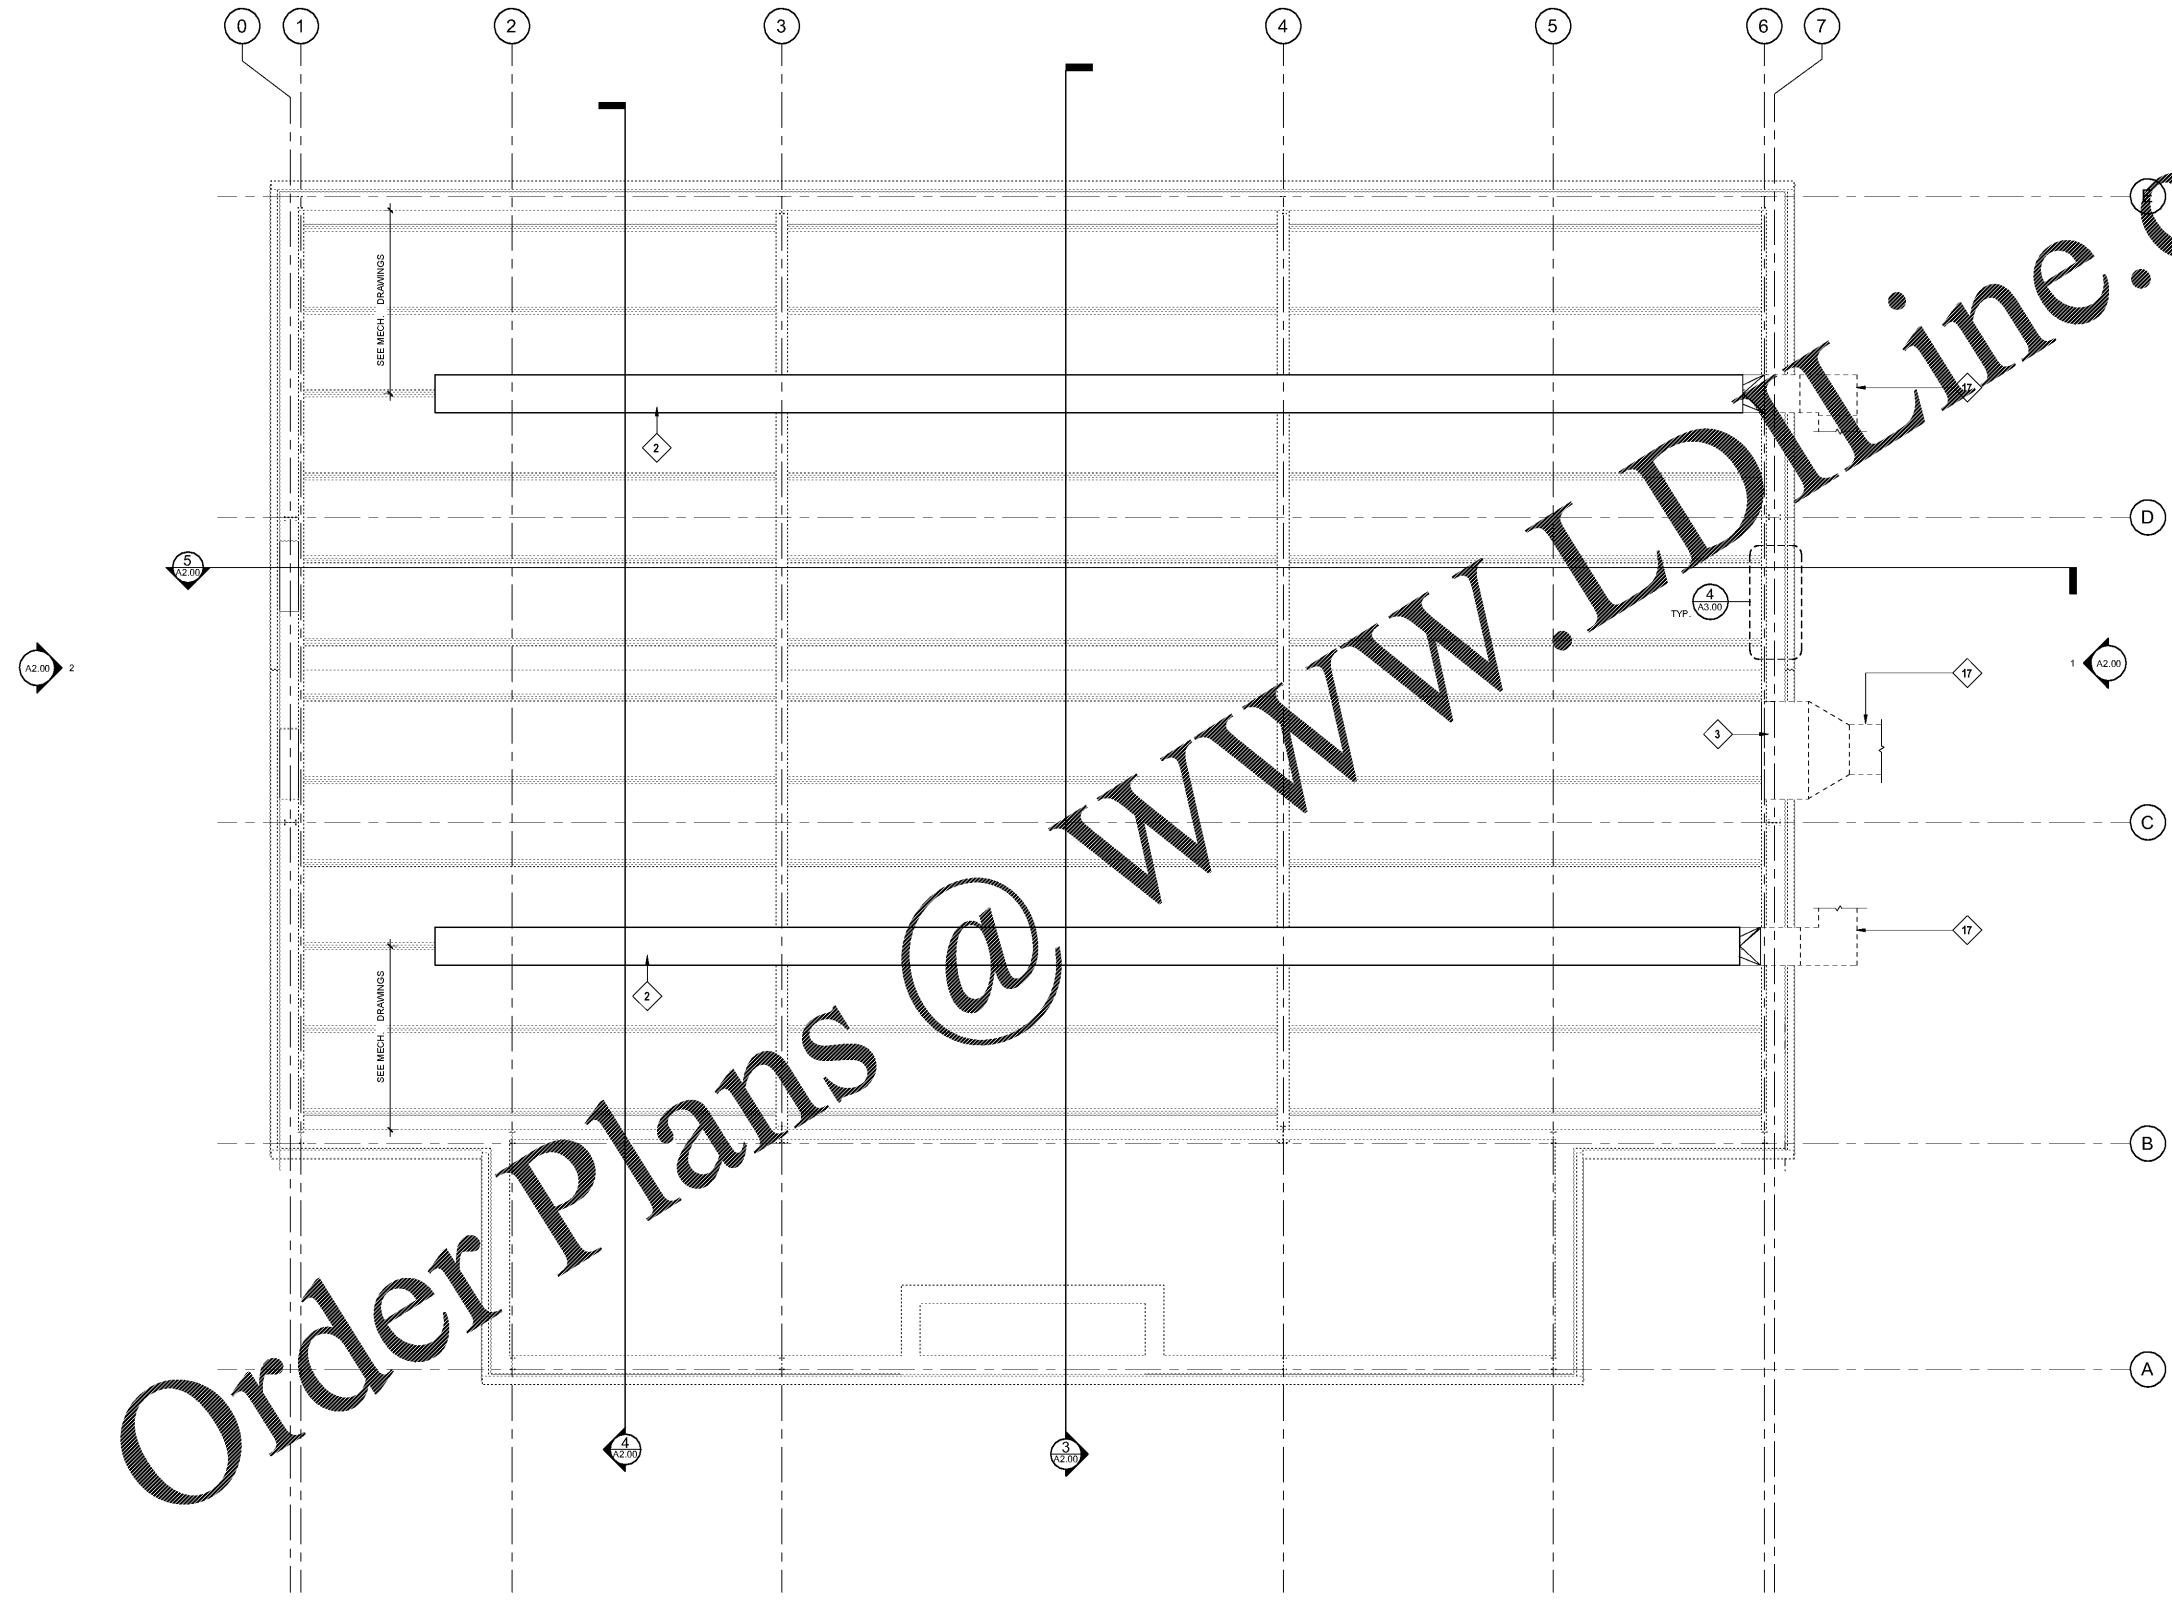

Order Plans @

1 REFLECTED CEILING PLAN
1/4" = 1'-0"



VANDERLYN ELEMENTARY SCHOOL
GYM HVAC DESIGN
1877 Vanderlyn Drive
Dunwoody, Georgia 30338

STANLEY
LOVE
STANLEY
P A C
ARCHITECTURE
INTERIORS PLANNING
PROGRAM MANAGEMENT
1586 SPRING STREET, N.W.
ATLANTA, GEORGIA 30309
404-875-0508
www.stanleylove.com

DRAWING TITLE
REFLECTED CEILING
PLAN



CONSULTANT

SCALES AS STATED HEREON ARE VALID ON THE ORIGINAL DRAWING. THE DIMENSION OF WHICH ARE SHOWN ON THE SCALE. NOTED HEREON ARE HEREBY CHANGE BY THE RATIO OF THE OVERALL SHEET DIMENSIONS OF THE PRINT TO CORRESPONDING DIMENSIONS OF THE ORIGINAL DRAWING.

THE DRAWING IS THE PROPERTY OF STANLEY LOVE STANLEY P.C. AND IS NOT TO BE REPRODUCED OR COPIED IN WHOLE OR IN PART. IT IS ON LY TO BE USED FOR THE PROJECT AND SITE SPECIFICALLY IDENTIFIED HEREON AND NOT TO BE USED ON ANY OTHER PROJECT. IT IS TO BE RETURNED UPON REQUEST.

COPYRIGHT © 2018. ALL RIGHTS RESERVED
STANLEY LOVE STANLEY P.C.
DRAWING NO.

DATE
01/06/2020
PROJECT NO.
6919.8
DRAWING NO.
A1.10