


DRAWING NOTES

 
1. REFER TO ARCHITECTURAL PLANS FOR INFORMATION ON FENCE AROUND AHU-1.
2. CONTRACTOR TO PROVIDE STRUCTURAL SUPPORT TO EXTERIOR DUCTWORK AS NECESSARY. REFER TO SPECIFICATIONS FOR INFORMATION ON EXTERIOR DUCTWORK AND REQUIREMENTS.

DRAWING NOTES

- 1 NEW ROUND DUCT TO BE FABRIC DUCT WITH INTERNAL SUPPORT. SEE M-401 FOR FABRIC DUCT DETAILS.
- 2 ADD ALTERNATE: PROVIDE NEW DOOR LOUVER AND INSTALL IN RESTROOM DOORS. SEE SCHEDULE FOR LOUVER DIMENSIONS AND LOCATION.

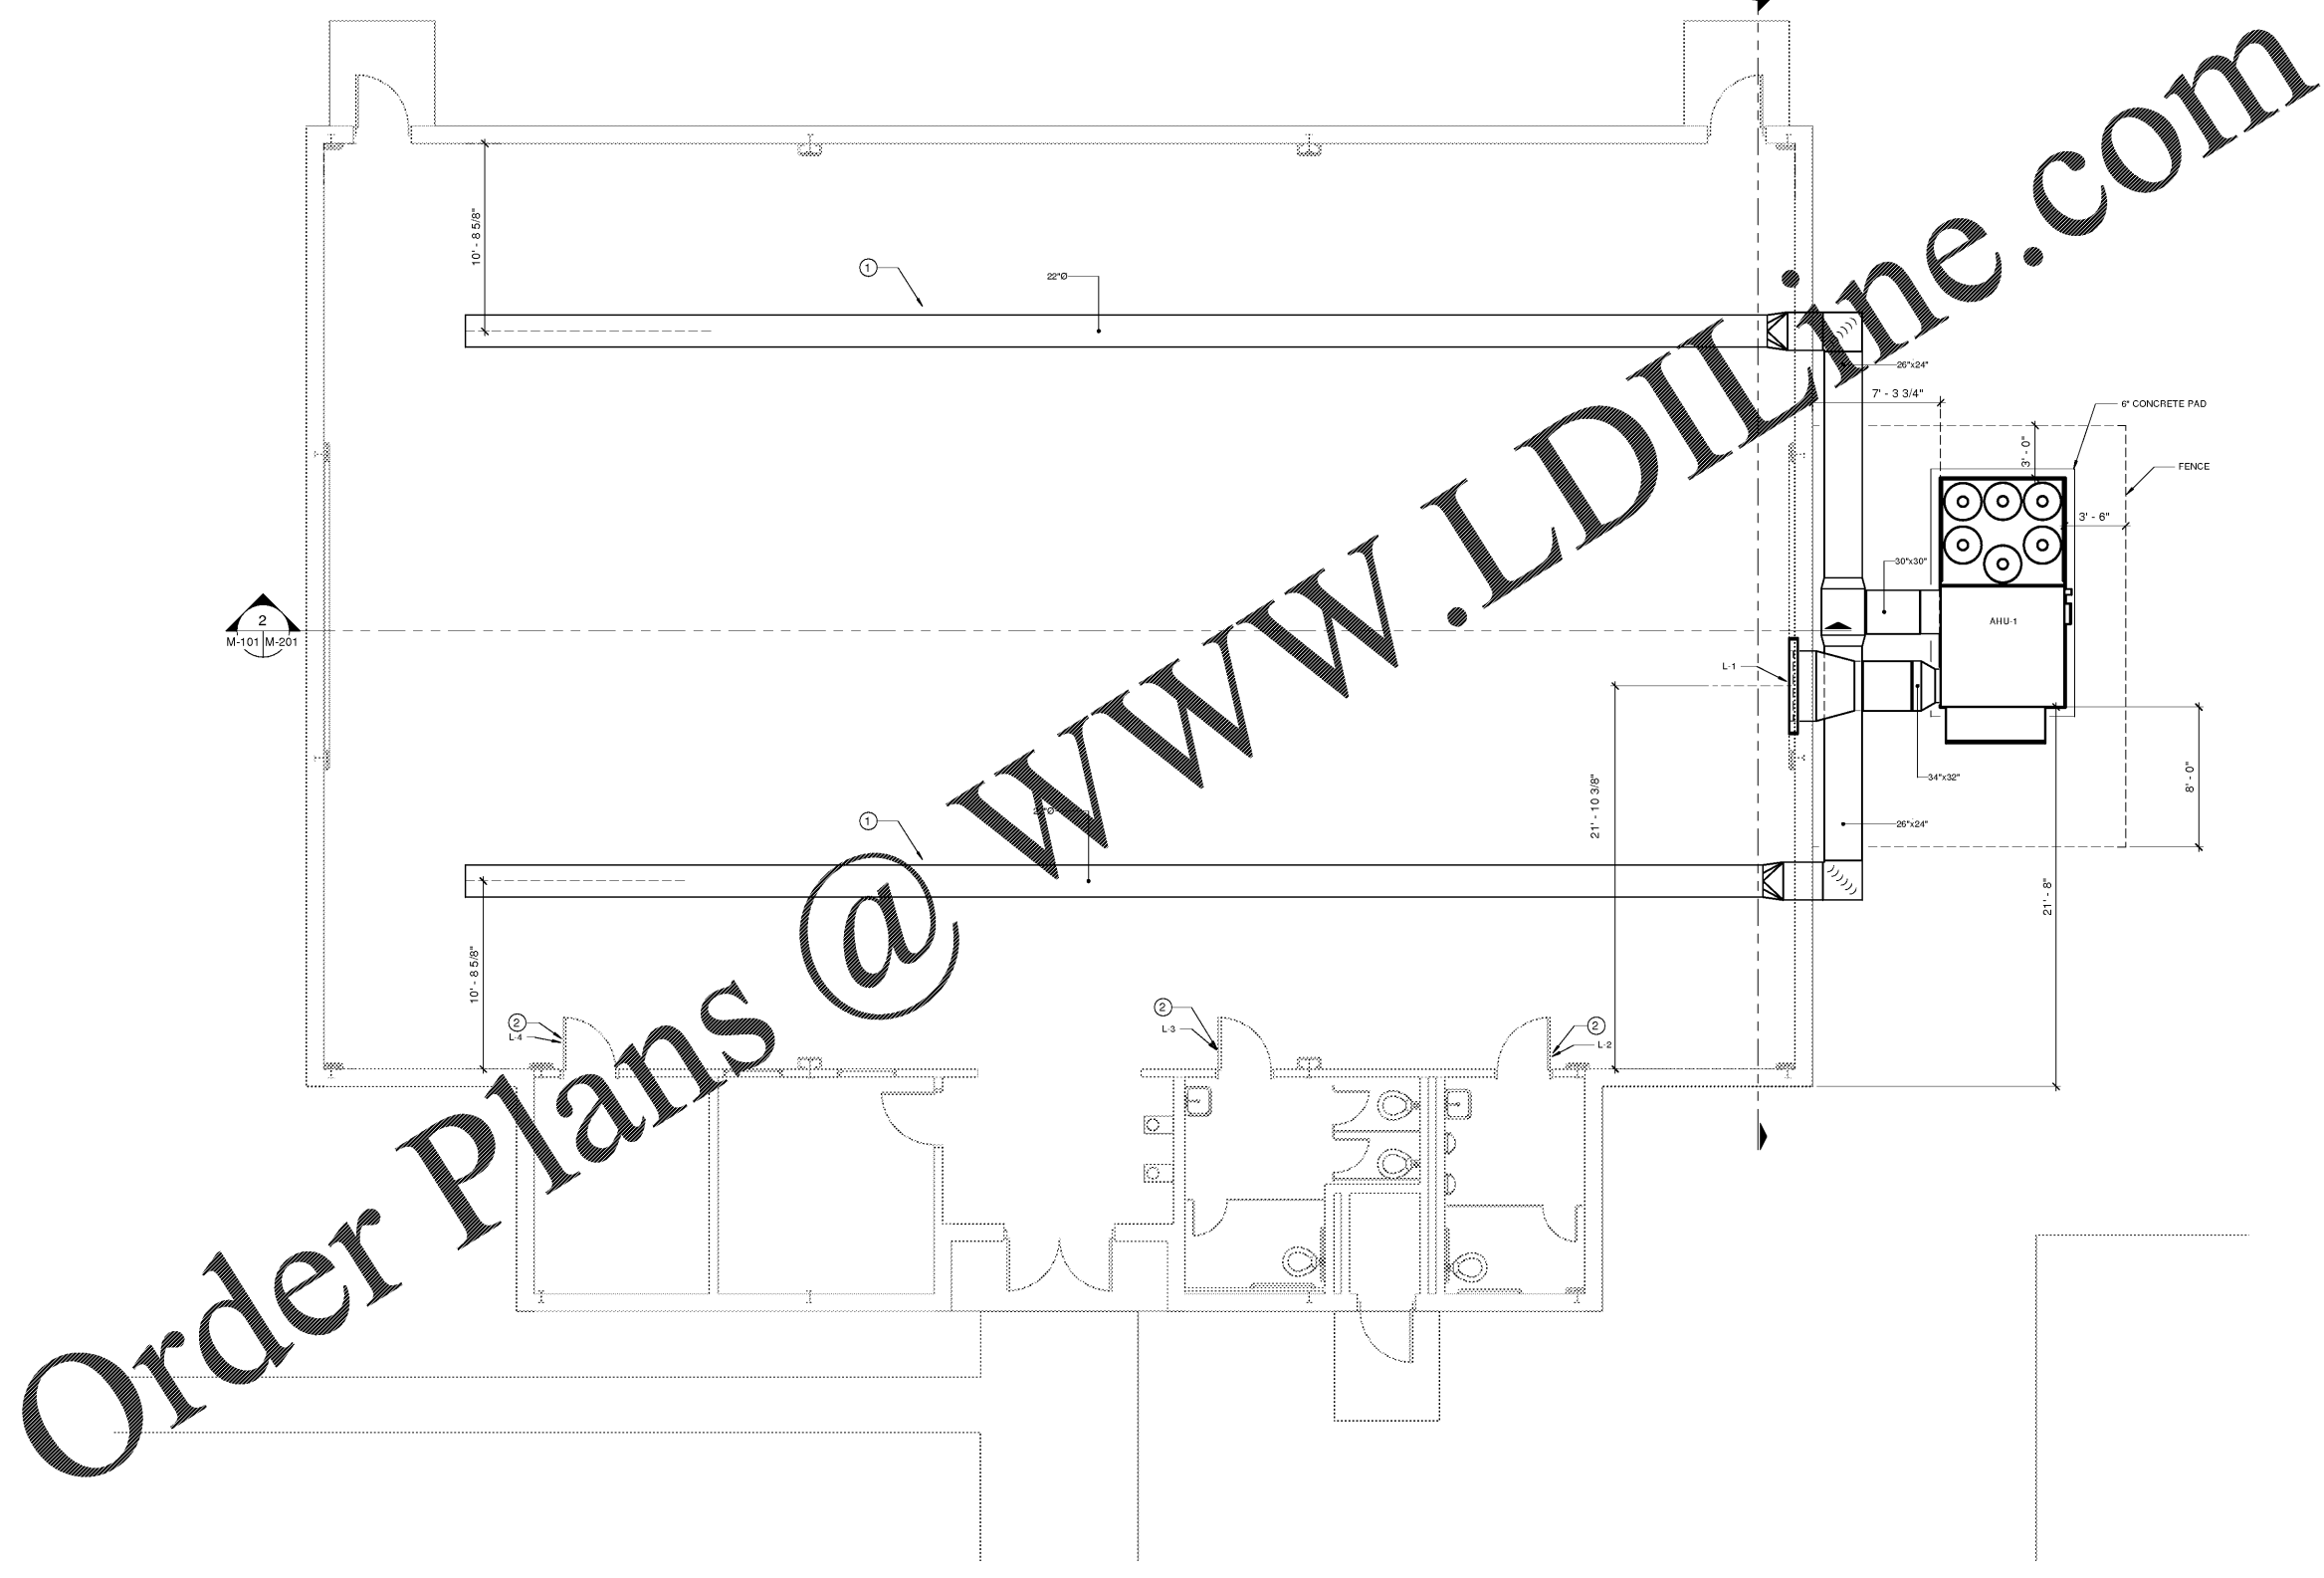

LEVEL 1 HVAC DUCTWORK PLAN
SCALE: 1/4" = 1'-0"



Order Plans @ www.LDILine.com

**VANDERLYN ELEMENTARY SCHOOL
GYM HVAC DESIGN**
1877 Vanderlyn Drive
Dunwoody, Georgia 30338

**STANLEY
LOVE
STANLEY
P A C**
ARCHITECTURE
INTERIORS PLANNING
PROGRAM MANAGEMENT
1186 SPRING STREET, N.W.
ATLANTA, GEORGIA 30309-3818
404.476.0596
www.stanleylove.com

DRAWING TITLE
**MECHANICAL LEVEL 1
DUCTWORK PLAN**



CONSULTANT

SCALES AS STATED HEREON ARE VALID ON THE ORIGINAL DRAWING. THE DIMENSIONS OF WHICH ARE SHOWN HEREON. THE SCALE IS NOT TO BE USED AS A BASIS FOR CHANGE OF THE RATIO OF THE OVERALL SHEET DIMENSIONS OF THE PRINT TO CORRESPONDING DIMENSIONS OF THE ORIGINAL DRAWING.
THIS DRAWING IS THE PROPERTY OF STANLEY LOVE STANLEY P.A.C. AND IS NOT TO BE REPRODUCED BY ANY MEANS, IN ANY FORM, WITHOUT THE WRITTEN PERMISSION OF STANLEY LOVE STANLEY P.A.C. IF ANY PART OF THIS DRAWING IS REPRODUCED OR TRANSMITTED IN ANY FORM OR BY ANY MEANS, WITHOUT THE WRITTEN PERMISSION OF STANLEY LOVE STANLEY P.A.C., THE USER HEREBY AGREES TO INDEMNIFY AND HOLD STANLEY LOVE STANLEY P.A.C. HARMLESS FROM AND AGAINST ALL CLAIMS, DAMAGES, LOSSES AND EXPENSES, INCLUDING REASONABLE ATTORNEY'S FEES, THAT MAY BE ASSERTED AGAINST STANLEY LOVE STANLEY P.A.C. BY ANY THIRD PARTY AS A RESULT OF SUCH REPRODUCTION OR TRANSMISSION.
COPYRIGHT © 2016. ALL RIGHTS RESERVED BY STANLEY LOVE STANLEY P.A.C.

DRAWING NO.
DATE
01/06/2020
PROJECT NO.
6919.8
DRAWING NO.

M-101

RELEASED FOR CONSTRUCTION 01/06/2020