

01	100% CD SET	01/31/2020

**WADSWORTH MAGNET SCHOOL  
GYM HVAC DESIGN**  
3039 Santa Monica Drive  
Decatur, Georgia 30032

**STANLEY  
LOVE  
STANLEY  
P R C**

ARCHITECTURE  
INTERIORS PLANNING  
PROGRAM MANAGEMENT

1386 SPRING STREET, N.W.  
ATLANTA, GEORGIA 30309  
404-875-0508  
www.stanleylove.com

DRAWING TITLE  
**EXTERIOR  
ELEVATIONS &  
BUILDING SECTIONS -  
DEMOLITION**



CONSULTANT

SCALES AS STATED HEREON ARE VALID ON THE ORIGINAL DRAWING. THE DIMENSIONS OF WHICH ARE SHOWN ON THE SCALE. NOTED HEREON ARE HEREBY CHANGE BY THE RATIO OF THE OVERALL SHEET DIMENSIONS OF THE PRINT TO CORRESPONDING DIMENSIONS OF THE ORIGINAL DRAWING.

THIS DRAWING IS THE PROPERTY OF STANLEY LOVE STANLEY P.C. AND IS NOT TO BE REPRODUCED OR COPIED IN WHOLE OR IN PART. IT IS NOT TO BE USED FOR ANY PROJECT AND SITE SPECIFICALLY IDENTIFIED HEREON AND IS NOT TO BE USED ON ANY OTHER PROJECT. IT IS TO BE RETURNED UPON REQUEST.


COPYRIGHT © 2018. ALL RIGHTS RESERVED.  
STANLEY LOVE STANLEY P.C.  
DRAWING NO.

DATE  
01/31/2020


PROJECT NO.  
6919.6

DRAWING NO.


**AD2.00**

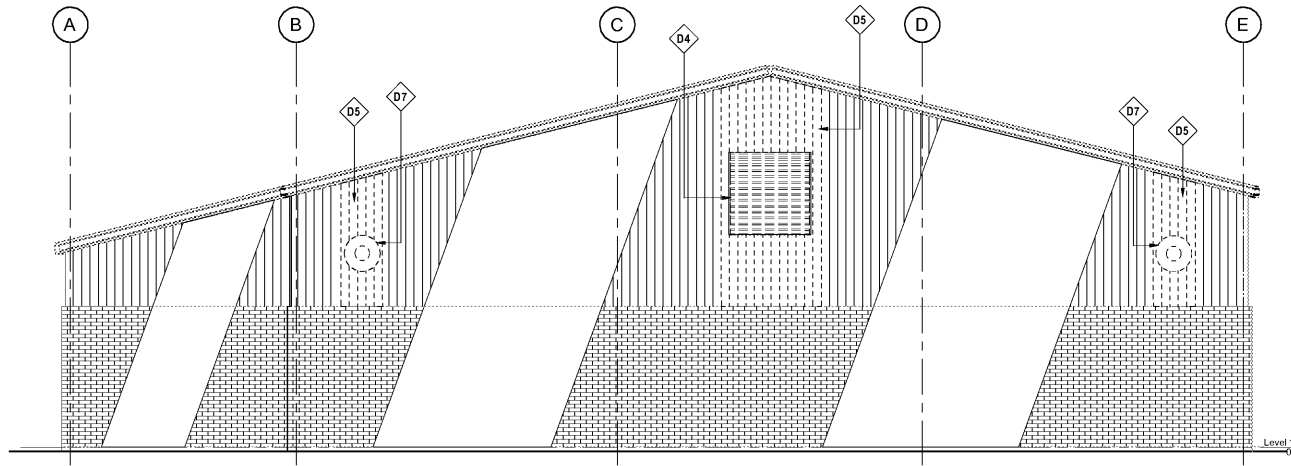


1 DEMOLITION NORTH ELEVATION  
1/4" = 1'-0"

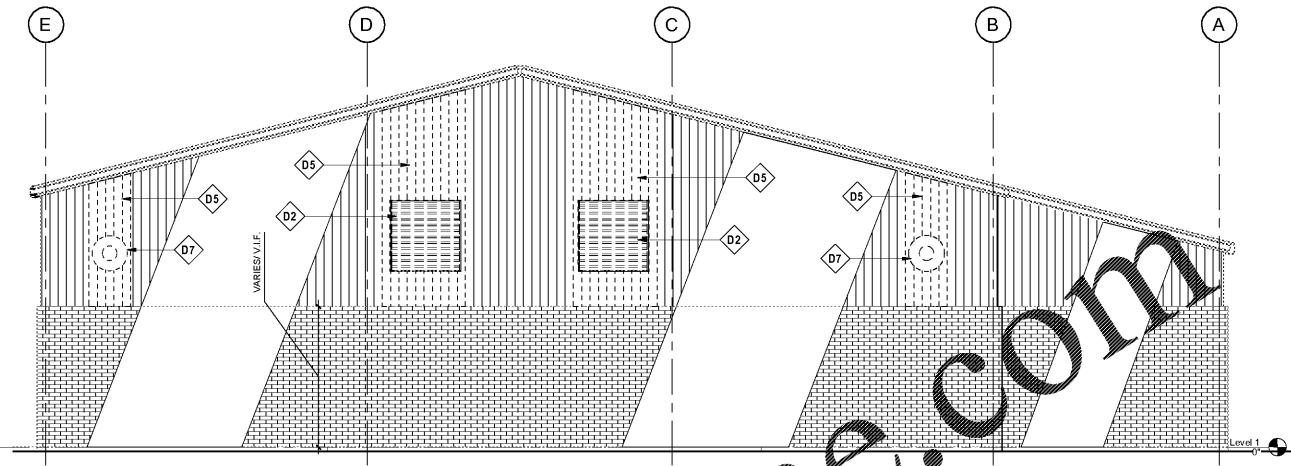

2 DEMOLITION SOUTH ELEVATION  
1/4" = 1'-0"

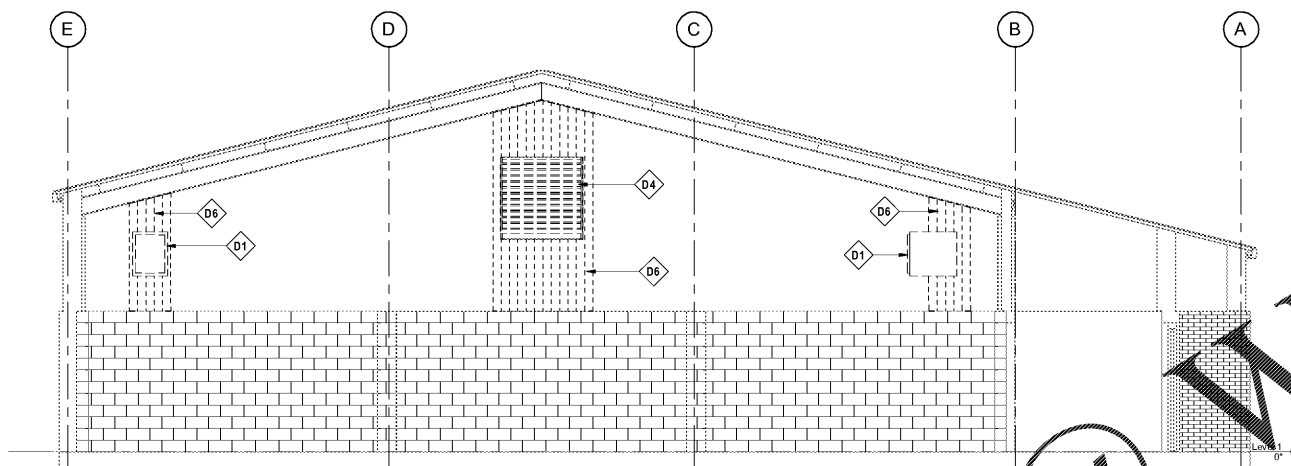

3 DEMOLITION SECTION  
1/4" = 1'-0"

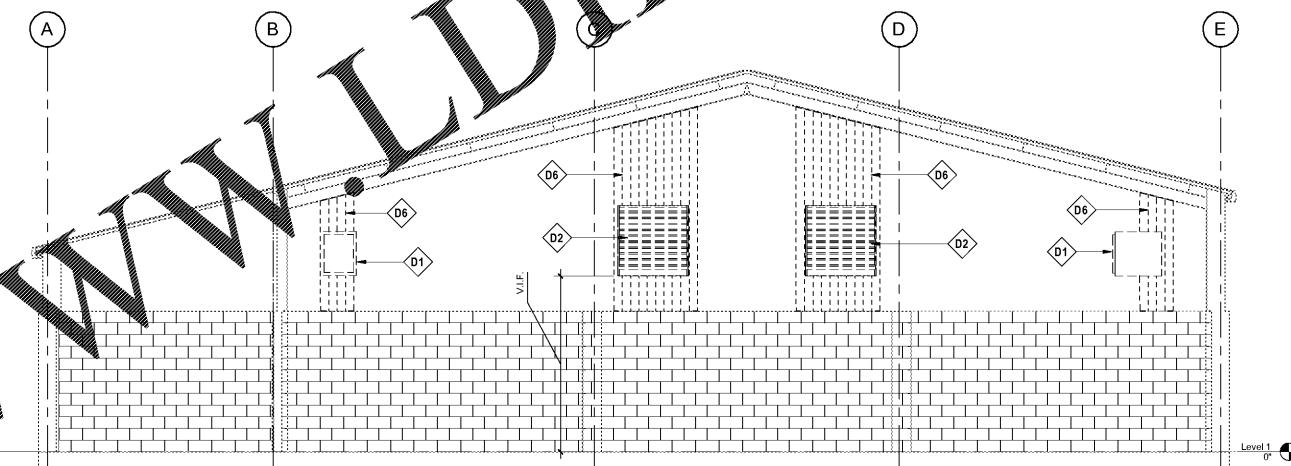

4 DEMOLITION SECTION  
1/4" = 1'-0"

Order Plans @ [www.LDILine.com](http://www.LDILine.com)

Keynote Legend	
Key Value	Keynote Text
D1	REMOVE EXISTING GAS-FIRED UNIT HEATERS. SEE MECHANICAL DRAWINGS.
D2	REMOVE EXISTING INTAKE LOUVER SYSTEM TO EXTENT INDICATED. SEE MECHANICAL DRAWINGS.
D4	REMOVE EXISTING WALL-MOUNTED EXHAUST FAN SYSTEM TO EXTENT INDICATED. SEE MECHANICAL DRAWINGS.
D5	REMOVE FULL METAL WALL PANEL(S) IN THIS AREA, AS REQUIRED, FOR INSTALLATION OF NEW EXTERIOR METAL WALL PANEL(S).
D6	REMOVE FULL LINER WALL PANEL(S) IN THIS AREA, AS REQUIRED, FOR INSTALLATION OF NEW METAL LINER PANEL(S).
D7	REMOVE GAS HEATER VENT PIPING THROUGH WALL. FIELD VERIFY LOCATION. SEE PLUMBING DRAWINGS.