

100% CD SET	01/31/2020
-------------	------------

**WADSWORTH MAGNET SCHOOL
GYM HVAC DESIGN**
3039 Santa Monica Drive
Decatur, Georgia 30032

**STANLEY
LOVE
STANLEY
P R C**

ARCHITECTURE
INTERIORS PLANNING
PROGRAM MANAGEMENT

1086 SPRING STREET, N.W.
ATLANTA, GEORGIA 30309-3818
404-875-0088
404-875-0887
www.stanleylove.com

DRAWING TITLE
WALL SECTION & DETAILS



CONSULTANT

SCALES AS SHOWN ARE VALID ON THE ORIGINAL DRAWING. THE DIMENSIONS OF WHICH ARE SHOWN ON THE SCALE. NOTED HEREIN ARE HEREBY CHANGE BY THE DATE OF THE OVERALL SHEET DIMENSIONS OF THE PRINT TO CORRESPONDING DIMENSIONS OF THE ORIGINAL DRAWING.

THE DRAWING IS THE PROPERTY OF STANLEY, LOVE & STANLEY, P.C. AND IS NOT TO BE REPRODUCED OR COPIED IN WHOLE OR IN PART. IT IS ON IT TO BE USED FOR THE PROJECT AND SITE SPECIFICALLY IDENTIFIED HEREIN AND IS NOT TO BE USED ON ANY OTHER PROJECT. IT IS TO BE RETURNED UPON REQUEST.


COPYRIGHT © 2018. ALL RIGHTS RESERVED.
STANLEY, LOVE & STANLEY, P.C.
DRAWING NO.

DATE
01/31/2020


PROJECT NO.
6919.6

DRAWING NO.
A3.00


RELEASED FOR CONSTRUCTION 01/31/2020

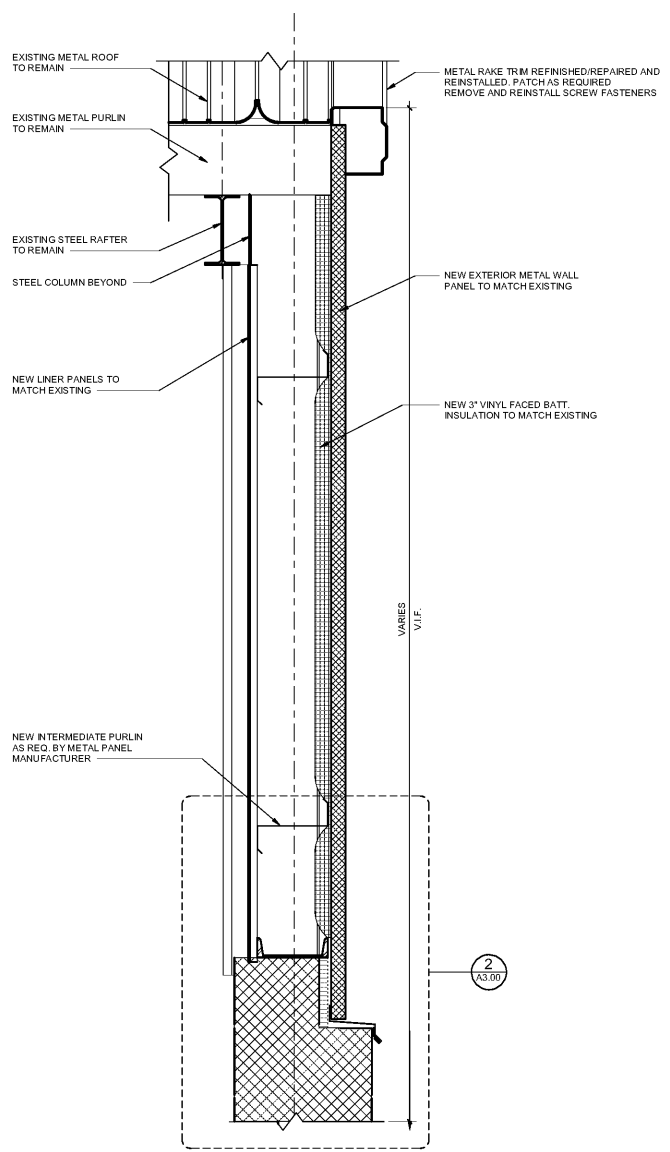


1 NEW METAL PANEL INFILL - TYP.
1 1/2" = 1'-0"

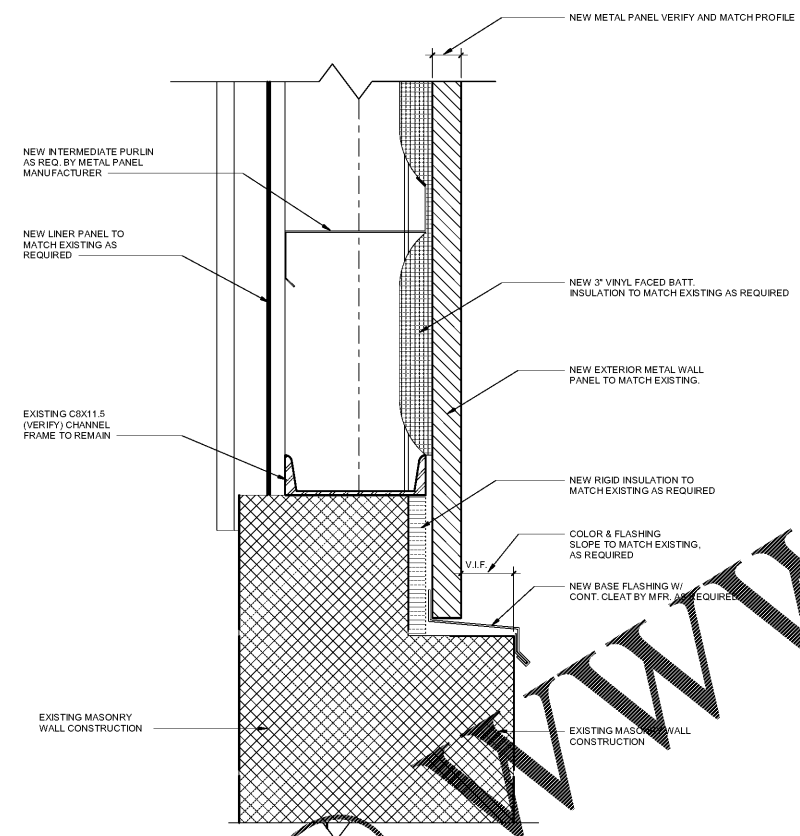

2 NEW METAL PANEL - BASE DETAIL
3" = 1'-0"

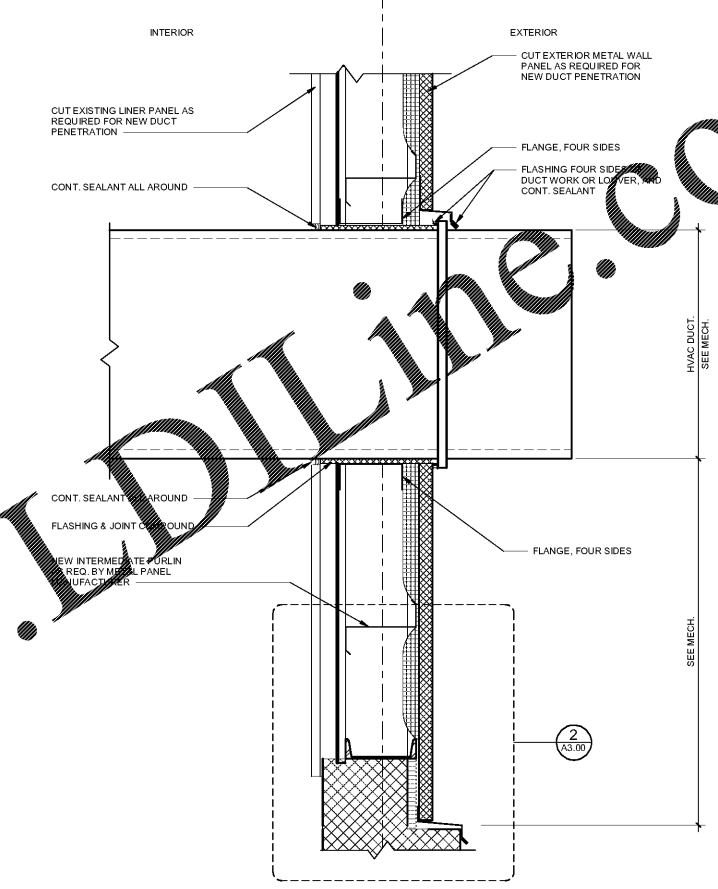

3 PARTIAL SECTION @ DUCT PENETRATION
1 1/2" = 1'-0"

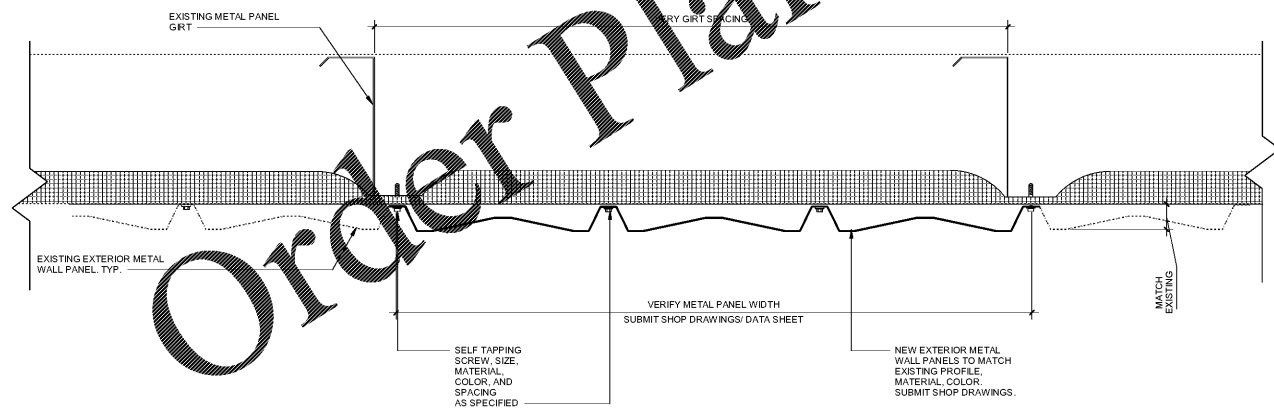

4 EXTERIOR METAL PANEL VERTICAL JOINT DETAIL
3" = 1'-0"

Order Plans @ WWW.IDIline.com

1/31/2020 5:13:51 PM