


DRAWING NOTES

 
① DEMOLISH EXISTING NATURAL GAS UNIT HEATER AND ALL ASSOCIATED DUCTWORK, PIPING, CONTROLS, AND WIRING. SEE MD-101 FOR EXTENT OF DEMOLITION.



Order Plans @ www.LDILine.com

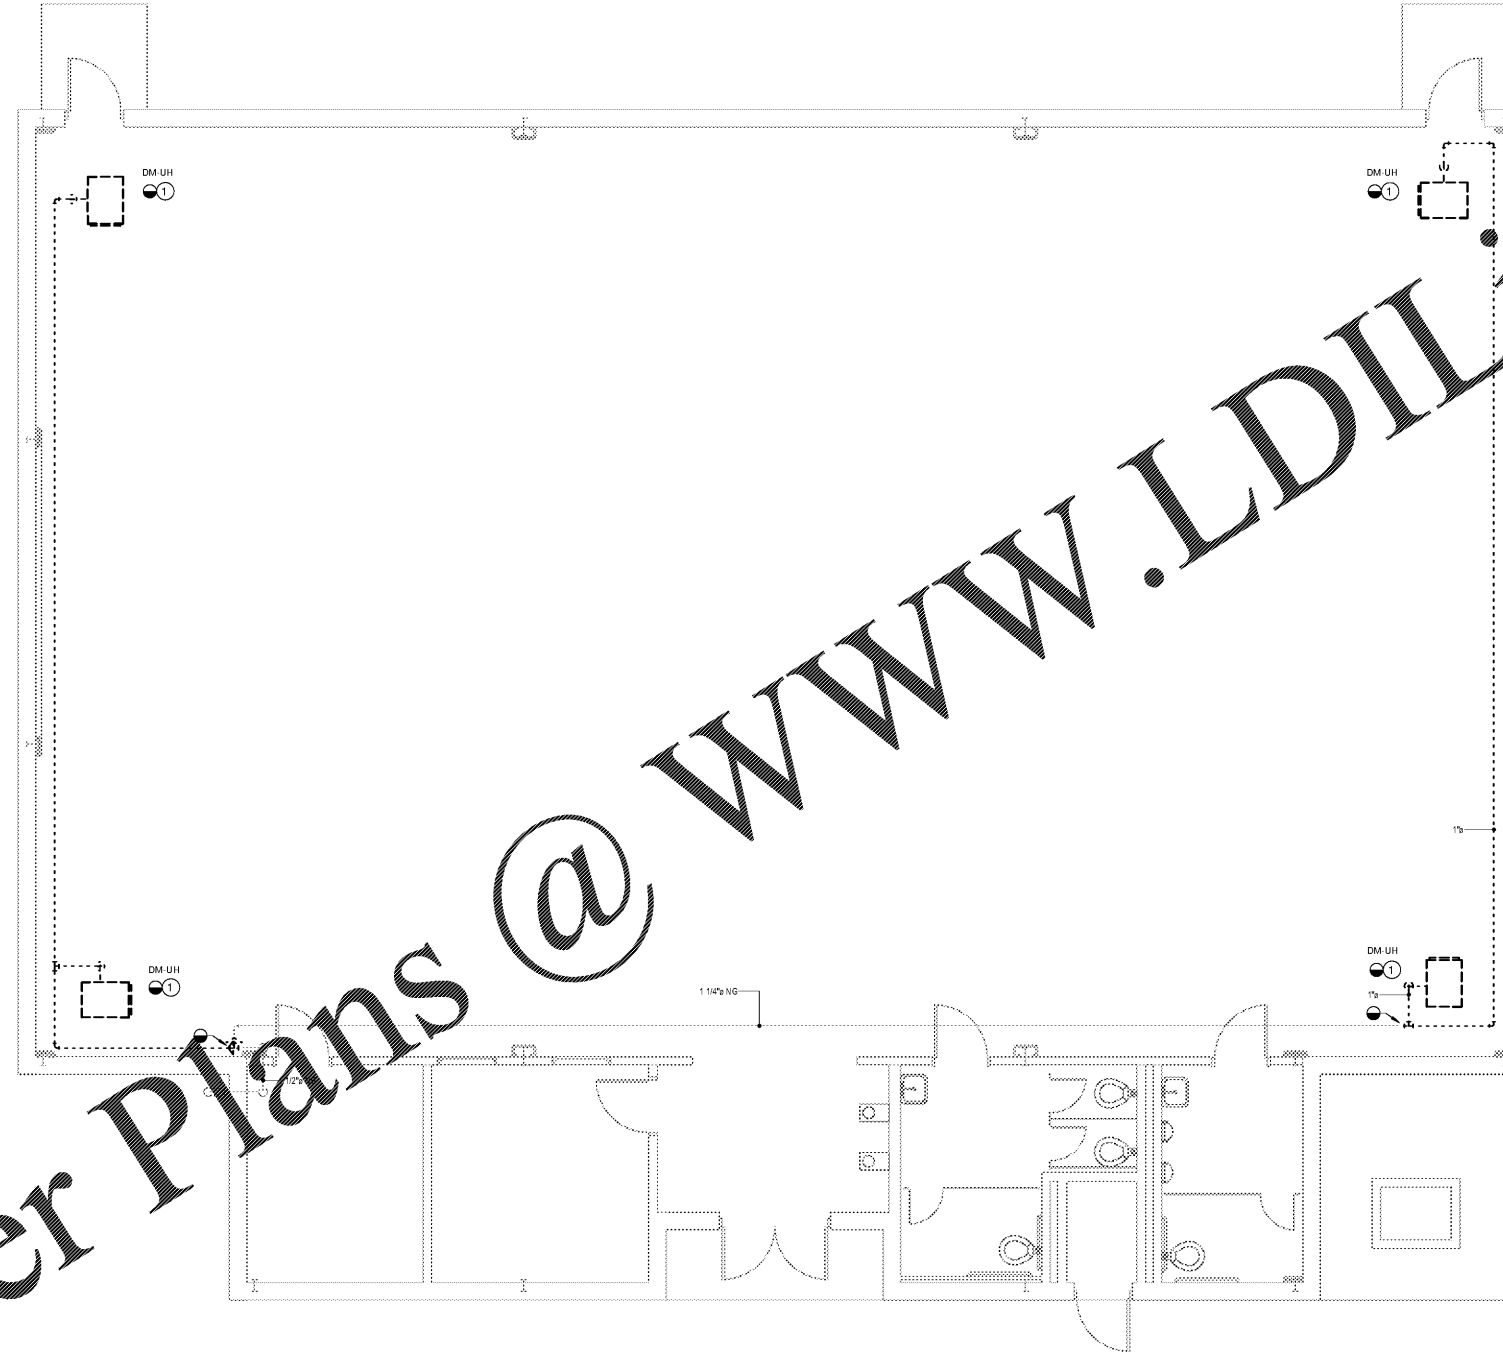

LEVEL 1 PLUMBING PLAN - DEMOLITION
SCALE: 1/4" = 1'-0"



100% CD SET	01/31/2020

**WADSWORTH MAGNET SCHOOL
GYM HVAC DESIGN**
3039 Santa Monica Drive
Decatur, Georgia 30032



ARCHITECTURE
INTERIORS PLANNING
PROGRAM MANAGEMENT
1186 SPRING STREET, N.W.
ATLANTA, GEORGIA 30309-3819
404.876.0258
www.stanleylove-stanleypc.com

DRAWING TITLE
**PLUMBING LEVEL 1
DEMOLITION**



rnf Engineering
189 HARRISON DRIVE SUITE 725
ATLANTA, GA 30329 878.812.0228

SCALES AS STATED HEREON ARE VALID ON THE ORIGINAL DRAWING. THE DIMENSIONS OF WHICH ARE SHOWN HEREON. THE SCALES DO NOT REPRESENT A MATHEMATIC CHANGE OF THE RATIO OF THE OVERALL SHEET DIMENSIONS OF THE PRINT TO CORRESPONDING DIMENSIONS OF THE ORIGINAL DRAWING.

THIS DRAWING IS THE PROPERTY OF STANLEY LOVE- STANLEY P.C. AND IS NOT TO BE REPRODUCED OR COPIED IN WHOLE OR IN PART. IT IS TO BE USED ONLY FOR THE PROJECT AND SITE SPECIFIC IDENTIFIED HEREIN AND IS NOT TO BE USED ON ANY OTHER PROJECT. IT IS TO BE RETURNED UPON REQUEST.

COPYRIGHT © 2016. ALL RIGHTS RESERVED BY STANLEY LOVE- STANLEY P.C.

DRAWING NO.
DATE: 01/31/2020
PROJECT NO: 6919.6
DRAWING NO.

PD-101

RELEASED FOR CONSTRUCTION 01/31/2020