


GENERAL NOTES

1. TOTAL DEVELOPED LENGTH OF NATURAL GAS PIPING IS 250 FEET. ACCOUNTING FOR FITTINGS. NATURAL GAS PIPING IS SIZED FOR PRESSURE OF 14" W.C. WITH A PRESSURE DROP OF 0.3" W.C.


DRAWING NOTES

1 SET PRESSURE REGULATOR TO 14" W.C.

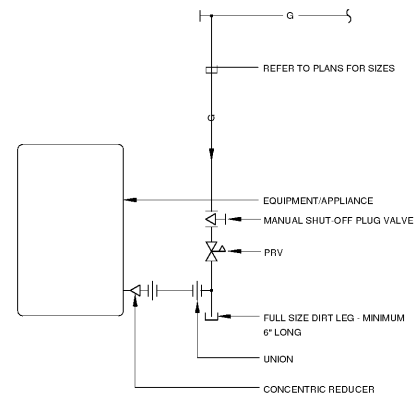


2 DETAIL - GAS EQUIPMENT CONNECTION
SCALE: N.T.S.

Order Plans @ www.LDILine.com

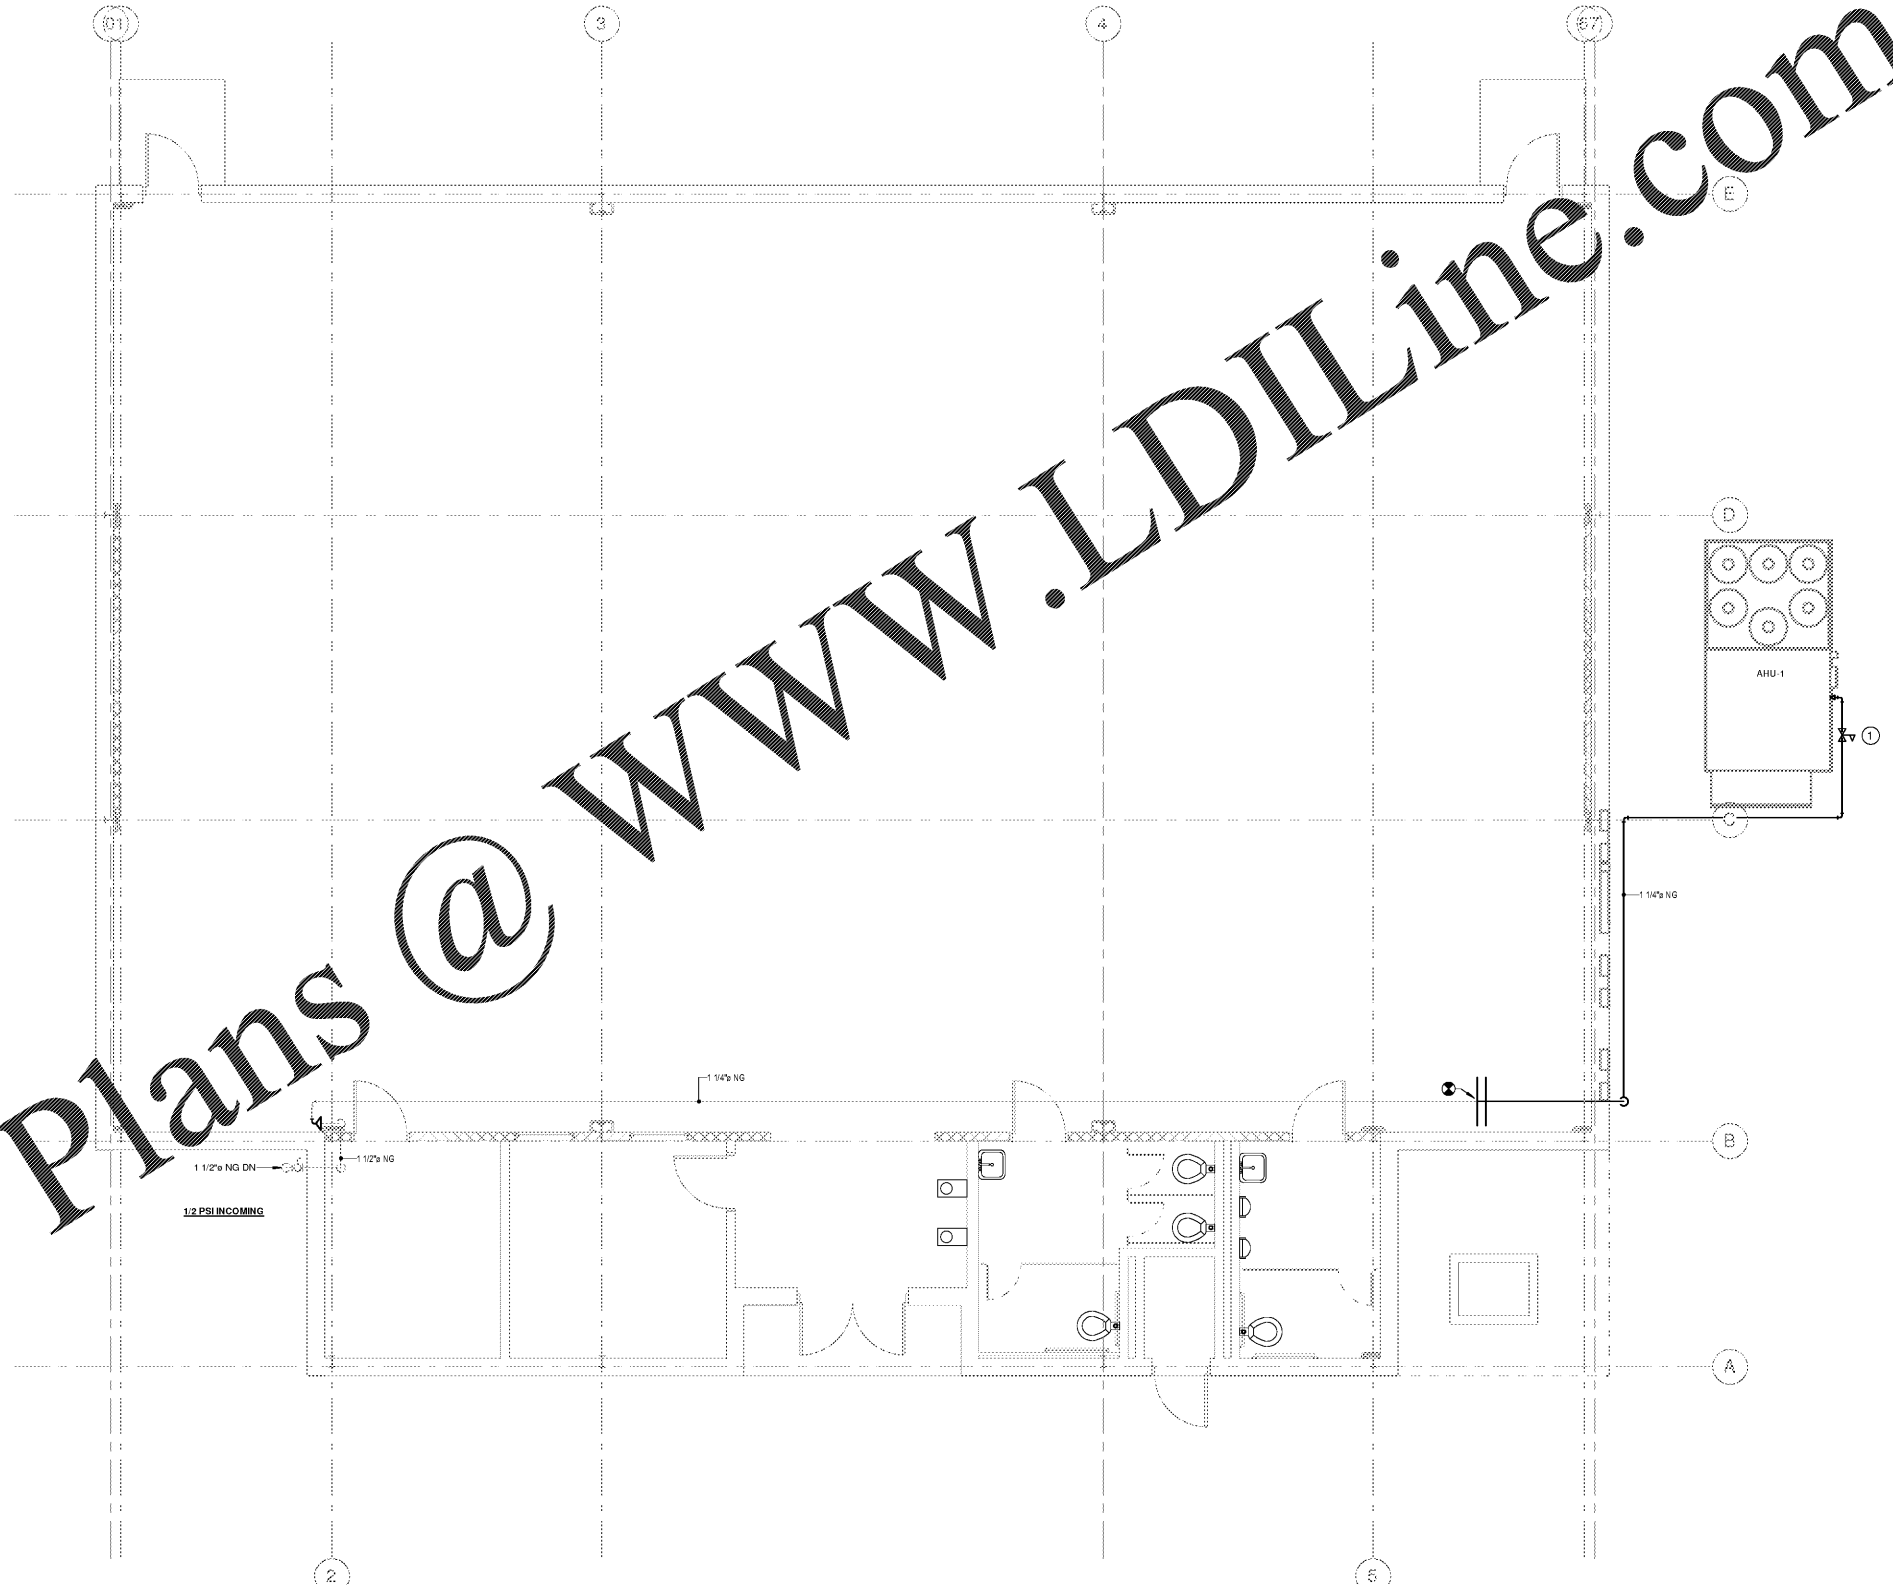

 1 LEVEL 1 PLUMBING PLAN
SCALE: 1/4" = 1'-0"



**WADSWORTH MAGNET SCHOOL
GYM HVAC DESIGN**
3039 Santa Monica Drive
Decatur, Georgia 30032

**STANLEY
LOVE
STANLEY
P A C**

ARCHITECTURE
INTERIORS PLANNING
PROGRAM MANAGEMENT

1186 SPRING STREET, N.W.
ATLANTA, GEORGIA 30309-3919
404.576.0596
404.576.0607 fax
www.stanleylove-stanleypac.com

DRAWING TITLE
**PLUMBING LEVEL 1
PLAN**



CONSULTANT
rmf Engineering
888 HARRISON DRIVE SUITE 725
ATLANTA, GA 30328 478.915.0228

SCALES AS STATED HEREON ARE VALID ON THE ORIGINAL DRAWING. THE DIMENSIONS OF WHICH ARE SHOWN HEREON. THE SCALES OF THE DRAWING ARE HEREBY CHANGED BY THE RATIO OF THE OVERALL SHEET DIMENSIONS OF THE PRINT TO CORRESPONDING DIMENSIONS OF THE ORIGINAL DRAWING.

THE DRAWING IS THE PROPERTY OF STANLEY LOVE STANLEY P.A.C. AND IS NOT TO BE REPRODUCED OR COPIED IN WHOLE OR IN PART, IF IT IS TO BE USED ON THE PROJECT AND IS NOT TO BE USED ON ANY OTHER PROJECT. IT IS TO BE RETURNED UPON REQUEST.

COPYRIGHT © 2016. ALL RIGHTS RESERVED BY STANLEY LOVE STANLEY P.A.C.

DRAWING NO
DATE
01/31/2020
PROJECT NO
6919.6
DRAWING NO

P-101

RELEASED FOR CONSTRUCTION 01/31/2020