


Keynote Legend	
Key Value	Keynote Text
2	FABRIC DUCT, COORDINATE SIZE, LOCATION AND ATTACHMENT WITH MECHANICAL DRAWINGS.
14	NEW ROOF INSULATION AS REQUIRED AFTER HEATER VENT REMOVAL.
17	NEW EXTERIOR SUPPLY AIR DUCTWORK AND SUPPORT AS SHOWN ON DETAILS 7, 9 AND 10 ON MECHANICAL DRAWINGS M-401.

NOTE: REFER TO A 2.00 AND A3.00 FOR LOCATIONS AND EXTENT OF NEW METAL WALL PANEL(S) AND LINER PANEL(S).

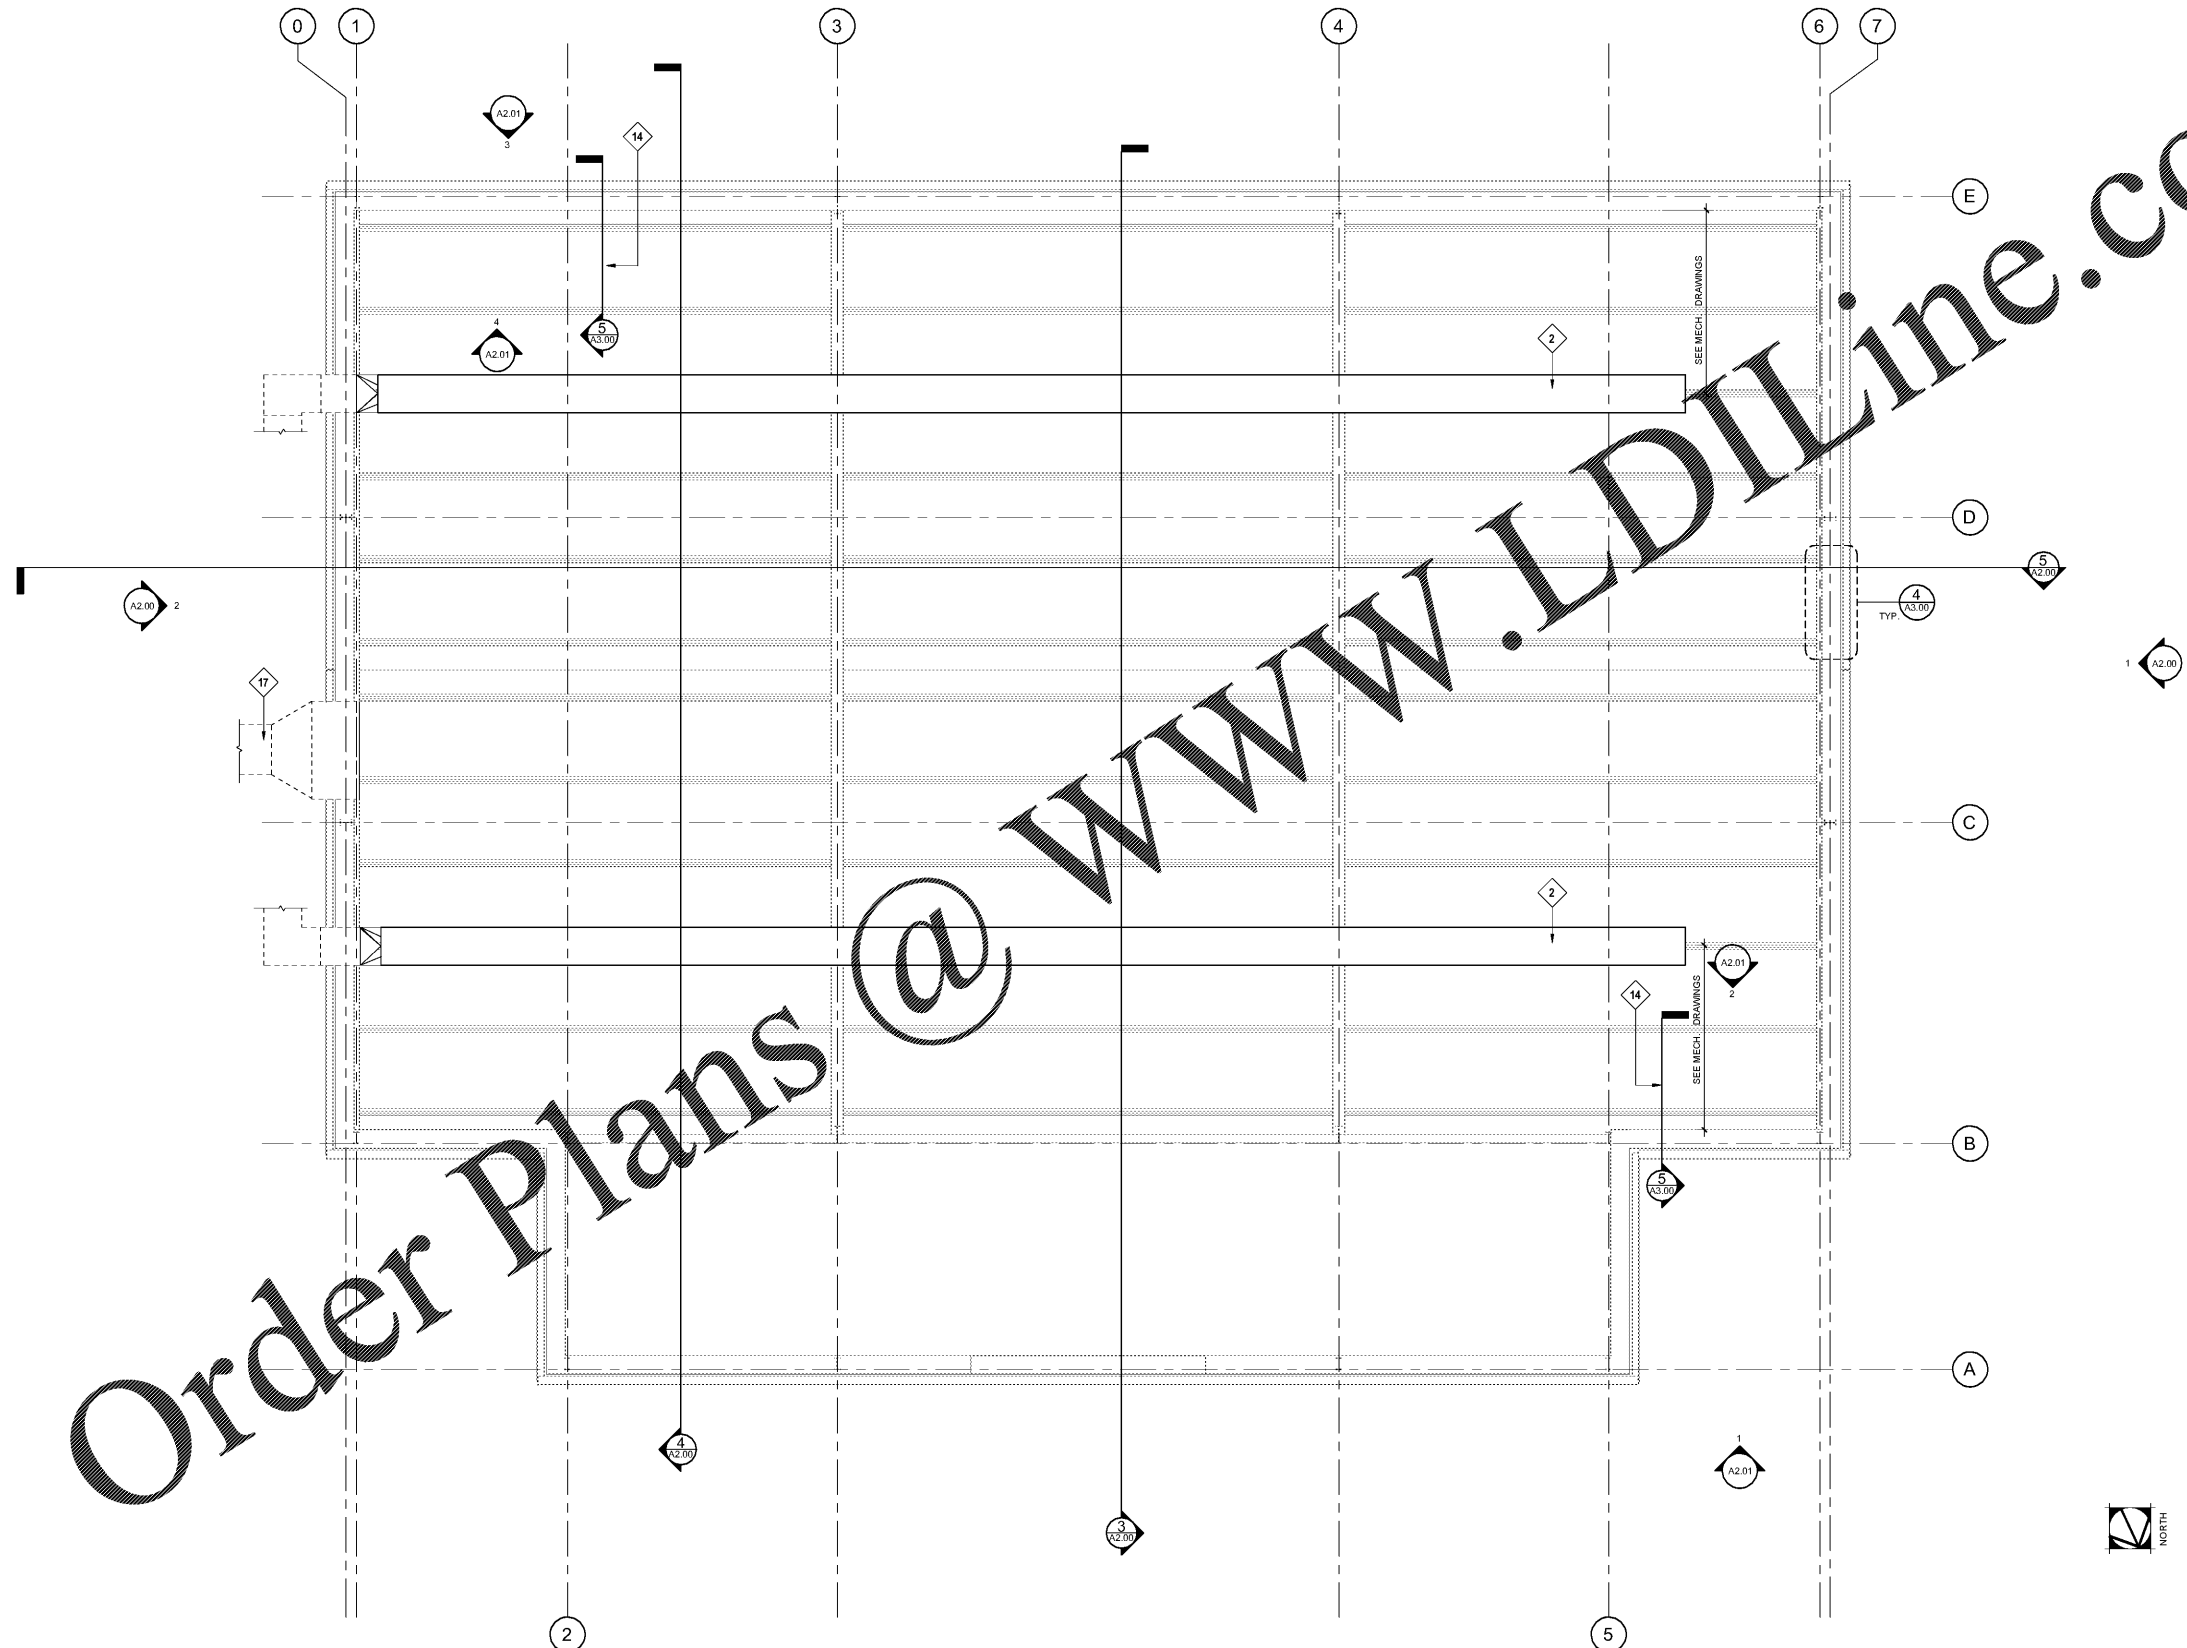

1 REFLECTED CEILING PLAN
1/4" = 1'-0"

Order Plans @ www.LDILine.com

**WOODWARD ELEMENTARY SCHOOL
GYM HVAC DESIGN**
3034 Curtis Drive,
Atlanta, Georgia 30319

**STANLEY
LOVE
STANLEY
P A C**
ARCHITECTURE
INTERIORS PLANNING
PROGRAM MANAGEMENT
1086 SPRING STREET, N.W.
ATLANTA, GEORGIA 30309
404.875.0008
www.stanleylove-stanley.com

DRAWING TITLE
**REFLECTED CEILING
PLAN**



CONSULTANT

SCALES AS STATED HEREON ARE VALID ON THE ORIGINAL DRAWING. THE DIMENSIONS OF WHICH ARE SHOWN ON THE SCALY. NOTED HEREON ARE HEREBY CHANGE BY THE PART OF THE OVERALL SHEET DIMENSIONS OF THE PRINT TO CORRESPONDING DIMENSIONS OF THE ORIGINAL DRAWING.

THIS DRAWING IS THE PROPERTY OF STANLEY LOVE STANLEY P.A.C. AND IS NOT TO BE REPRODUCED OR COPIED IN WHOLE OR IN PART. IT IS ON LY TO BE USED FOR THE PROJECT AND SITE SPECIFICALLY IDENTIFIED HEREON AND IS NOT TO BE USED ON ANY OTHER PROJECT. IT IS TO BE RETURNED UPON REQUEST.

COPYRIGHT © 2018. ALL RIGHTS RESERVED
STANLEY LOVE STANLEY P.A.C.
DRAWING NO.

DATE
01/06/2020
PROJECT NO.
6919.12
DRAWING NO.

A1.10