


GENERAL NOTES

 
1. REFER TO CIVIL PLANS FOR INFORMATION ON FENCE AROUND AHU-1.
2. CONTRACTOR TO PROVIDE STRUCTURAL SUPPORT TO EXTERIOR DUCTWORK AS NECESSARY. REFER TO SPECIFICATIONS FOR INFORMATION ON EXTERIOR DUCTWORK AND REQUIREMENTS.

DRAWING NOTES

- 1 NEW ROUND DUCT TO BE FABRIC DUCT WITH INTERNAL SUPPORT. SEE M-401 FOR FABRIC DUCT DETAILS.
- 2 ADD ALTERNATE: PROVIDE NEW DOOR LOUVER AND INSTALL IN RESTROOM DOORS. SEE SCHEDULE FOR LOUVER DIMENSIONS AND LOCATION.

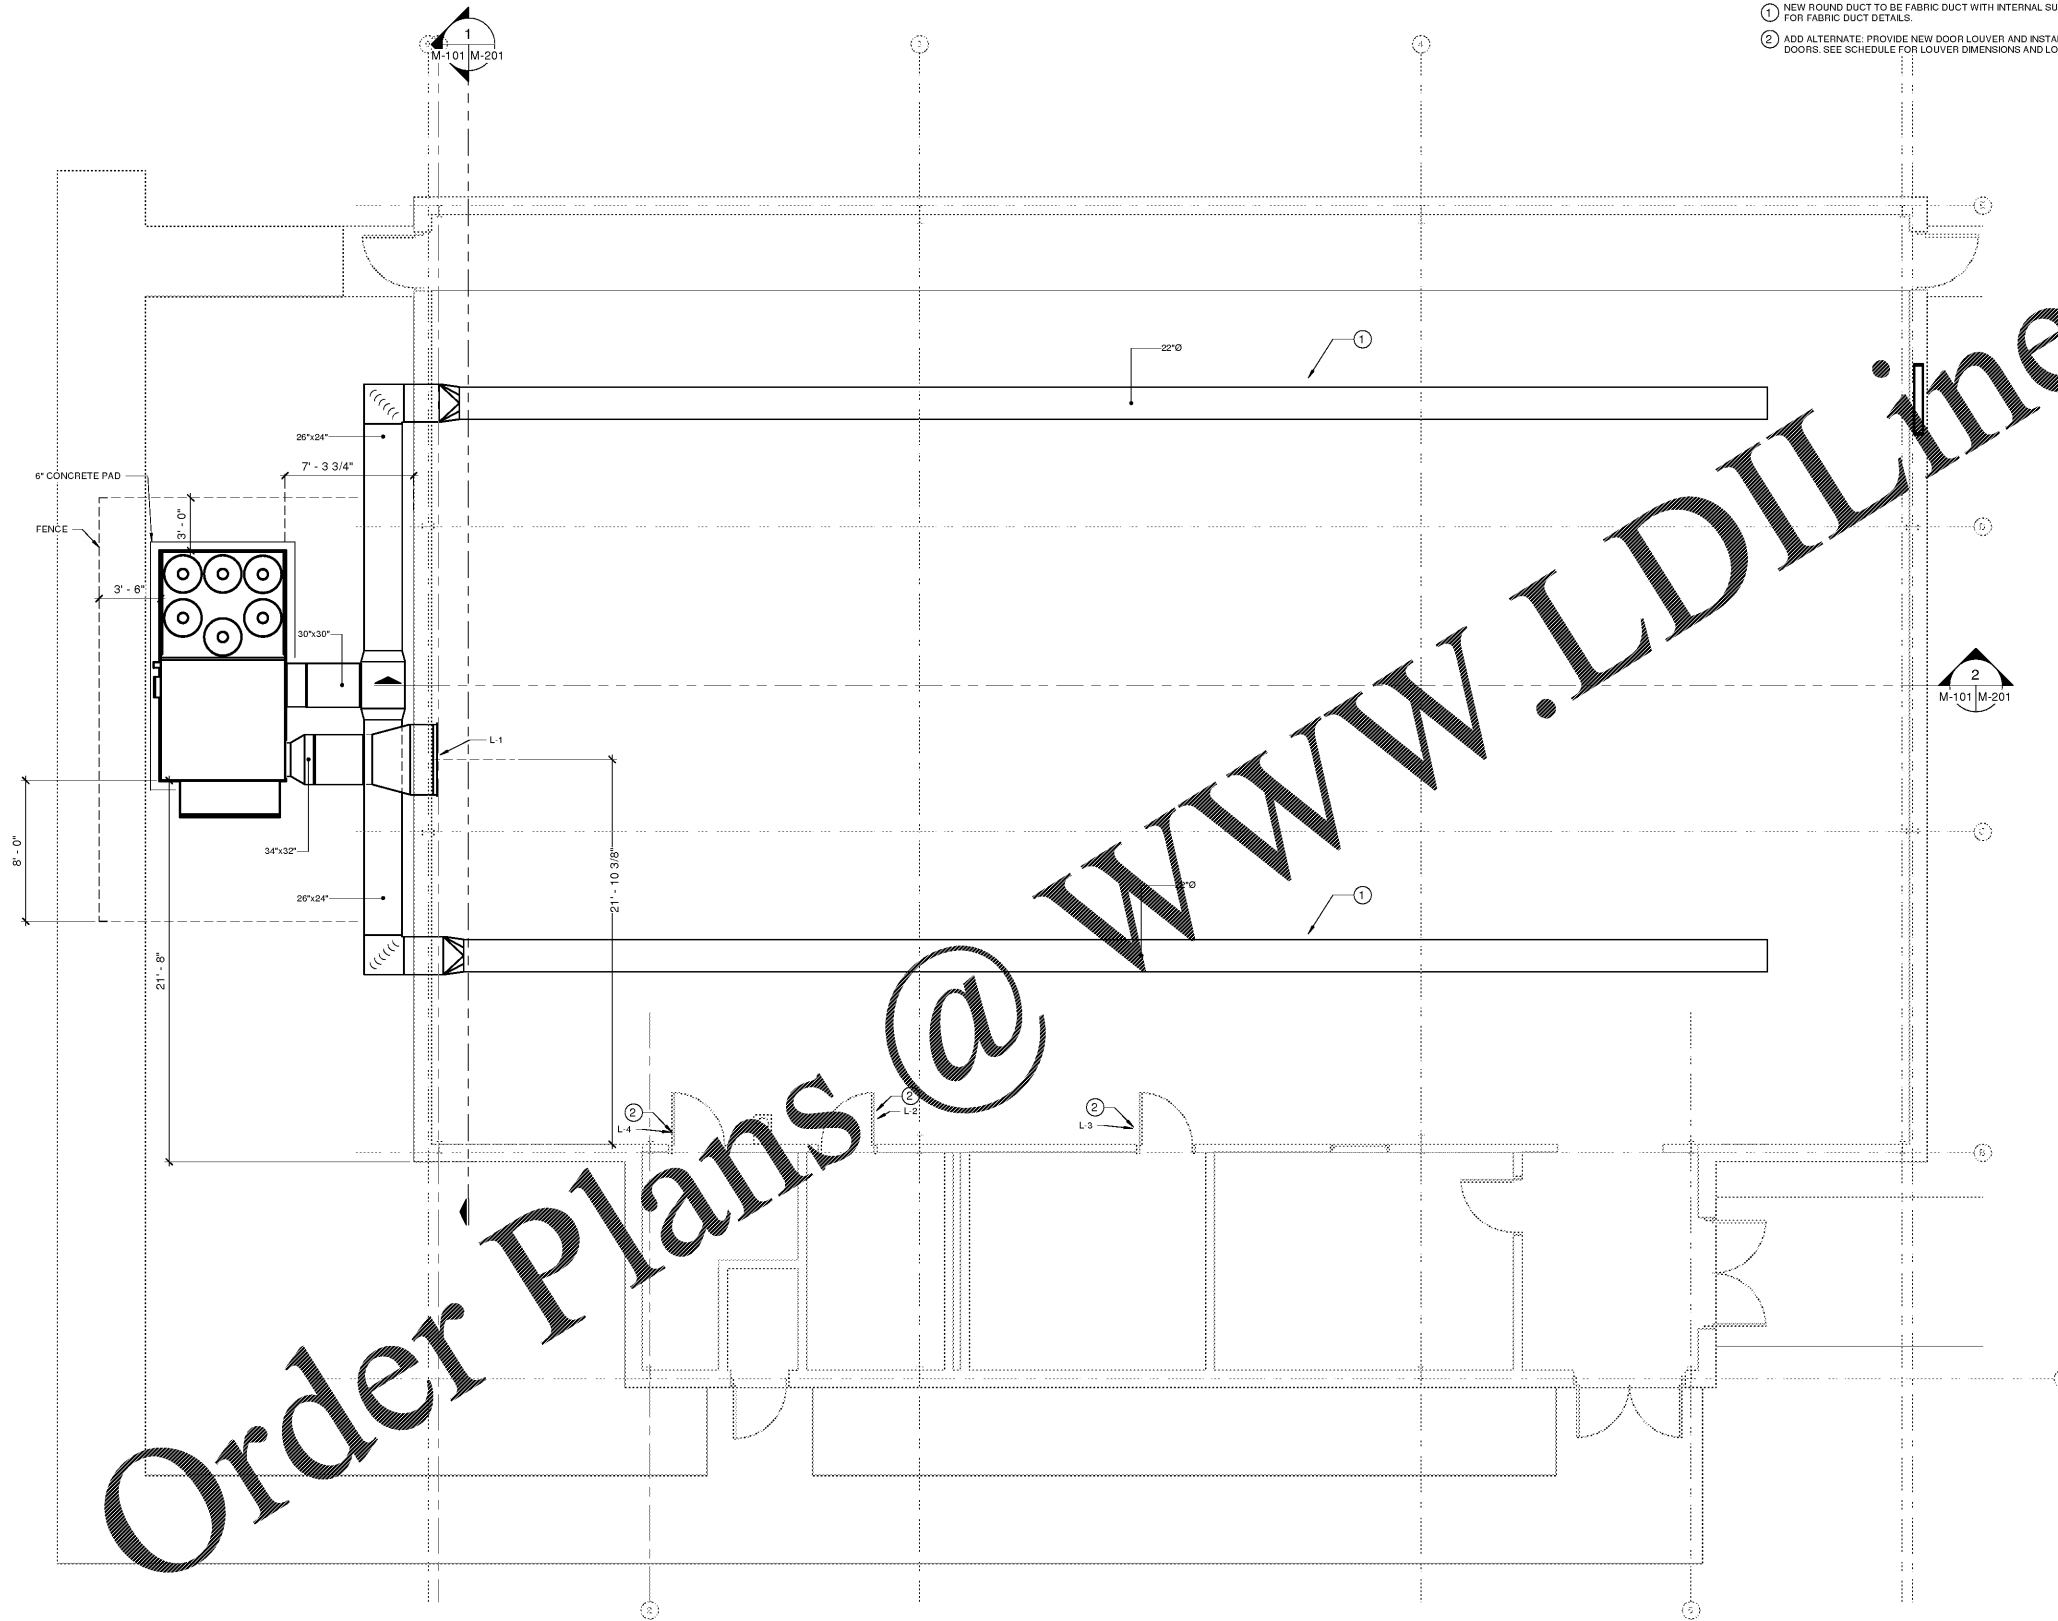

LEVEL 1 HVAC DUCTWORK PLAN
SCALE: 1/4" = 1'-0"



Order Plans @ WWW.LDILine.com

WOODWARD ELEMENTARY SCHOOL
GYM HVAC DESIGN
3034 Curtis Drive
Atlanta, Georgia 30319

STANLEY LOVE STANLEY P A C
ARCHITECTURE
INTERIORS PLANNING
PROGRAM MANAGEMENT
1186 SPRING STREET, N.W.
ATLANTA, GEORGIA 30309-3813
404.576.0536
404.576.0847 fax
www.stanleylove-stanleypac.com

DRAWING TITLE
**MECHANICAL LEVEL 1
DUCTWORK PLAN**



CONSULTANT

SCALES AS STATED HEREON ARE VALID ON THE ORIGINAL DRAWING. THE DIMENSIONS OF WHICH ARE SHOWN HEREIN. THE SCALE IS THE RATIO OF THE OVERALL SHEET DIMENSIONS OF THE PRINT TO CORRESPONDING DIMENSIONS OF THE ORIGINAL DRAWING.
THIS DRAWING IS THE PROPERTY OF STANLEY LOVE STANLEY, P.C. AND IS NOT TO BE REPRODUCED, COPIED, OR IN ANY MANNER, WITHOUT THE WRITTEN CONSENT OF STANLEY LOVE STANLEY, P.C. IF ANY PART OF THIS DRAWING IS USED FOR ANY OTHER PROJECT, IT IS TO BE RETURNED UPON REQUEST.
COPYRIGHT © 2016. ALL RIGHTS RESERVED BY STANLEY LOVE STANLEY, P.C.

DRAWING NO.
DATE
01/06/2020
PROJECT NO.
6919.12
DRAWING NO.

M-101

RELEASED FOR CONSTRUCTION 01/06/2020