


|             |            |
|-------------|------------|
| 100% CD SET | 01/06/2020 |
|             |            |
|             |            |
**GENERAL NOTES**

1. THIS CONTRACT REQUIRES COMPLETE, FINISHED WORKABLE PROJECT OF THE AREAS INDICATED BY THE CONTRACT DOCUMENTS, AND SHALL INCLUDE ALL MATERIALS AND LABOR NECESSARY TO COMPLETE SAME, REGARDLESS OF WHETHER OR NOT EACH AND EVERY NECESSARY WORK ITEM IS SPECIFICALLY INDICATED ON ANY OTHER PORTION OF THE DRAWING AND/OR NOTES.
2. ALL DETAILS AND SECTIONS SHOWN ON THE DRAWINGS ARE INTENDED TO BE TYPICAL, AND SHALL BE CONSTRUED TO APPLY TO ANY SIMILAR SITUATION ELSEWHERE ON THE PROJECT, EXCEPT WHERE A DIFFERENT DETAIL IS SHOWN.
3. CONTRACTOR SHALL FURNISH ALL ADDITIONAL DATA AND DOCUMENTATION TO SECURE ALL REQUIRED PERMITS AND SHALL COORDINATE THIS DATA WITH THE CONSTRUCTION DOCUMENTS WHERE REQUIRED.
4. AS A MINIMUM, ALL WORK SHALL CONFORM TO THE APPLICABLE BUILDING CODE ADOPTED BY THE JURISDICTION OF THE WORK. WHERE MORE STRINGENT CODES ARE ADOPTED, THEY SHALL GOVERN THE WORK.
5. ALL WORK SHALL CONFORM TO APPLICABLE FEDERAL, STATE, COUNTY AND LOCAL CODES AND ORDINANCES.
6. TO PROVIDE ACCESSIBILITY FOR THE PHYSICALLY HANDICAPPED, ALL WORK SHALL CONFORM TO PUBLIC LAW 101-336 (AMERICANS WITH DISABILITIES ACT OF 1990).
7. ALL WORK SHALL CONFORM TO THE APPLICABLE NFPA 101 LIFE SAFETY CODE ADOPTED BY THE JURISDICTION OF THE WORK.
8. AROUND ALL EXPOSED PIPES, CONDUIT OR DUCTS, INSTALL ENCLOSURES OF THE SAME MATERIAL AND FINISH AS ADJACENT WORK, UNLESS NOTED OTHERWISE.
9. FIELD CHECK ALL ROUGH AND/OR FINISH DIMENSIONS FOR ACCURATE FITTING OF CABINETS, COUNTERTOPS, FIXTURES AND ACCESSORIES BEFORE FABRICATION. PROVIDE AND INSTALL NECESSARY FILLERS, SCRIBE STRIPS, PANELS, BASES OR TRIM TO COMPLETE AND FINISH ALL INSTALLATIONS.
10. CONTRACTOR SHALL FIELD VERIFY ALL DIMENSIONS AND SITE CONDITIONS FOR ALL COMMON WORK. PROVIDE AND INSTALL ALL NECESSARY HARDWARE, BRACKETS, BRIMS, ANCHORS, PINS, BOLTS, BLOCKING, FURRING OR OTHER SUPPLEMENTARY ITEMS NEEDED TO COMPLETE ALL INSTALLATIONS OF EQUIPMENT, FIXTURES AND ACCESSORIES.
11. ALL CONTRACTORS ARE TO COORDINATE THE WORK OF ALL TRADES AT THE PROJECT AND SCHEDULE ARE NOT IMPEDED. SCHEDULE WORK PROGRESS THROUGHOUT THE ENTIRE PROJECT TO PREVENT CONFLICTS AND INTERFERENCE. OBTAIN NECESSARY PERMISSIONS SUCH AS SIZES, LOCATIONS, TEMPLATES, LAYOUT, DIMENSIONS AND ANY OTHER INFORMATION NECESSARY FOR A PROPER AND WELL COORDINATED INSTALLATION. REFER TO INSTALLATION OF ITEMS, CONFER WITH EACH CONTRACTOR EXACT LOCATION OF ALL ITEMS.
12. WHERE MATERIALS REFERENCED ON DRAWINGS, OR SPECIFICATIONS TO COMPLETE THE WORK OF THIS CONTRACT ARE NOT SPECIFIED HEREIN, PROVIDE BEST QUALITY MATERIALS. WHERE MATERIALS ARE INTENDED TO MATCH EXISTING, PROVIDE CLOSEST POSSIBLE MATCH, SUBJECT TO OWNER'S APPROVAL. ALL ITEMS AND WORK ON DRAWINGS ARE UNLESS INDICATED OTHERWISE. ALL WORK WHICH HAS BEEN DAMAGED SHALL BE REPAIRED OR REPLACED. WHERE ITEM CANNOT BE REPAIRED TO A "NEW CONDITION", OR WHEN STRUCTURAL INTEGRITY HAS BEEN AFFECTED, ITEM SHALL BE REPLACED.

**DRAWING NOTES**


1. PROVIDE NEMA-3R, 100A, 480V, 3-POLE, UNIT MOUNTED NFSS FOR AHU-1.
2. PROVIDE BRANCH CIRCUIT AS INDICATED; ELECTRICAL CONVENIENCE RECEPTACLE PROVIDED WITH UNIT.
3. PROVIDE DUCT SMOKE DETECTOR IN SUPPLY AND RETURN DUCT. COORDINATE INSTALLATION WITH DIV 23. CONNECT TO EXISTING FIRE ALARM PULLSTATION LOCATED NEXT TO ENTRANCE DEVICE SHALL MATCH EXISTING FIRE-LITE FIRE ALARM SYSTEM. PROVIDE REPROGRAMMING AS NECESSARY TO FIRE ALARM SYSTEM TO ACCOMMODATE DEVICE.
4. EXISTING FIRE-LITE FIRE ALARM PULLSTATION.
5. BRANCH CIRCUIT FOR AHU-1 TO BE FED FROM EXISTING UNNAMED PANELBOARD LOCATED IN THE BOILER ROOM APPROXIMATELY 350' NORTH EAST OF NEW AHU-1. PROVIDE DIRECT BURIED BRANCH CIRCUIT FOR AHU-1 IN 1/2" INCHES 40 PVC AT MINIMUM 18 INCHES TO TOP OF DUCT BELOW FINISHED GRADE. ELBOWS AND FITTINGS SHALL BE OVC AT CHANGES OF DIRECTION IN DUCT RUN. RUN CONDUIT AS DIRECTLY AS POSSIBLE MINIMIZING DISTURBANCES TO HARDSCAPE. PROVIDE FULL-BOXES OR HANDHOLES AS REQUIRED TO COMPLY WITH NEC 350.26. FIELD VERIFY EXACT ROUTING LOCATION; COORDINATE WITH EXISTING UTILITIES. REFER TO SHEET E-601.

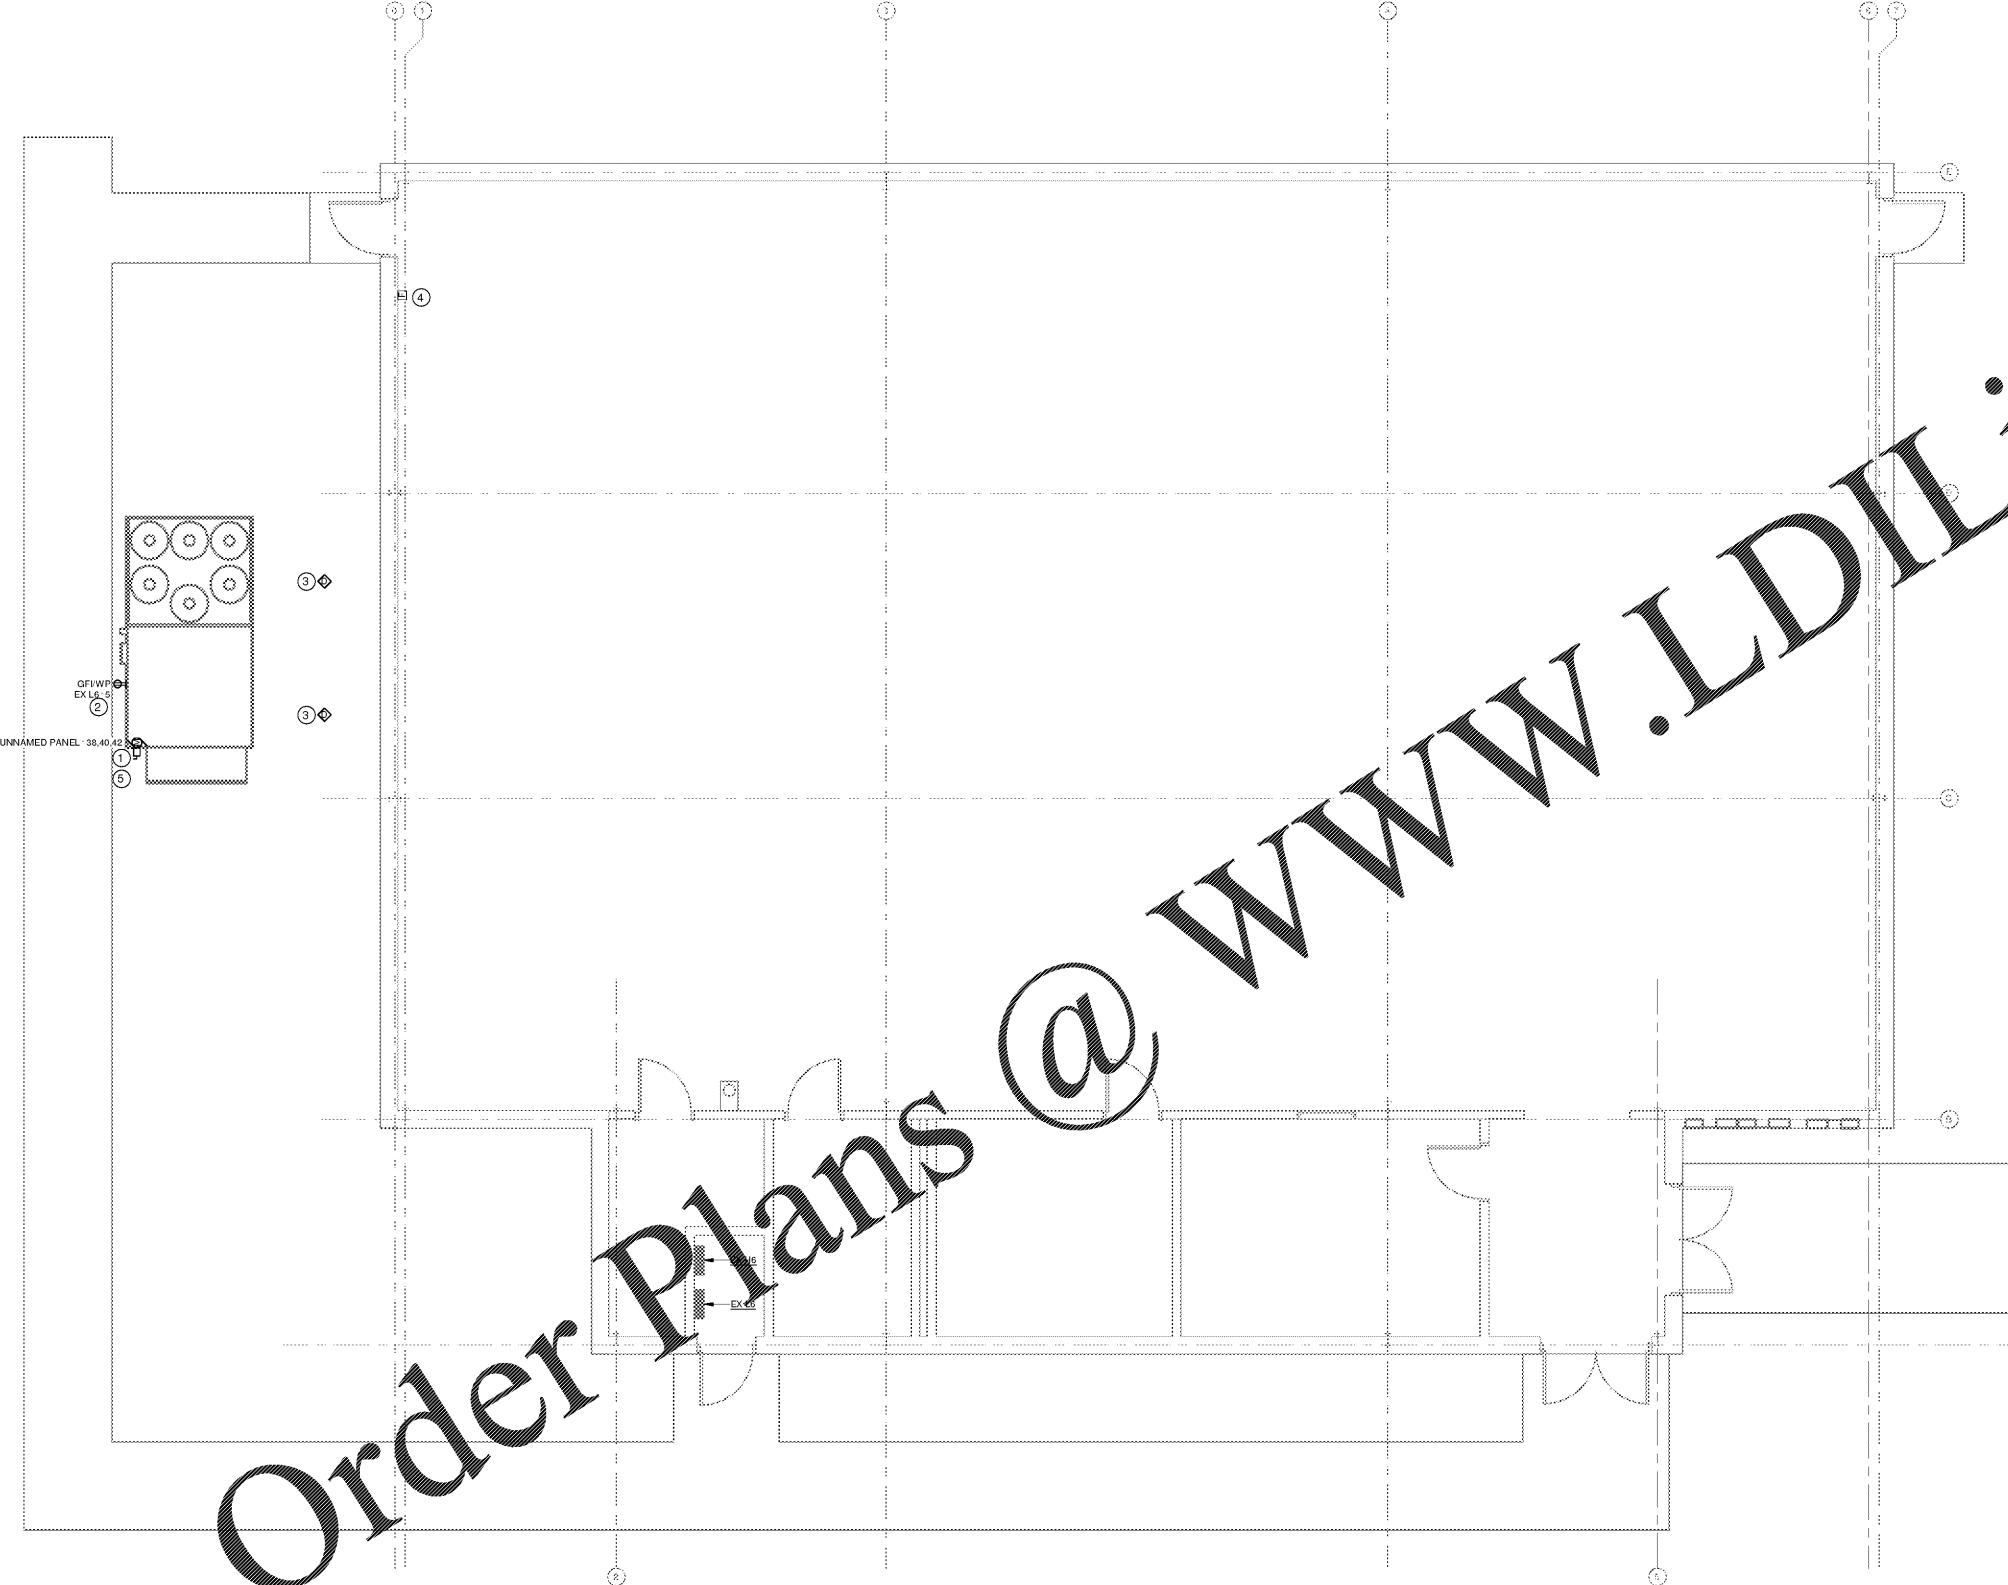

Order Plans @ www.LDILine.com

UNNAMED PANEL - 38.40.12

 **LEVEL 1 POWER PLAN**  
SCALE: 1/4" = 1'-0"



**WOODWARD ELEMENTARY SCHOOL  
GYM HVAC DESIGN**  
3034 Curtis Drive  
Atlanta, Georgia 30319



ARCHITECTURE  
INTERIORS PLANNING  
PROGRAM MANAGEMENT  
1186 SPRING STREET, N.W.  
ATLANTA, GEORGIA 30309-3018  
404.576.6208  
www.stanleylove-stanleypac.com

DRAWING TITLE  
**ELECTRICAL LEVEL 1  
POWER PLAN**



CONSULTANT

SCALES AS STATED HEREON ARE VALID ON THE ORIGINAL DRAWING. THE DIMENSIONS OF WHICH ARE BEING TAKEN. THE SCALES OF THE NOTES HEREON ARE SUBJECT TO CHANGE BY THE RATIO OF THE OVERALL SHEET DIMENSIONS OF THIS PRINT TO CORRESPONDING DIMENSIONS OF THE ORIGINAL DRAWING.  
THIS DRAWING IS THE PROPERTY OF STANLEY LOVE-STANLEY PAC AND IS NOT TO BE REPRODUCED, COPIED, REPRODUCED, OR TRANSMITTED IN ANY FORM OR BY ANY MEANS, WITHOUT THE WRITTEN PERMISSION OF STANLEY LOVE-STANLEY PAC. THIS DRAWING IS NOT TO BE USED ON ANY OTHER PROJECT. IT IS TO BE RETURNED UPON REQUEST.  
COPYRIGHT © 2016. ALL RIGHTS RESERVED BY STANLEY LOVE-STANLEY PAC.

|             |            |
|-------------|------------|
| DRAWING NO. |            |
| DATE        | 01/06/2020 |
| PROJECT NO. | 6919.12    |
| DRAWING NO. |            |

**E-101**

RELEASED FOR CONSTRUCTION 01/06/2020