


Order Plans @

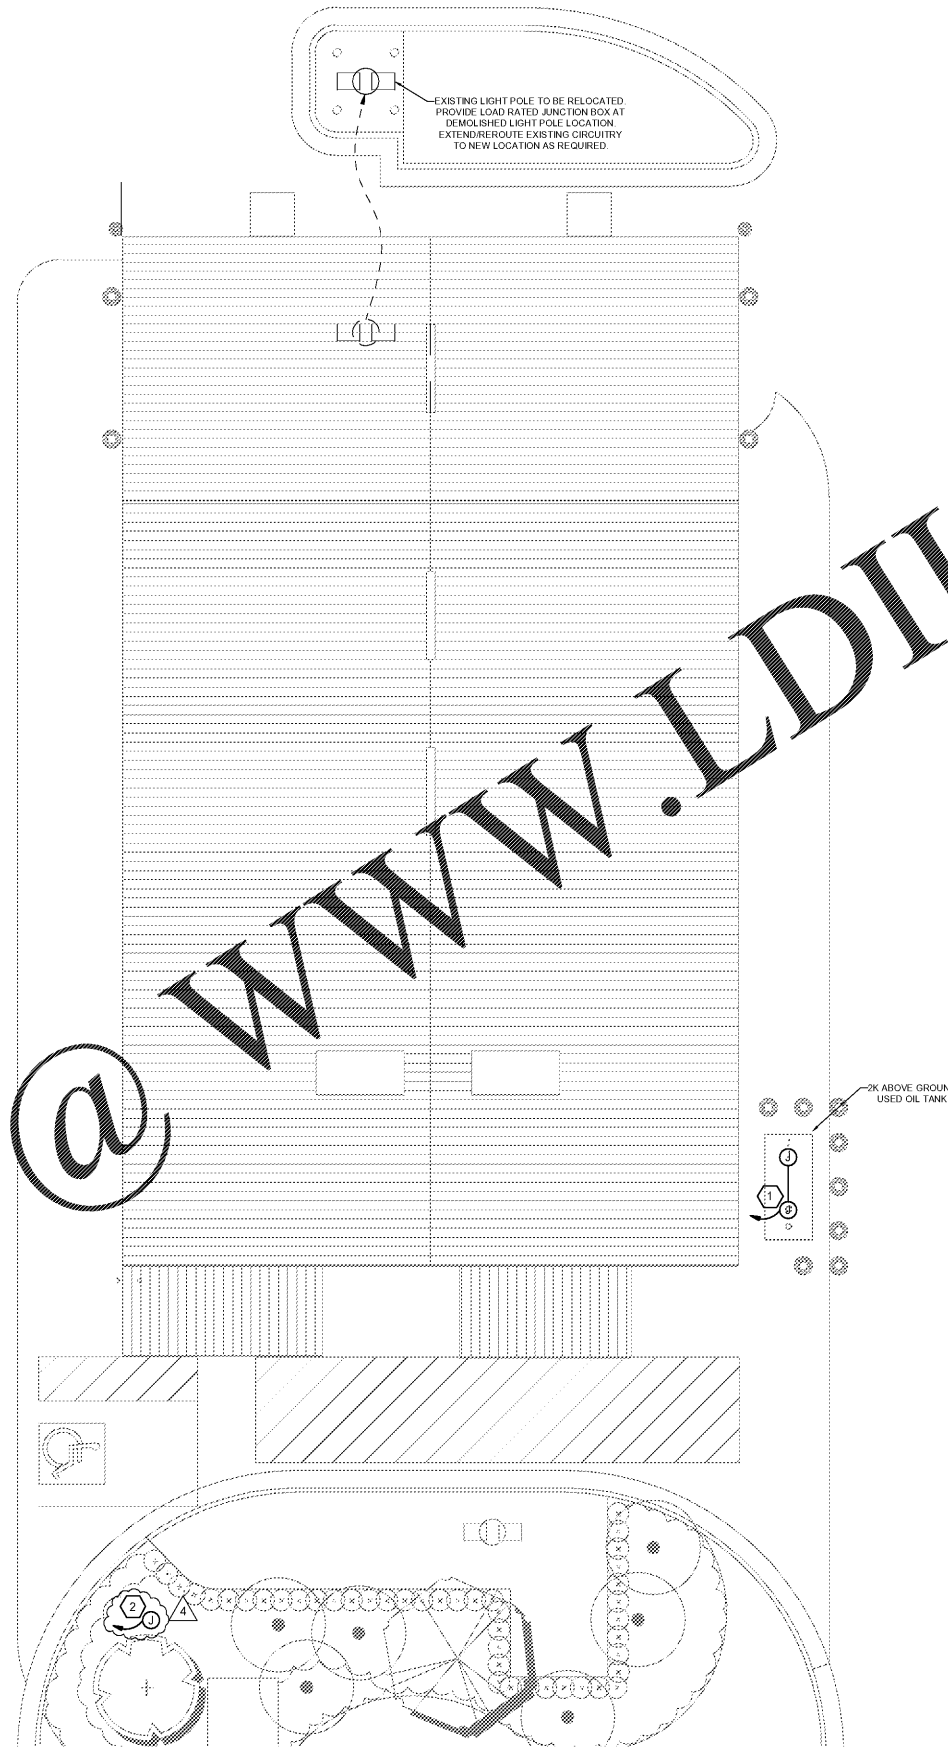

WWW.LDILine.com

KEYNOTES

1. INSTALL 1" GRC FOR TANK PROBE AND SENSOR FROM FRANKLIN FUEL MONITORING PANEL. ROUTE CONDUIT ALONG FUEL PIPING. REFER TO OIL DRAWING FOR MORE INFORMATION.
2. PROVIDE AND INSTALL 3/4" CONDUIT FROM WATER PROOF J-BOX TO FRANKLIN FUEL MONITORING PANEL LOCATED IN THE TIRE SHOP. SEE SHEET YE4 FOR CONTINUATION.

HFA
HARRISON FRENCH & ASSOCIATES, L.T.D.
 1705 S. Walton Blvd., Suite 3
 Bentonville, Arkansas 72712
 t 479.273.7780
 f 888.520.9685
 www.hfa-ac.com

STIPULATION FOR REUSE
 THIS DRAWING AND THE INFORMATION CONTAINED HEREIN IS THE PROPERTY OF HARRISON FRENCH & ASSOCIATES, L.T.D. AND IS TO BE USED ONLY FOR THE PROJECT AND SITE SPECIFICALLY IDENTIFIED HEREIN. ANY REUSE OF THIS DRAWING FOR ANY OTHER PROJECT WITHOUT THE WRITTEN AUTHORIZATION OF HARRISON FRENCH & ASSOCIATES, L.T.D. IS STRICTLY PROHIBITED.

200 S KINGS HWY
 FORT PIERCE, FL 34945
 SPEEDCO REBRANDING &
 LIGHT MECHANICAL ADDITION
 PROJECT NUMBER: 05-19-60467

Loves
**Travel Stop &
 Country Stores**

SEAL OF THE FLORIDA PROFESSIONAL ENGINEER
 No. 61148
 STATE OF FLORIDA
 HARRISON FRENCH & ASSOCIATES, L.T.D.
 1705 S. WALTON BLVD., SUITE 3
 BENTONVILLE, ARKANSAS 72712
 (479) 273-7780

ISSUE BLOCK		
4	05/22/20	ADD 4

STORE NO.	467
DOCUMENT DATE	05/14/19
CHECKED BY	NKC
DRAWN BY	CAR
PROTO CYCLE	

SITE POWER PLAN

SHEET: YE5

1 SITE POWER PLAN
 SCALE: 1" = 10'-0"

EACH SUBCONTRACTOR IS RESPONSIBLE FOR HAVING A THOROUGH KNOWLEDGE OF ALL DRAWINGS AND SPECIFICATIONS IN THEIR RELATED FIELD. THE FAILURE TO ACQUAINT HIMSELF WITH THIS KNOWLEDGE DOES NOT RELIEVE THE RESPONSIBILITY OF PERFORMING HIS WORK PROPERLY. NO ADDITIONAL COMPENSATION SHALL BE ALLOWED BECAUSE OF CONDITIONS THAT OCCUR DUE TO FAILURE TO FAMILIARIZE WORKERS WITH THIS KNOWLEDGE.