


Order Plans @ [www.IDLine.com](http://www.IDLine.com)

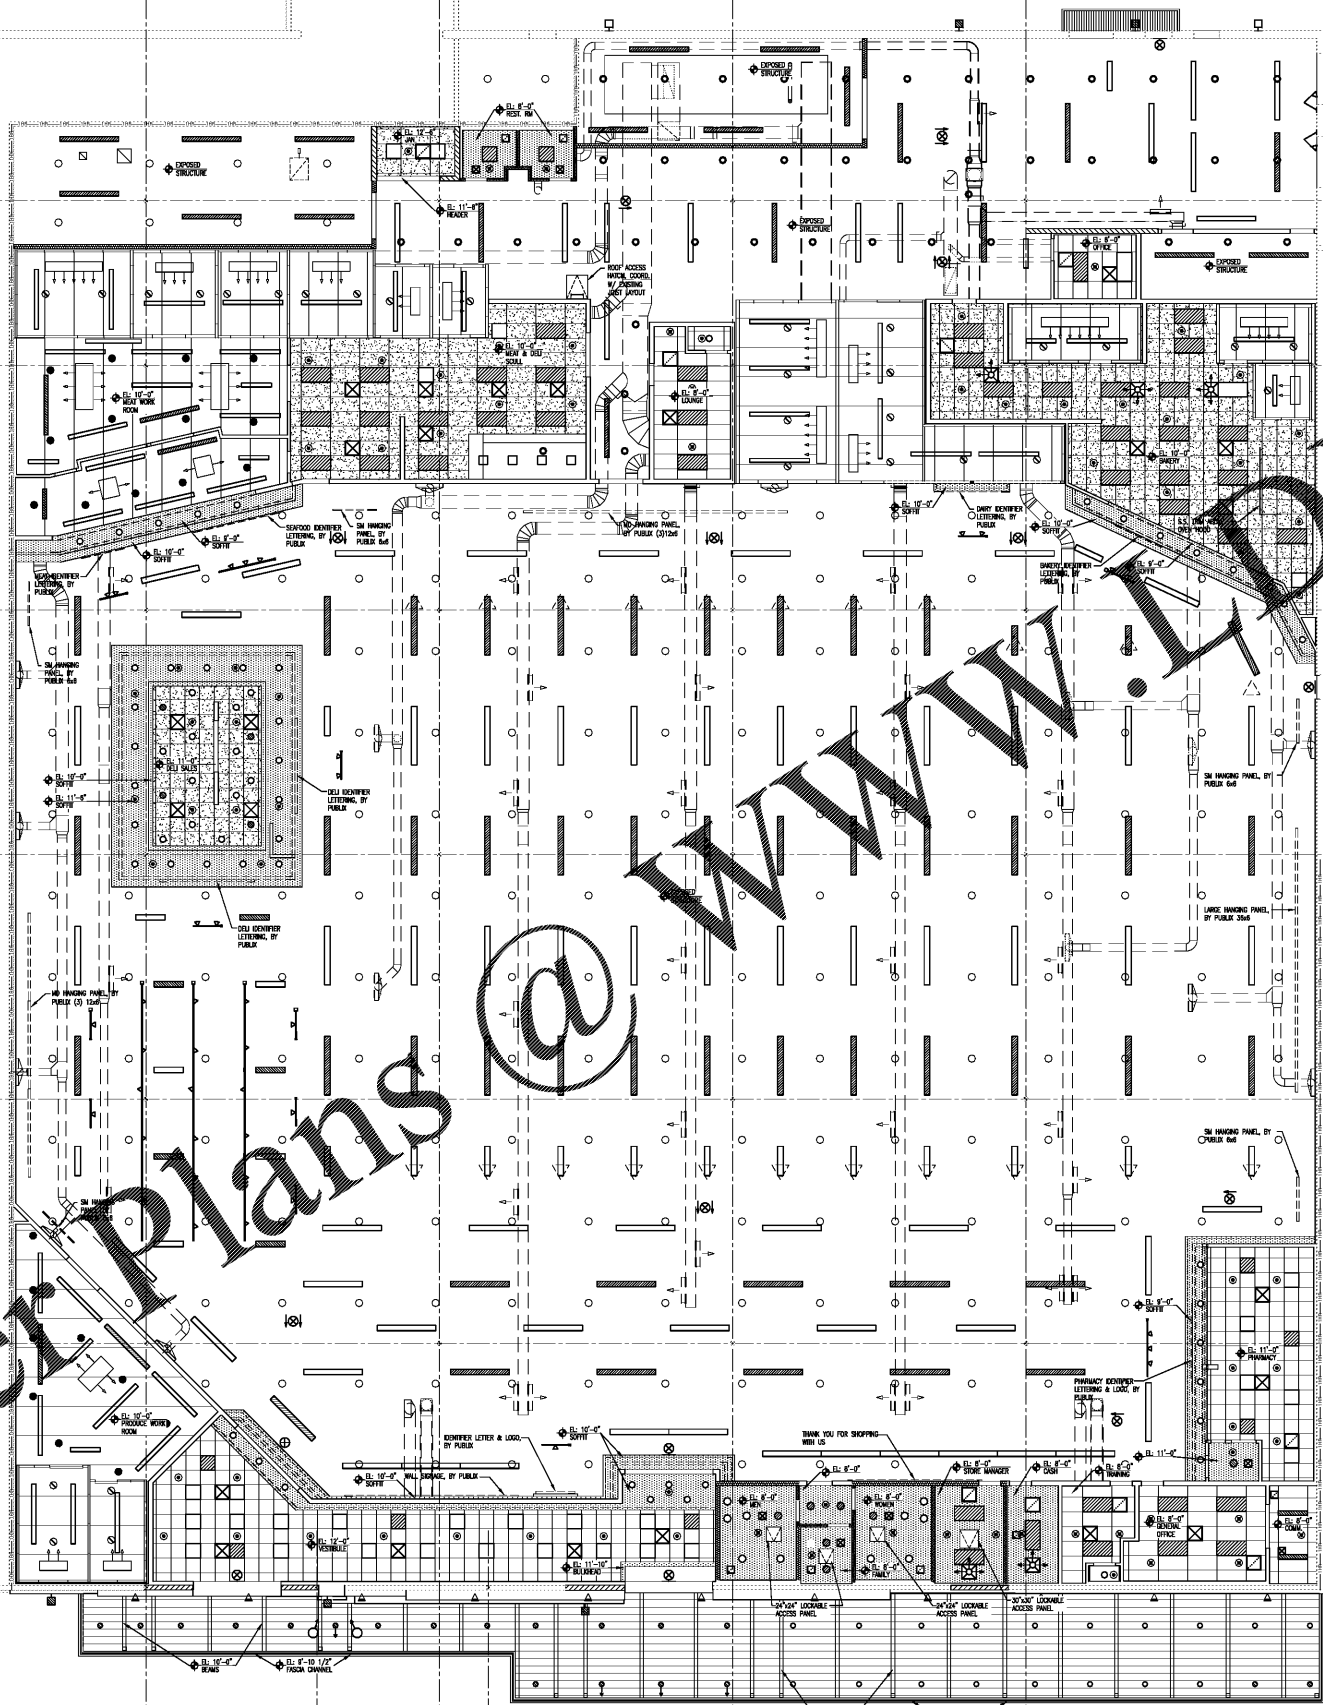

**CEILING PLAN LEGEND**

	LIGHT FIXTURES SEE ELECTRICAL
	EXIT LIGHTS
	WALL MOUNTED FEATURES
	DRY BOARD CEILING
	24\"/>
	36\"/>
	VINYL FACED OPUS PANEL LAY-IN CEILING SYSTEM
	FIRE PROTECTION SPRINKLERS
	REGISTERS, GRILLES, & DIFFUSERS
	SOUNDLUSE
	SPEAKER CEILING w/ VOL. CONTROL
	VOLUME CONTROL (WALL MTD)
	BAFFLE (12\"/>
	BAFFLE (12\"/>
	COOLER BAFFLE

**DRAWING NOTES:**

1. ALL VINYL FACED CEILING MUST BE INSTALLED PER IBC LOCAL SEISMIC CATEGORY REQUIREMENTS.
2. ALL FLOOR SPRINKLER RISERS USE VINYL FACED CEILING TILE. SEE PLAN A2.7 & ROOM FINISH SCHEDULE.
3. REFER TO SOFFIT PLAN, AND, OR WALL SECTIONS FOR WALL HEIGHTS.

**REFLECTED CEILING PLAN**  
1/8" = 1'-0"

THE OWNER HAS BEEN ELECTRONICALLY SIGNED AND SEALED BY WILLIAM JOE FISHER, ARCHITECT, P.A., USING A DIGITAL SIGNATURE AND SEAL. PUBLISHED COPIES OF THIS DOCUMENT ARE NOT CONSIDERED SIGNED AND SEALED AND THE SIGNATURE MUST BE VERIFIED ON ANY ELECTRONIC COPIES.

**REFLECTED CEILING PLAN**  
**EAST COBB PUBLIX - #1745**  
**EAST COBB CROSSING SHOPPING CENTER**  
ROSEWELL ROAD  
MARIETTA, GA 30062

RELEASED FOR:  
BY: [Signature]  
PERMIT: 07/16/20  
CONSTR.:

REVISIONS:


**Publix SUPER MARKETS**

CORPORATE OFFICES, FACILITIES DESIGN  
BOX 407, LAKELAND, FL 33802  
(863) 680-2525  
PHYSICAL ADDRESS:  
3300 AIRPORT BL., LAKELAND, FL 33811

**FISHER AND ASSOCIATES, L.L.C.**  
ARCHITECTS  
PLANNERS  
INTERIOR DESIGNERS  
2825 BELLARVO CLEARWATER, FL 33764 727/484408

**STATE OF GEORGIA**  
WILLIAM JOE FISHER, ARCHITECT  
ARCHITECT #8225

**A2.3**

Issue Date: 04-01-20  
Project No.: 220006