

Order Plans @ WWW.LDILine.com

THE ENGINEER HAS REVIEWED THE DRAWINGS AND APPROVES THEM FOR CONSTRUCTION. THE ENGINEER'S REVIEW IS LIMITED TO THE TECHNICAL ASPECTS OF THE DRAWINGS AND DOES NOT CONSTITUTE A GUARANTEE OF THE ACCURACY OF THE INFORMATION PROVIDED HEREON. THE ENGINEER SHALL NOT BE RESPONSIBLE FOR ANY ERRORS OR OMISSIONS IN THE DRAWINGS OR FOR ANY CONSEQUENCES ARISING THEREFROM. THE ENGINEER'S REVIEW IS LIMITED TO THE TECHNICAL ASPECTS OF THE DRAWINGS AND DOES NOT CONSTITUTE A GUARANTEE OF THE ACCURACY OF THE INFORMATION PROVIDED HEREON. THE ENGINEER SHALL NOT BE RESPONSIBLE FOR ANY ERRORS OR OMISSIONS IN THE DRAWINGS OR FOR ANY CONSEQUENCES ARISING THEREFROM.

PUBLIC PROTOTYPE BASIS OF DESIGN
20M
 EXPANDED
 RECEIVED: 08.14.18

CORPORATE OFFICES, INCLUDES DESIGN
 BOX 407, LAKELAND, FL 33607
 (850) 680-3295
 PHYSICAL ADDRESS
 1300 AIRPORT RD., LAKELAND, FL 33811

Publix
 SUPER MARKETS

FISHER AND ASSOCIATES, LLC
 ARCHITECTS
 PLANNERS
 INTERIOR DESIGNERS
 605 BELLEAIR RD. CLEARWATER, FL 33764 727-466-4400

ELECTRICAL SECONDARY LIGHTING PLAN
EAST COBB PUBLIX - #1745
 EAST COBB CROSSING SHOPPING CENTER
 ROSEWELL ROAD
 MARIETTA, GA 30062

RELEASED FOR:
 BID
 PERMIT 07/16/20
 CONSTR.


REVISIONS:

NO.	DATE	DESCRIPTION

HAROLD A. SCOTT
 GEORGIA P.E. #527908

E-2

Issue Date: 04-01-20
 Project No.: 220036

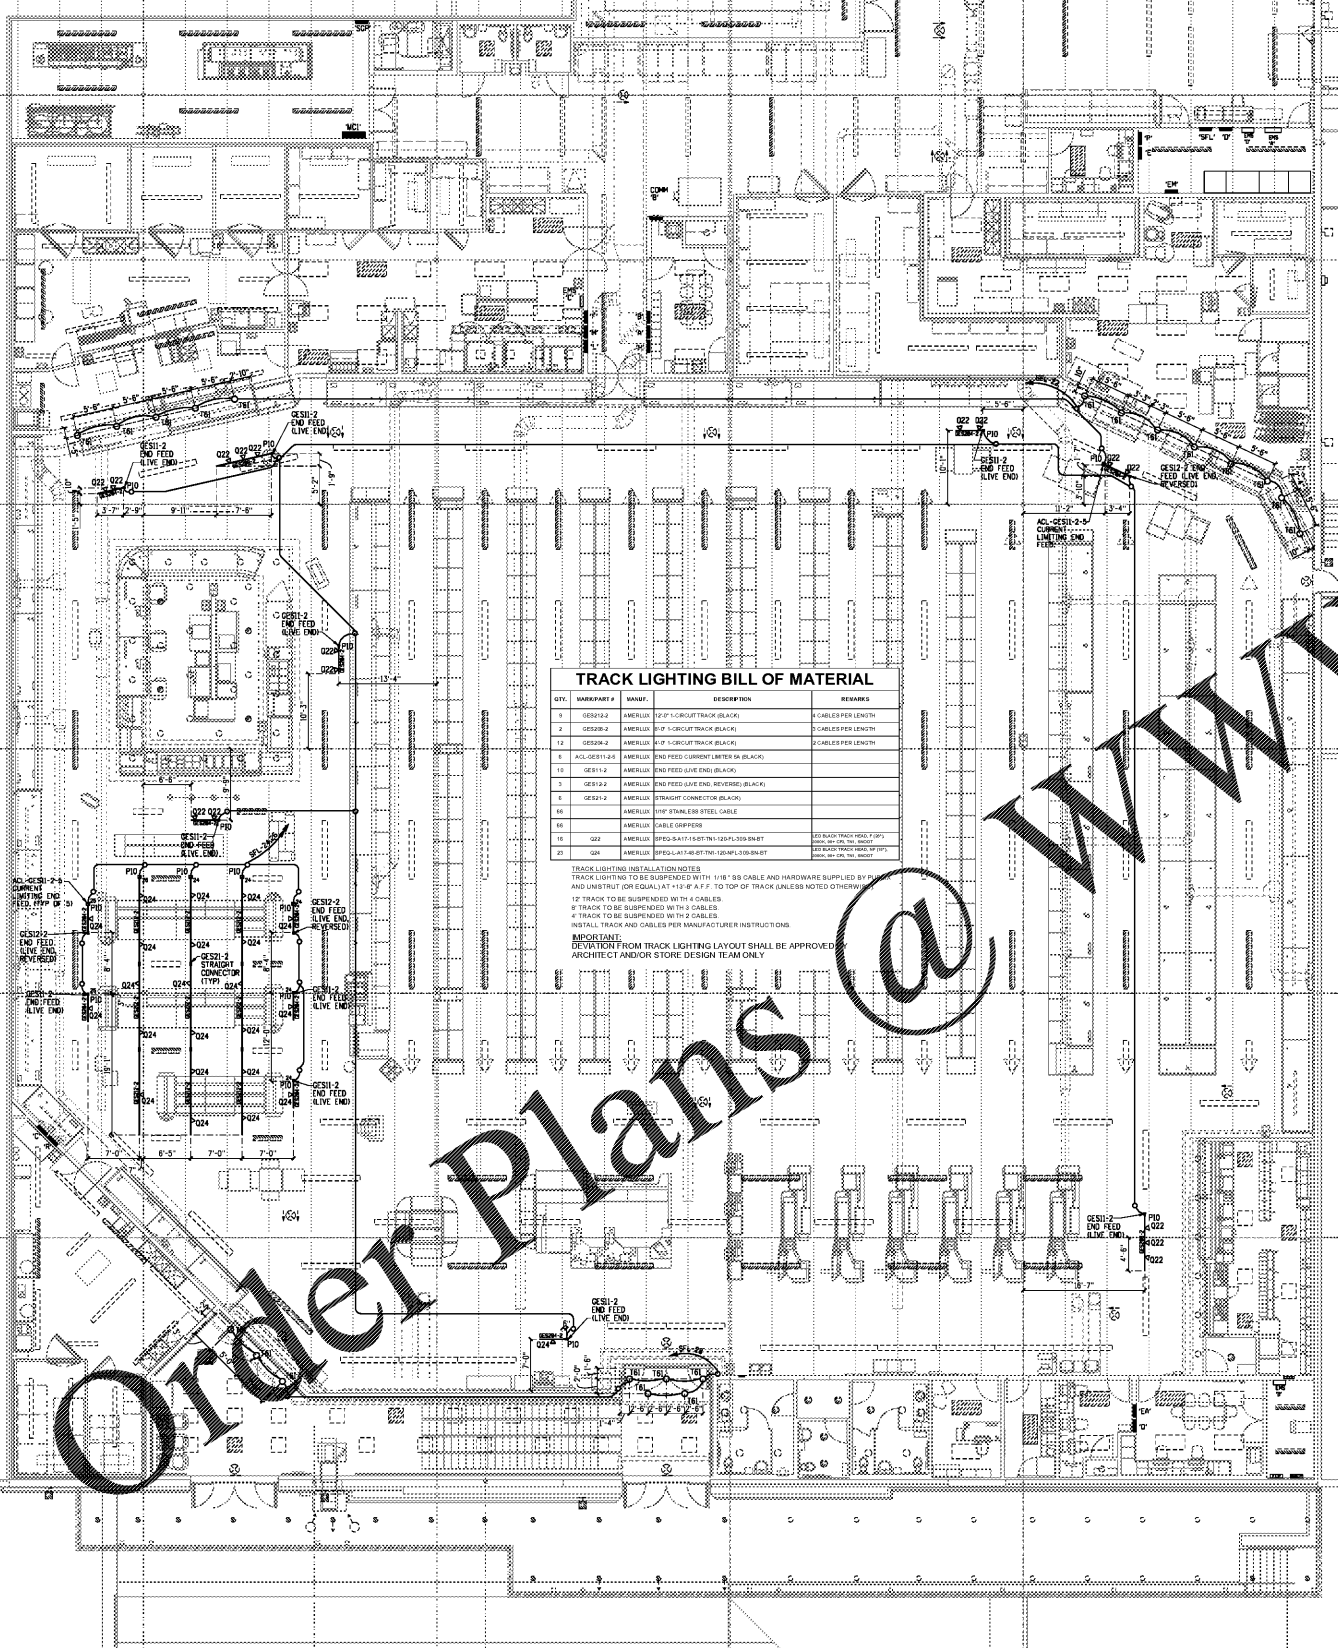

TRACK LIGHTING BILL OF MATERIAL

QTY.	MARKETPART #	MARKET	DESCRIPTION	REMARKS
1	Q23-1	ARELLUX	12" U-CURVE TRACK BLACK	SCALES PER LENGTH
2	Q23-2	ARELLUX	12" U-CURVE TRACK BLACK	SCALES PER LENGTH
14	Q23-3	ARELLUX	12" U-CURVE TRACK BLACK	SCALES PER LENGTH
1	ACJ-Q23-1-1	ARELLUX	END FEED CURRENT LIMITER IN BLACK	
10	Q23-12	ARELLUX	END FEED JUNE END BLACK	
1	Q23-13	ARELLUX	END FEED JUNE END BLACK/BLACK	
1	Q23-14	ARELLUX	STRAIGHT CONNECTOR BLACK	
10	Q23-15	ARELLUX	1/2" STAINLESS STEEL CABLE	
10	Q23-16	ARELLUX	CABLE JOINTS	
10	Q23-17	ARELLUX	1/2" STAINLESS STEEL CABLE	
21	Q23-18	ARELLUX	1/2" STAINLESS STEEL CABLE	

TRACK LIGHTING INSTALLATION NOTES:
 TRACK LIGHTING TO BE SUSPENDED WITH 1/2" STAINLESS STEEL CABLE AND HARDWARE SUPPLIED BY ARELLUX.
 12" TRACK TO BE SUSPENDED WITH 4 CABLES
 12" TRACK TO BE SUSPENDED WITH 3 CABLES
 4" TRACK TO BE SUSPENDED WITH 2 CABLES
 INSTALL TRACK AND CABLES PER MANUFACTURER'S INSTRUCTIONS.
 APPROVAL FROM TRACK LIGHTING LAYOUT SHALL BE APPROVED BY ARCHITECT AND/OR STORE DESIGN TEAM ONLY.

SCALE = 1/8" = 1'-0"
APOLLO ENGINEERING, LLC
 CONSULTING ENGINEERS
 6544 U.S. Hwy 41 North, Suite 9000, Apollo Beach, FL 33578
 Phone: 813.938.8493 / Fax: 813.938.8495
 404-471-3133
 Copyright 2020 - All rights reserved.