
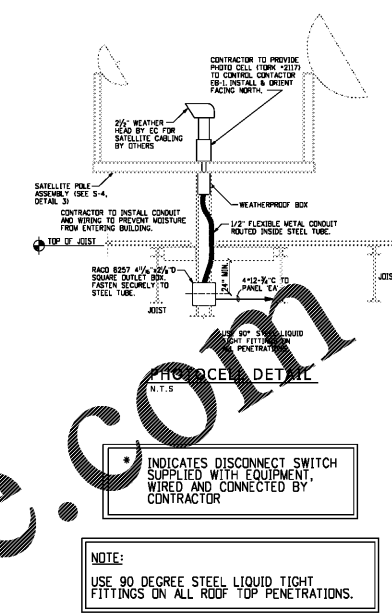


Order Plans @ www.LDILine.com

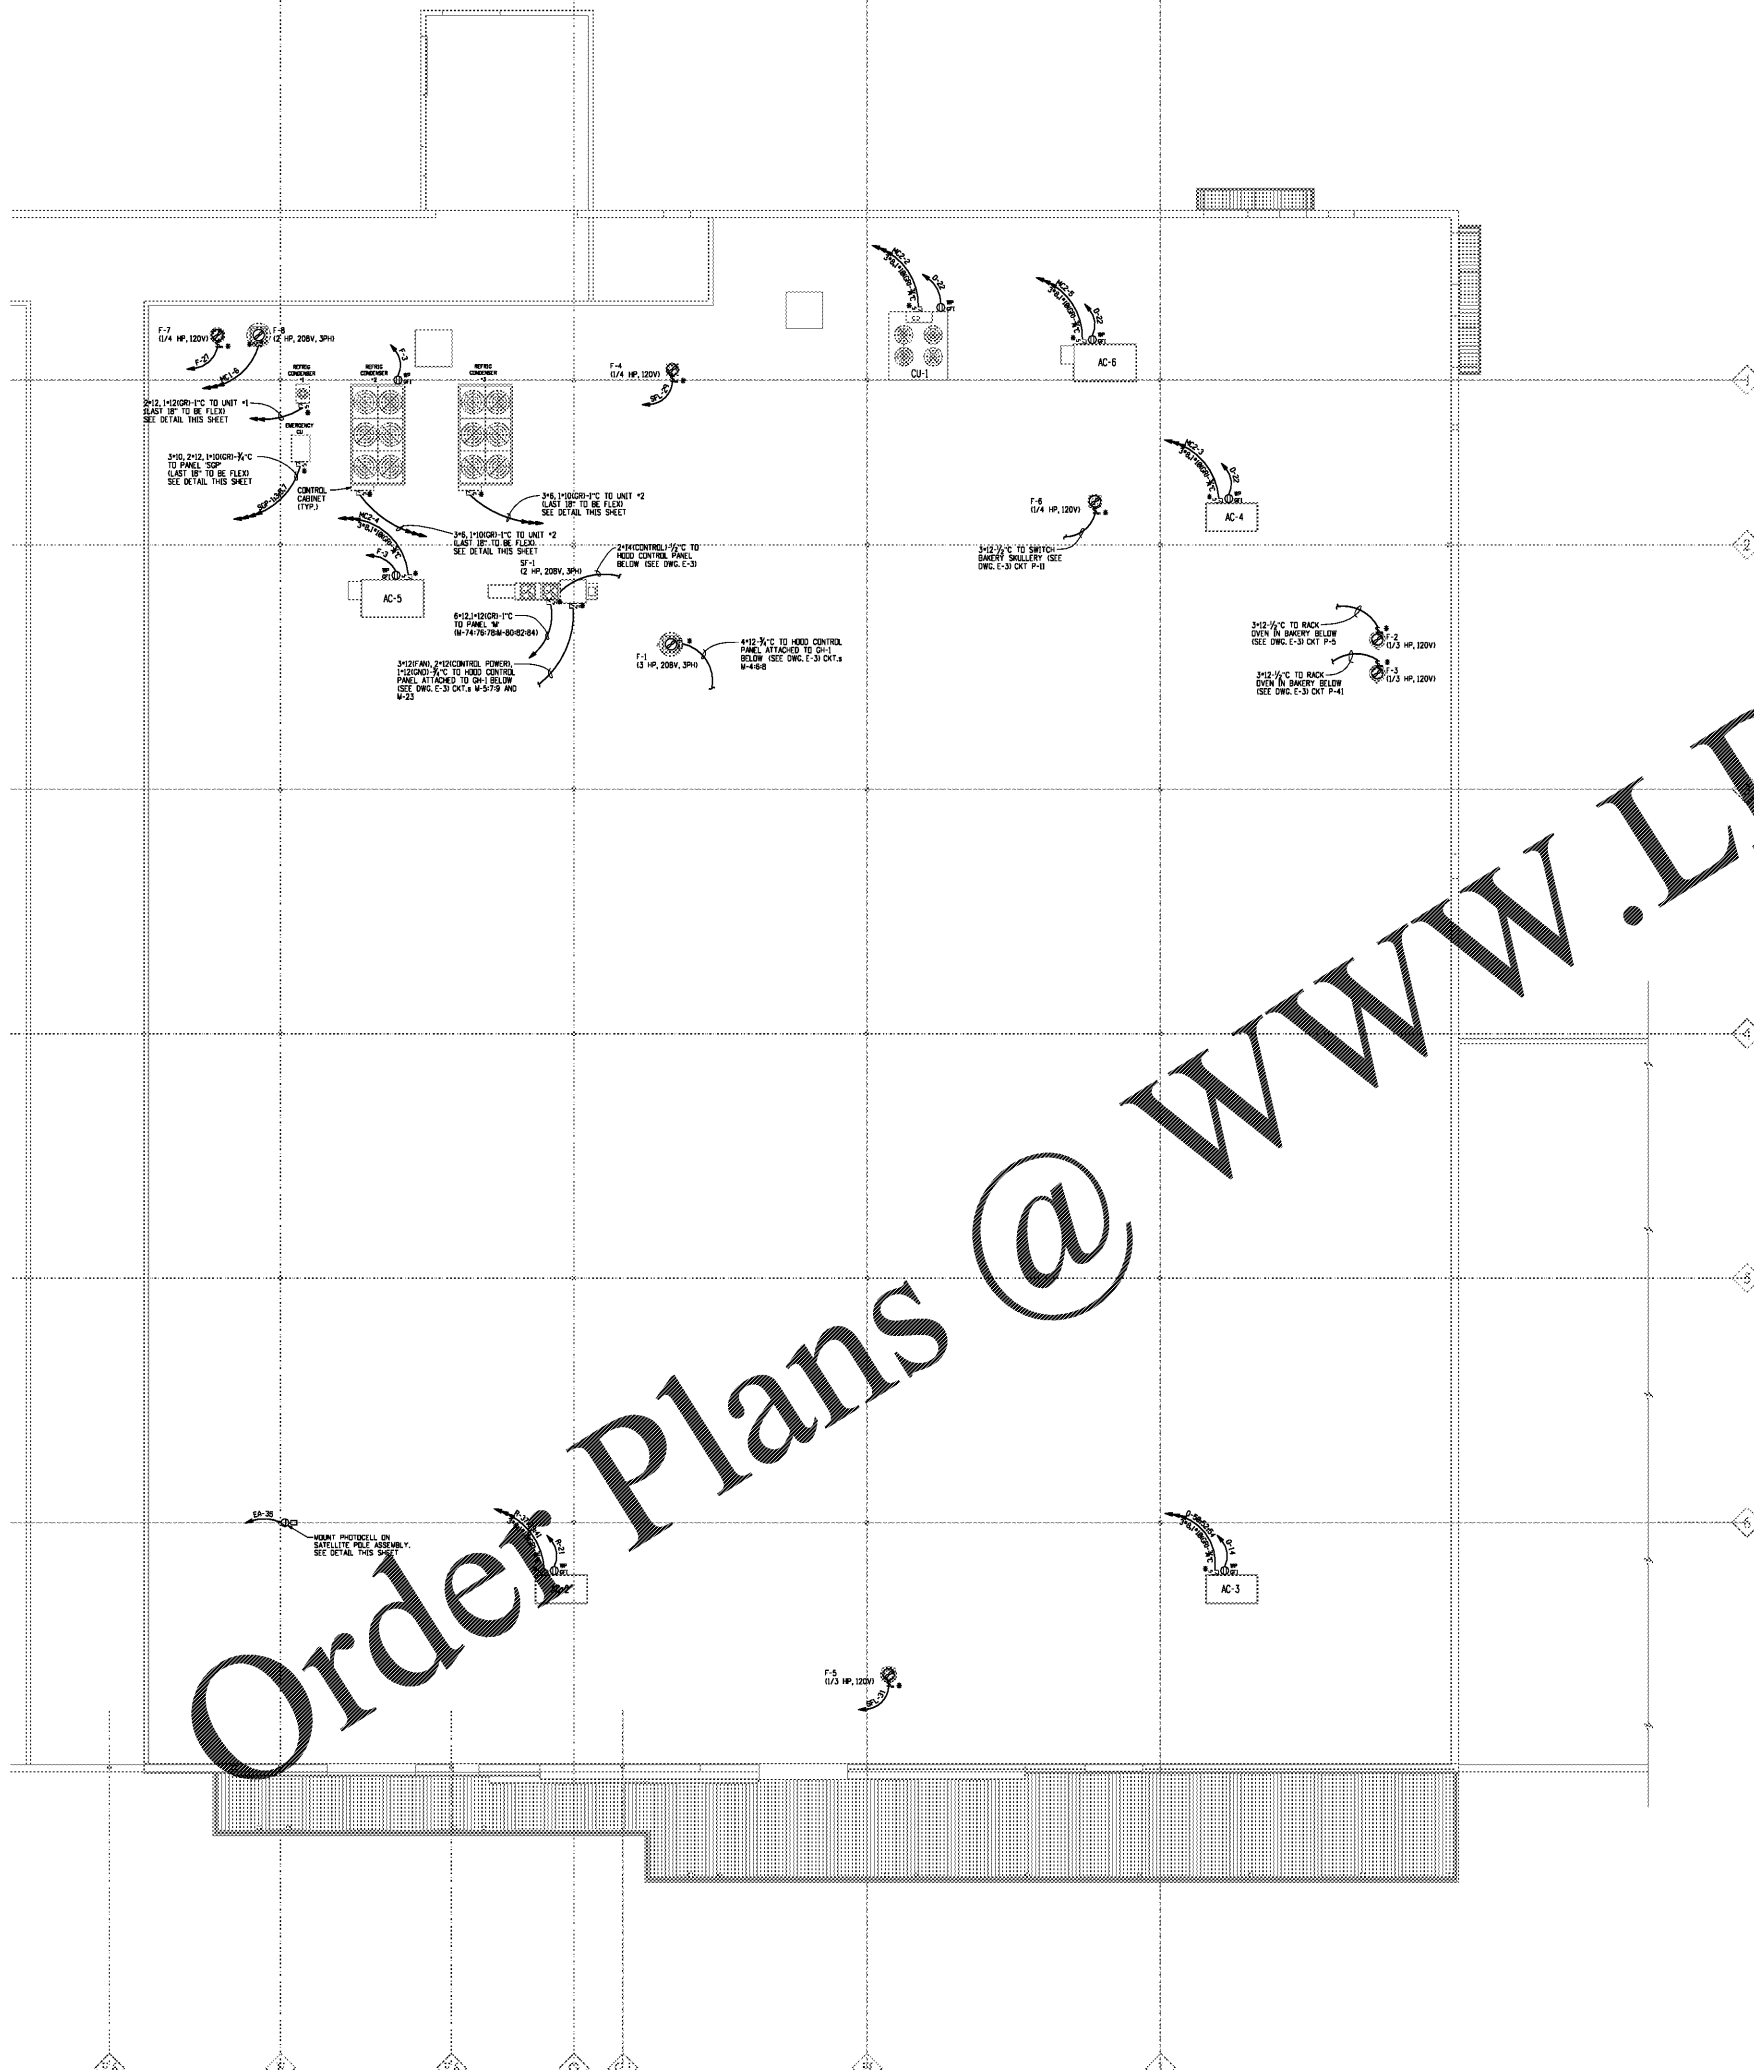

NOTE:
USE 90 DEGREE STEEL LIQUID TIGHT FITTINGS ON ALL ROOF TOP PENETRATIONS.

INDICATES DISCONNECT SWITCH SUPPLIED WITH EQUIPMENT WIRED AND CONNECTED BY CONTRACTOR

SCALE = 1/8" = 1'-0"
APOLLO ENGINEERING, LLC
 CONSULTING ENGINEERS
 8544 U.S. Hwy 61 North, Suite 9000, Apollo Beach, FL 33708
 Phone: 813.994.5900 / Fax: 813.994.5905
 604-913833
 Copyright 2010 - All rights reserved.

ELECTRICAL ROOF PLAN
EAST COBB PUBLIX - #1745
 EAST COBB CROSSING SHOPPING CENTER
 ROSEWELL ROAD
 MARIETTA, GA 30062

RELEASED FOR:
 BID _____
 PERMIT 07/16/20
 CONSTR. _____

REVISIONS:

HAROLD A. SCOTT
 GEORGIA P.E. #527308

E-5

Issue Date: 04-01-20
 Project No.: 220026

FISHER AND ASSOCIATES, LLC.
 ARCHITECTS
 PLANNERS
 INTERIOR DESIGNERS
 605 BELLEAIR RD. CLEWISTON, FL 33704 727.446.4400

Publix
 SUPER MARKETS

PUBLIC PROTOTYPE
 BASIS OF DESIGN
20M
 EXPANDED
 RECEIVED: 08.14.18

CORPORATE OFFICES, FACILITIES DESIGN
 BOX 407, LAKELAND, FL 33802
 (888) 680-3295
 PHYSICAL ADDRESS:
 3300 AIRPORT RD., LAKELAND, FL 33811

THIS DRAWING IS THE PROPERTY OF FISHER AND ASSOCIATES, LLC. IT IS TO BE USED ONLY FOR THE PROJECT AND SITE SPECIFICALLY IDENTIFIED HEREON. IT IS NOT TO BE REPRODUCED OR TRANSMITTED IN ANY FORM OR BY ANY MEANS, ELECTRONIC OR MECHANICAL, INCLUDING PHOTOCOPYING, RECORDING, OR BY ANY INFORMATION STORAGE AND RETRIEVAL SYSTEM, WITHOUT THE WRITTEN PERMISSION OF FISHER AND ASSOCIATES, LLC.