



- SHEET NOTES:**
- REFER TO SHEET C-001 FOR GENERAL CIVIL NOTES, LEGENDS, AND ABBREVIATIONS.
  - THIS SHEET IS PART OF A MULTI-SHEET SET OF CONSTRUCTION PLANS AND SHALL BE READ WITH THE FULL SET TO BEST ENSURE PROPER INTERPRETATION.
  - SEE DETAIL A3/C-504 FOR PIPE BEDDING DETAIL.
  - SEE STRUCTURAL PLANS FOR HANGAR BAY SLAB SLOPE AND GRADE.
  - PROVIDE 1.5" DROP BETWEEN PAVEMENT AND GRASSED SHOULDERS PER DETAIL D/C-503.
  - SPOT ELEVATIONS ALONG CURB ARE TO THE BACK OF CURB.

- KEYNOTES:**
- TYPE "B" CATCH BASIN - DETAIL A1/C-504.
  - ROOF DRAIN CONNECTION - DETAIL A4/C-504.
  - TIE INTO EXISTING STORM SYSTEM.
  - CLEANOUT - DETAIL A1/C-505.
  - MANHOLE - DETAIL C2/C-504.
  - BIORETENTION SWALE - DETAIL C1/C-504.
  - CONNECTION TO STORMTECH MANIFOLD.
  - 3 ROWS, 22 CHAMBERS, STORMTECH MC-3500 - DETAIL A1/C-506.
  - ADJUST EXISTING SANITARY SEWER MANHOLE TOP TO MATCH PROPOSED GRADE. SANITARY SEWER MANHOLES ARE BEING INSTALLED IN THE NORTH AREA TERMINAL PROJECT. MANHOLE TOP ELEVATION IS UNKNOWN.



- LEGEND:**
- BIOSOILS

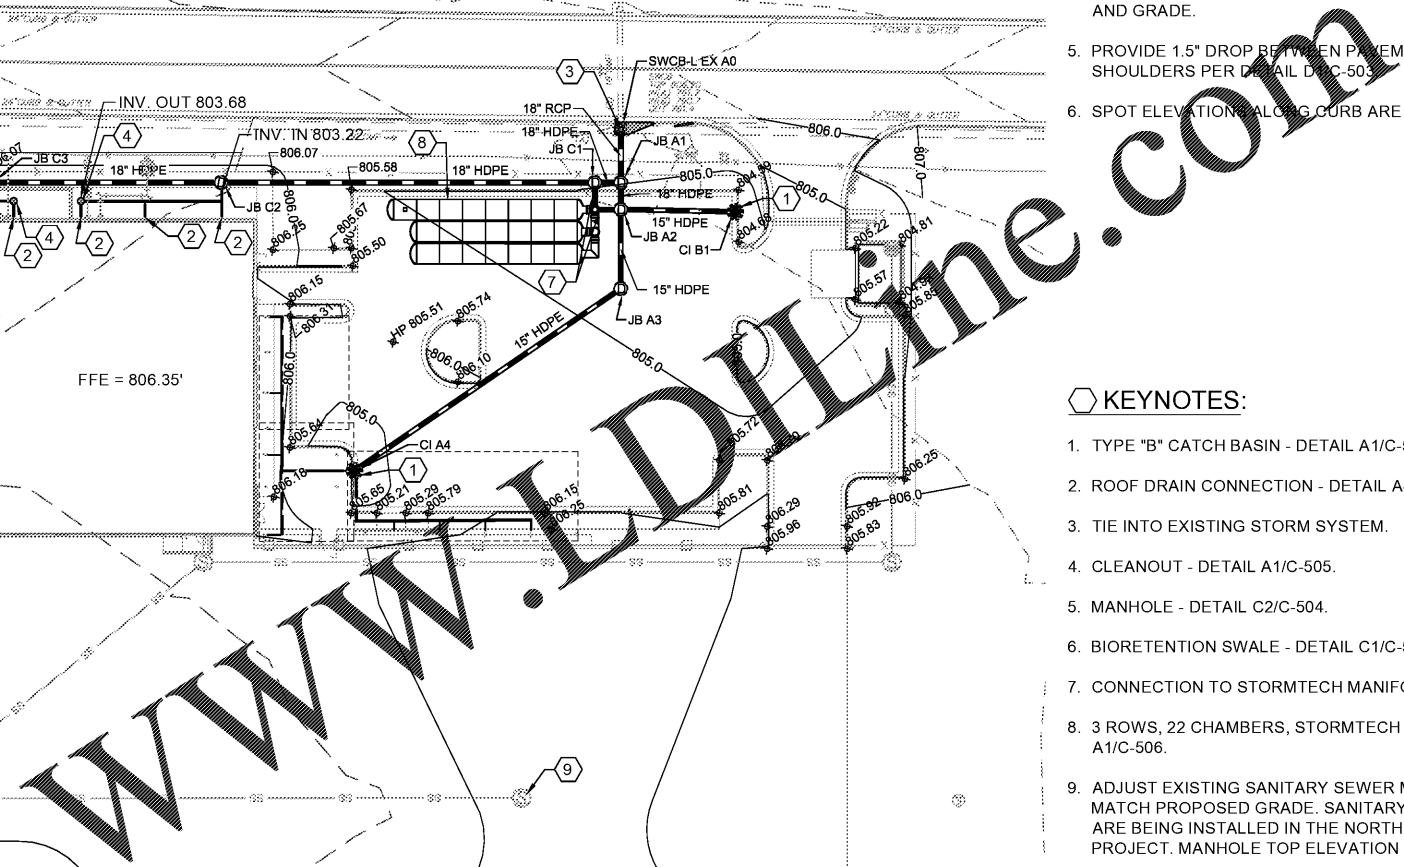

*Order Plans @*

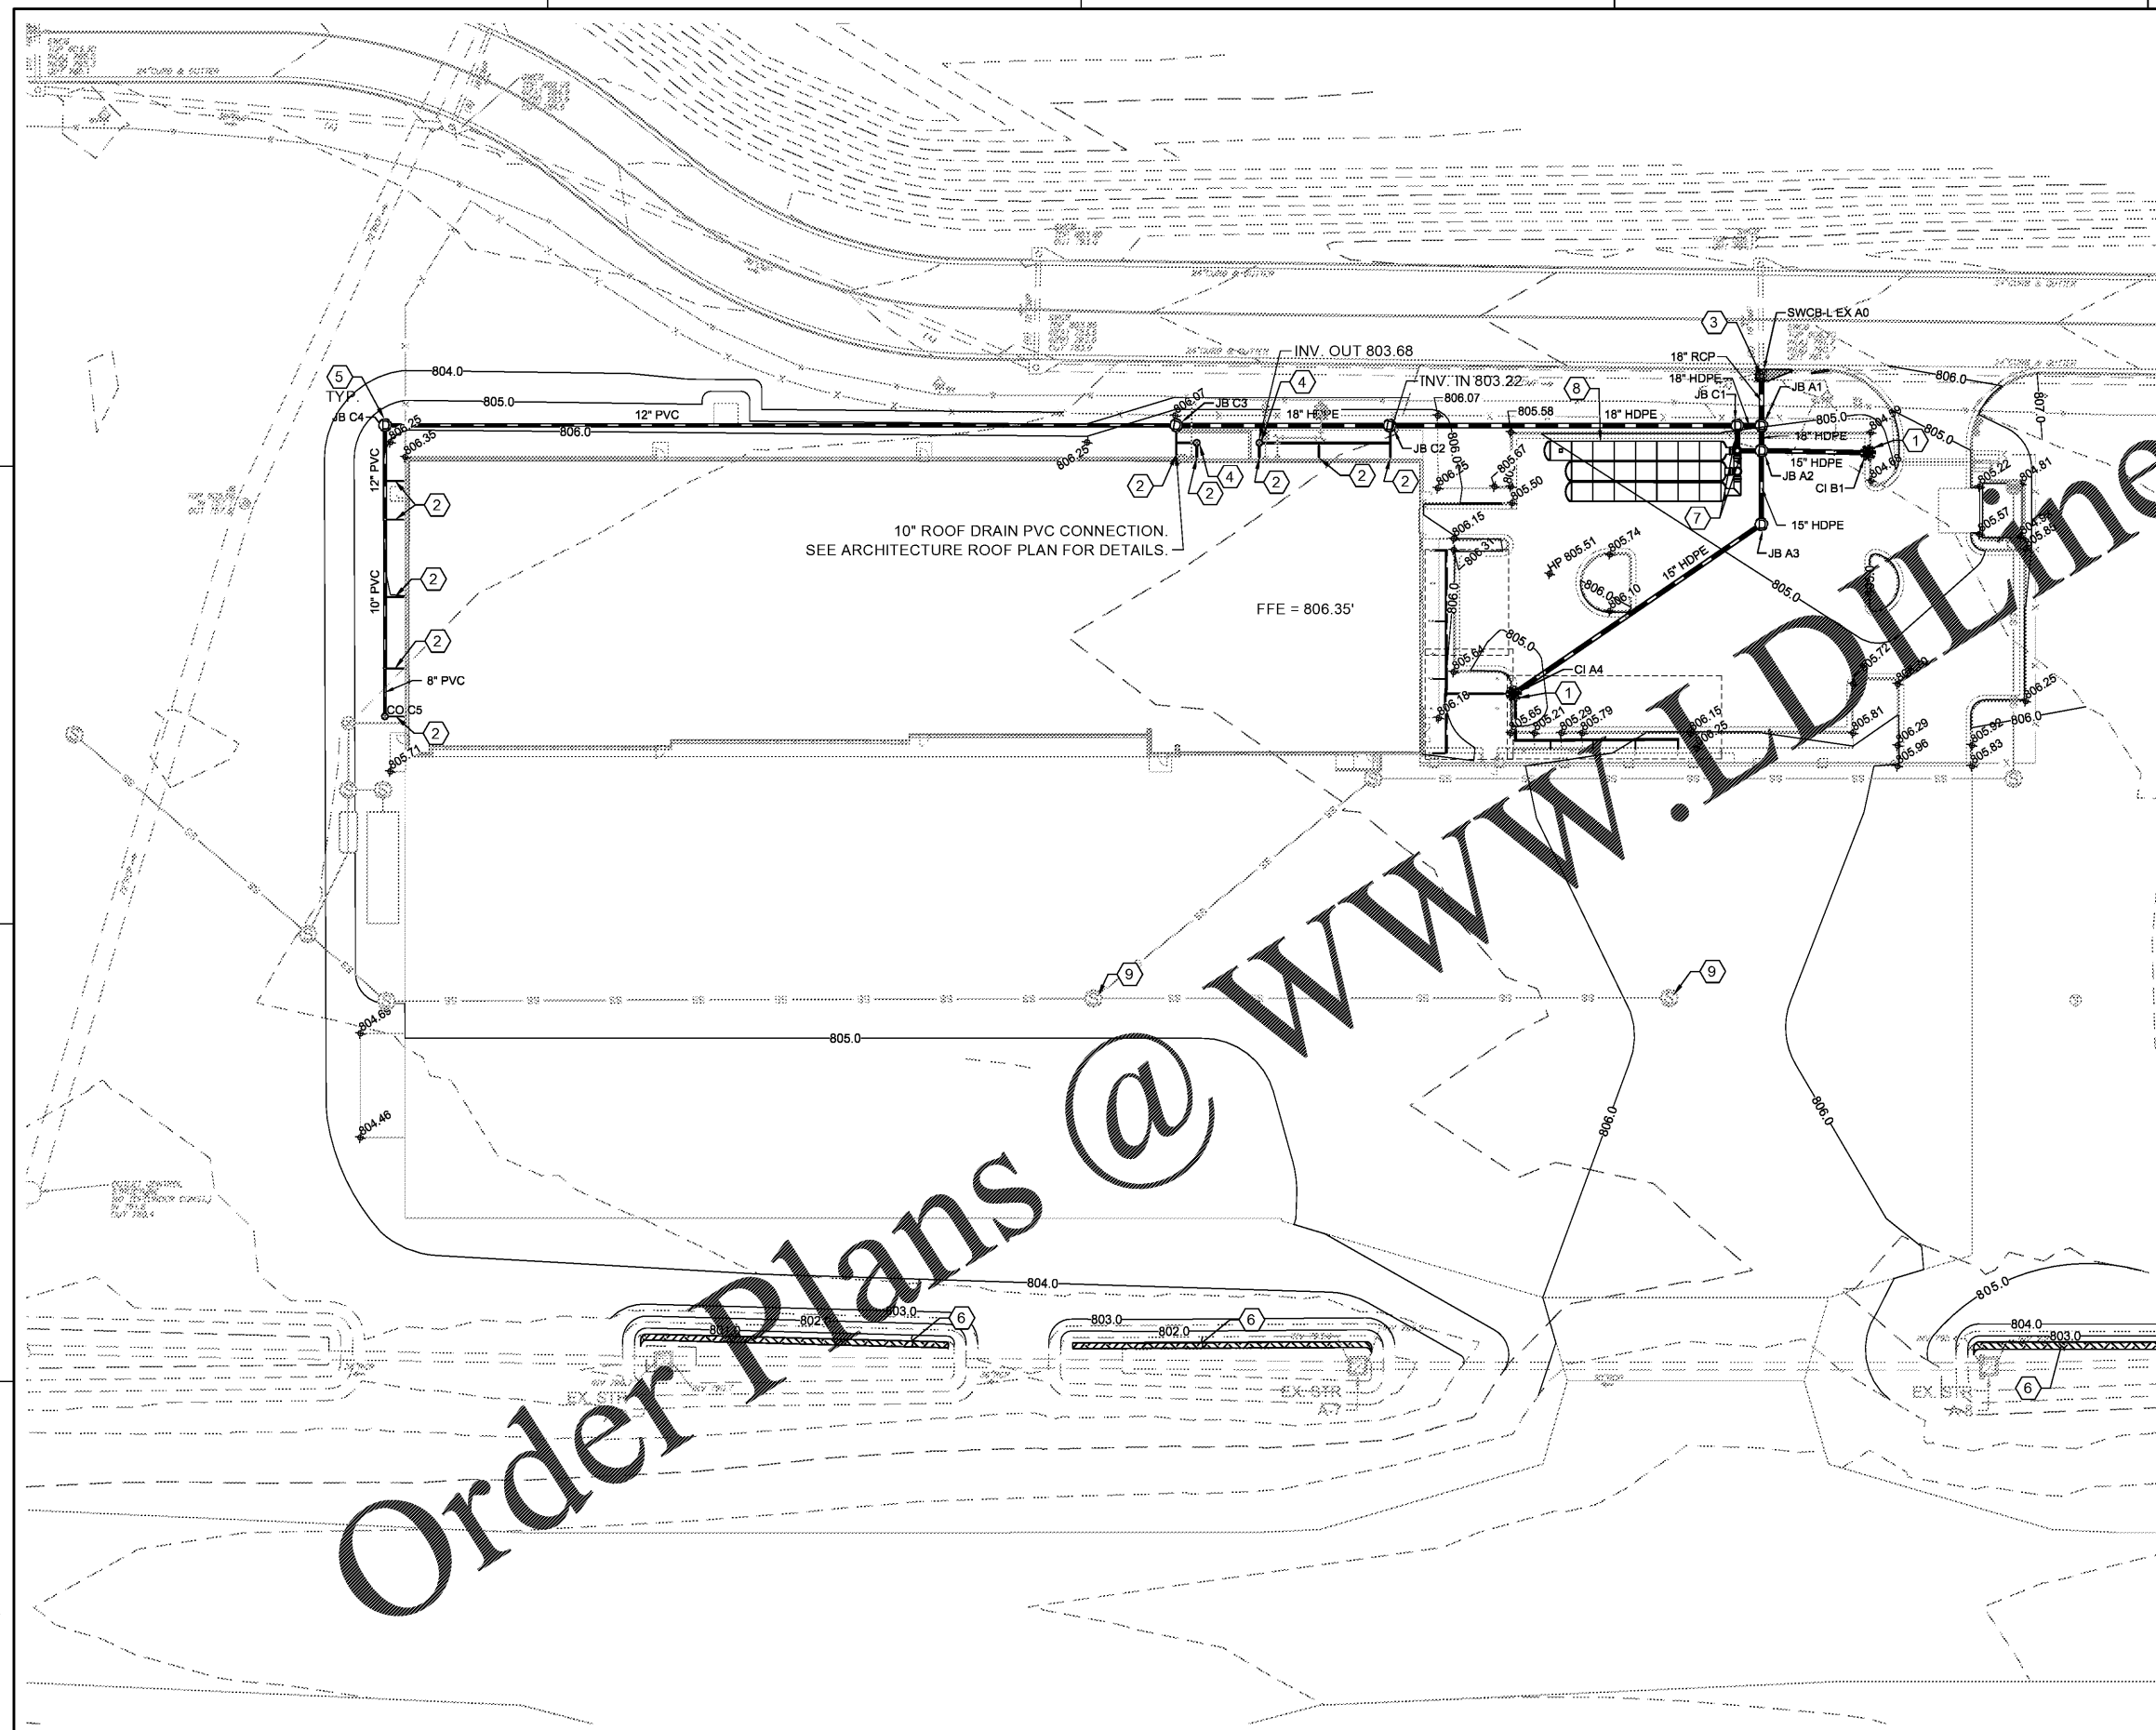

  **A1 GRADING AND DRAINAGE PLAN**  
SCALE: 1" = 30'



MARK	DESCRIPTION	DATE

DESIGNED BY: AS	CHECKED BY: AS
DRAWN BY: AS	SUBMITTED BY: EA
ISSUED FOR CONSTRUCTION: DD/MM/YYYY	

OWNERS REPRESENTATIVE:  
GENERAL CONTRACTOR:  
OWNER'S REPRESENTATIVE:  
PROJECT NO. & DATE:  
DATE OF REVIEW:

**POND & COMPANY**  
3000 Peachtree Lane, Suite 600  
Atlanta, Georgia 30308  
Phone: (404) 253-7240  
Fax: (404) 253-7241  
E-Mail: info@pond.com  
LIC. NO. 11100514

**NORFOLK SOUTHERN CORP.**  
1200 PEACHTREE STREET, NE  
ATLANTA, GEORGIA 30309

CORPORATE AIRCRAFT HANGAR FOR NORFOLK SOUTHERN CORPORATION  
FULTON COUNTY AIRPORT - BROWN FIELD (F71)  
3927 AMTOWN CIRCLE, SUITE 200  
ATLANTA, GEORGIA 30308

**GRADING AND DRAINAGE PLAN**

SHEET ID  
**CG101**