



7/10/2020 3:01:52 AM BIM 360//1190557 - Pegasus/1190557_Pegasus_NS_Arch_CENTAL_v19_R3.rvt

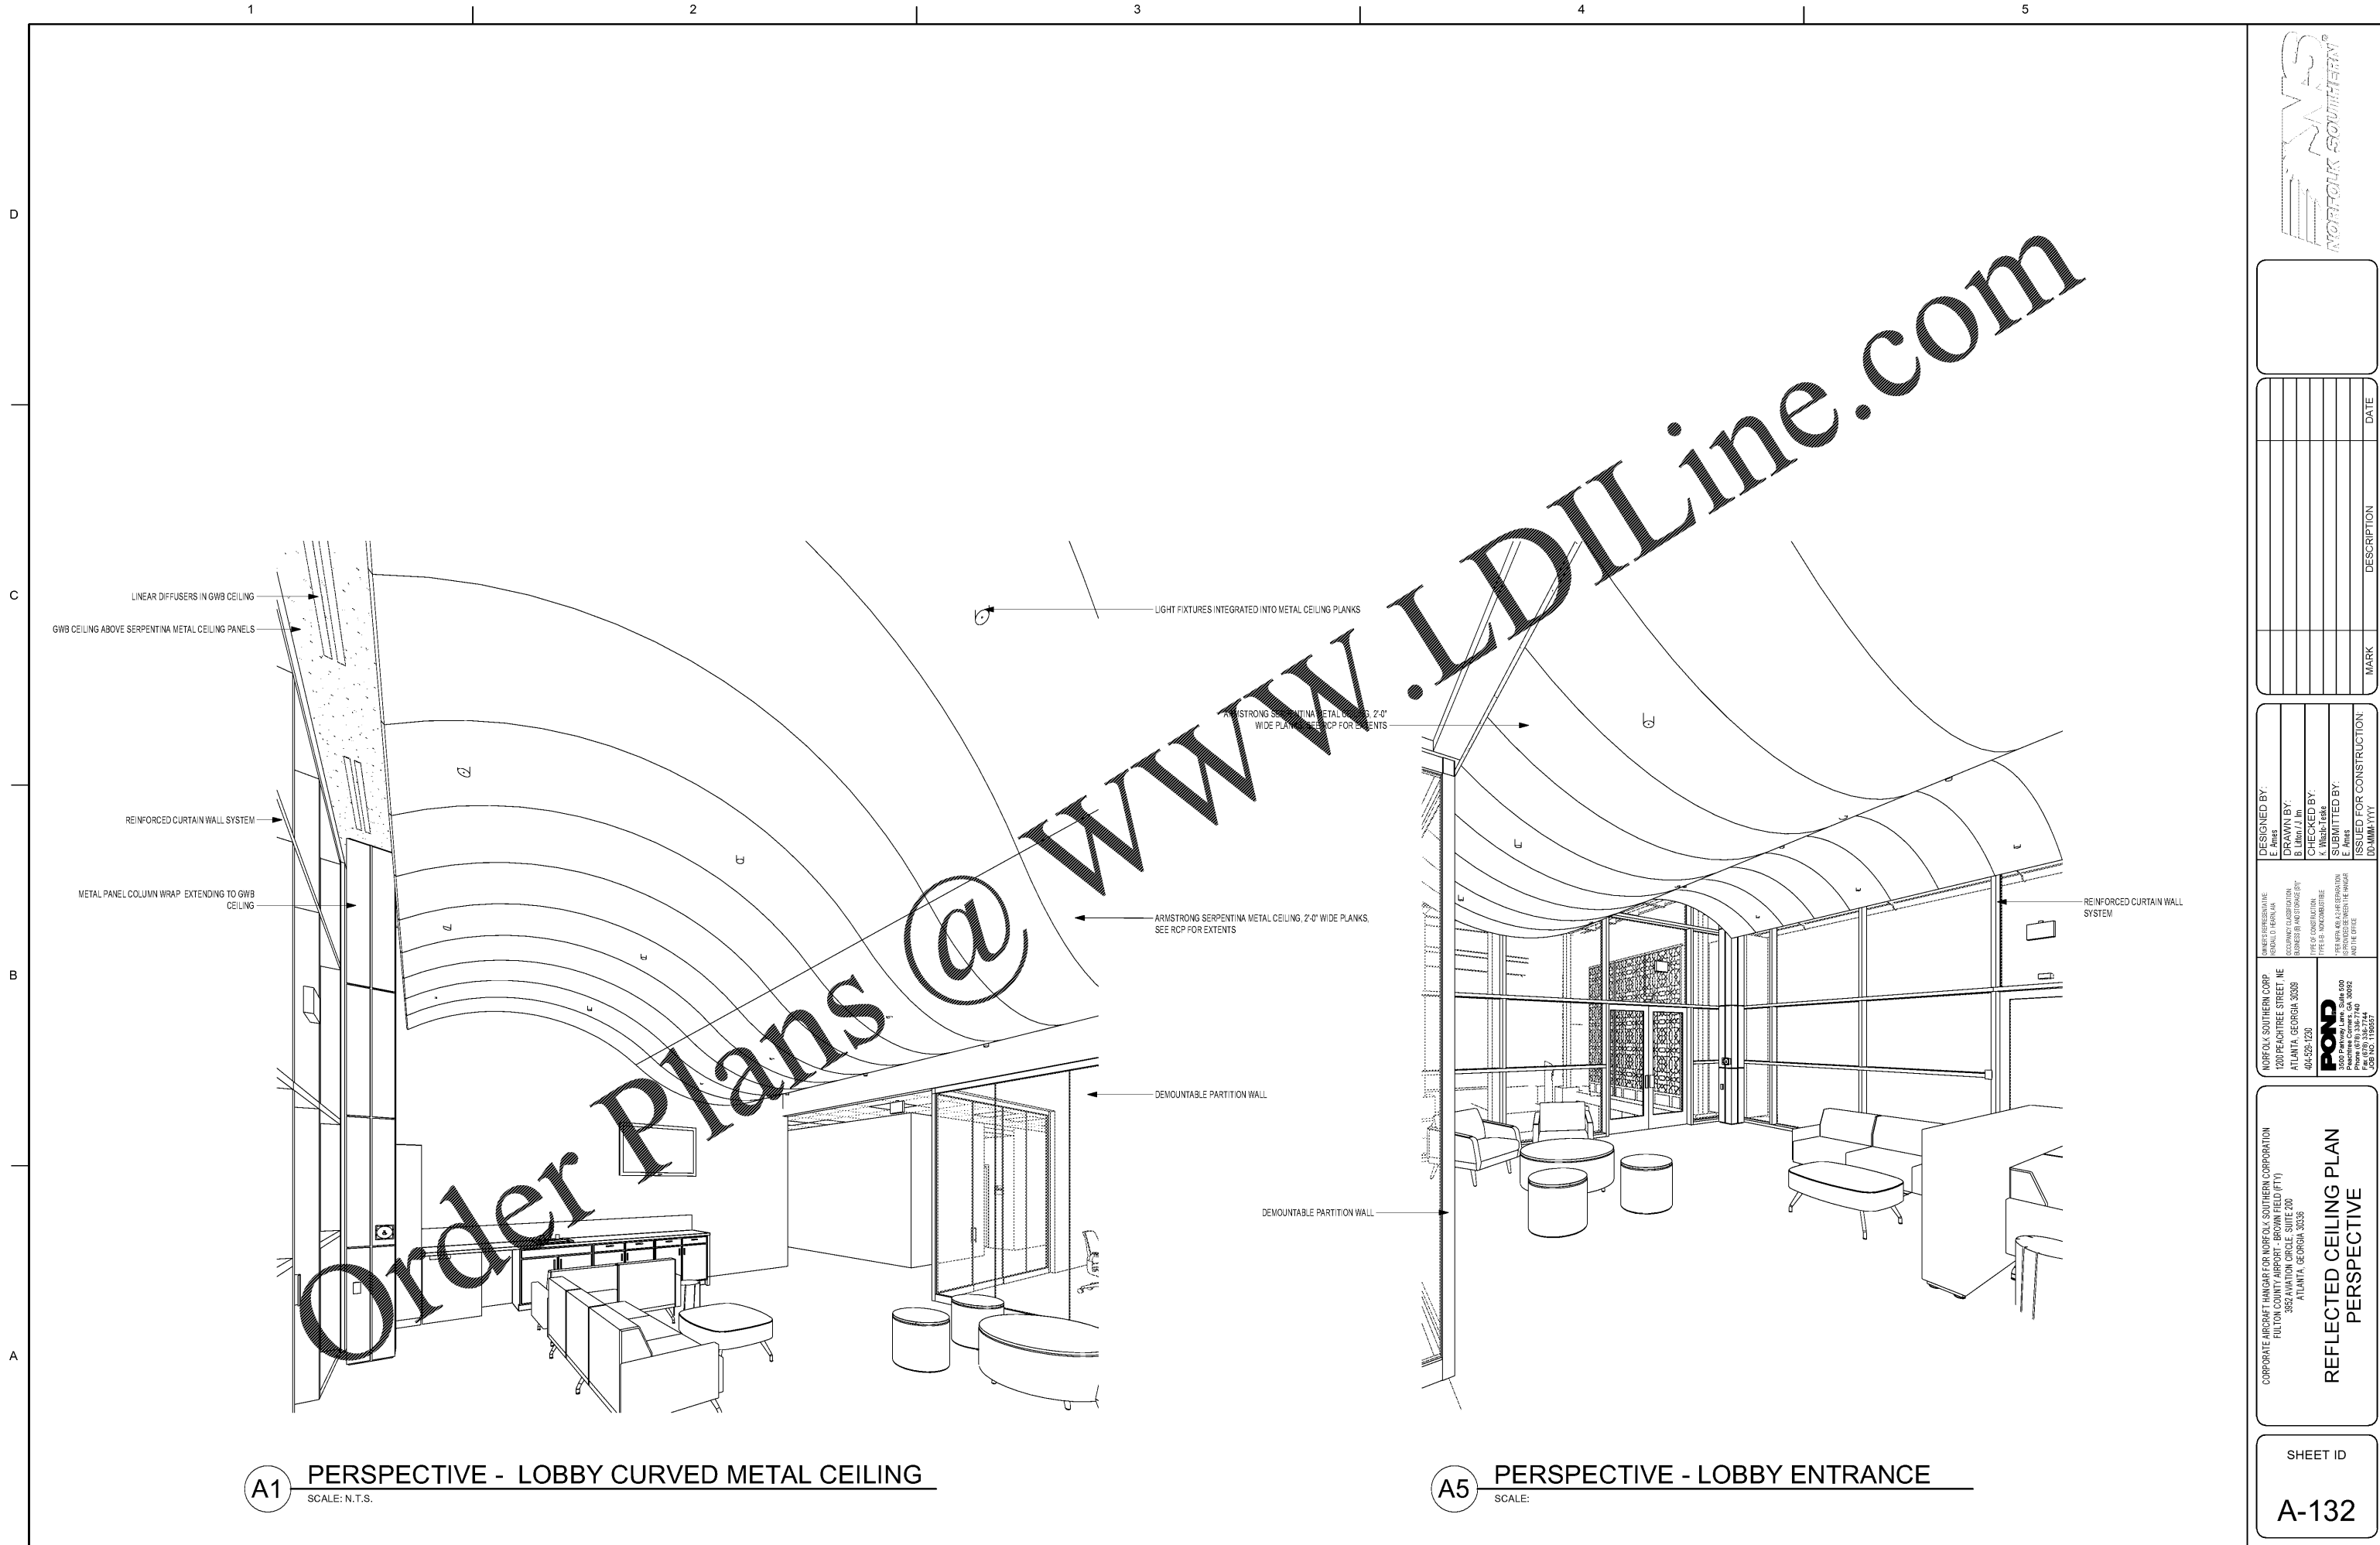

A1 PERSPECTIVE - LOBBY CURVED METAL CEILING
SCALE: N.T.S.

A5 PERSPECTIVE - LOBBY ENTRANCE
SCALE:

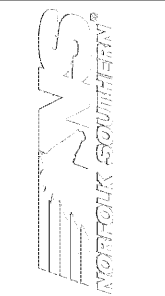

MARK	DESCRIPTION	DATE

DESIGNED BY:
ARCHITECT
B. LINDA L. J. N.
CHECKED BY:
K. W. B. T. 1/8/18
SUBMITTED BY:
E. A. H. 1/8/18
ISSUED FOR CONSTRUCTION:
DC-MM-YY

NORFOLK SOUTHERN CORP
1200 PEACHTREE STREET, NE
ATLANTA, GEORGIA 30309
404-529-1230
POND
3002 Peachtree Lane, Suite 200
Atlanta, Georgia 30309
Phone (478) 338-7740
JOB NO. 1190557

CORPORATE AIRCRAFT HANGAR FOR NORFOLK SOUTHERN CORPORATION
FULTON COUNTY AIRPORT - BROWN FIELD (FTY)
3827 AVIATION CIRCLE, SUITE 200
ATLANTA, GEORGIA 30338
**REFLECTED CEILING PLAN
PERSPECTIVE**

SHEET ID
A-132