


7/10/2020 3:02:56 AM BIM 360//1190557 - Pegasus//1190557_Pegasus_NS_Arch_CENTRAL_v19_R3.rvt

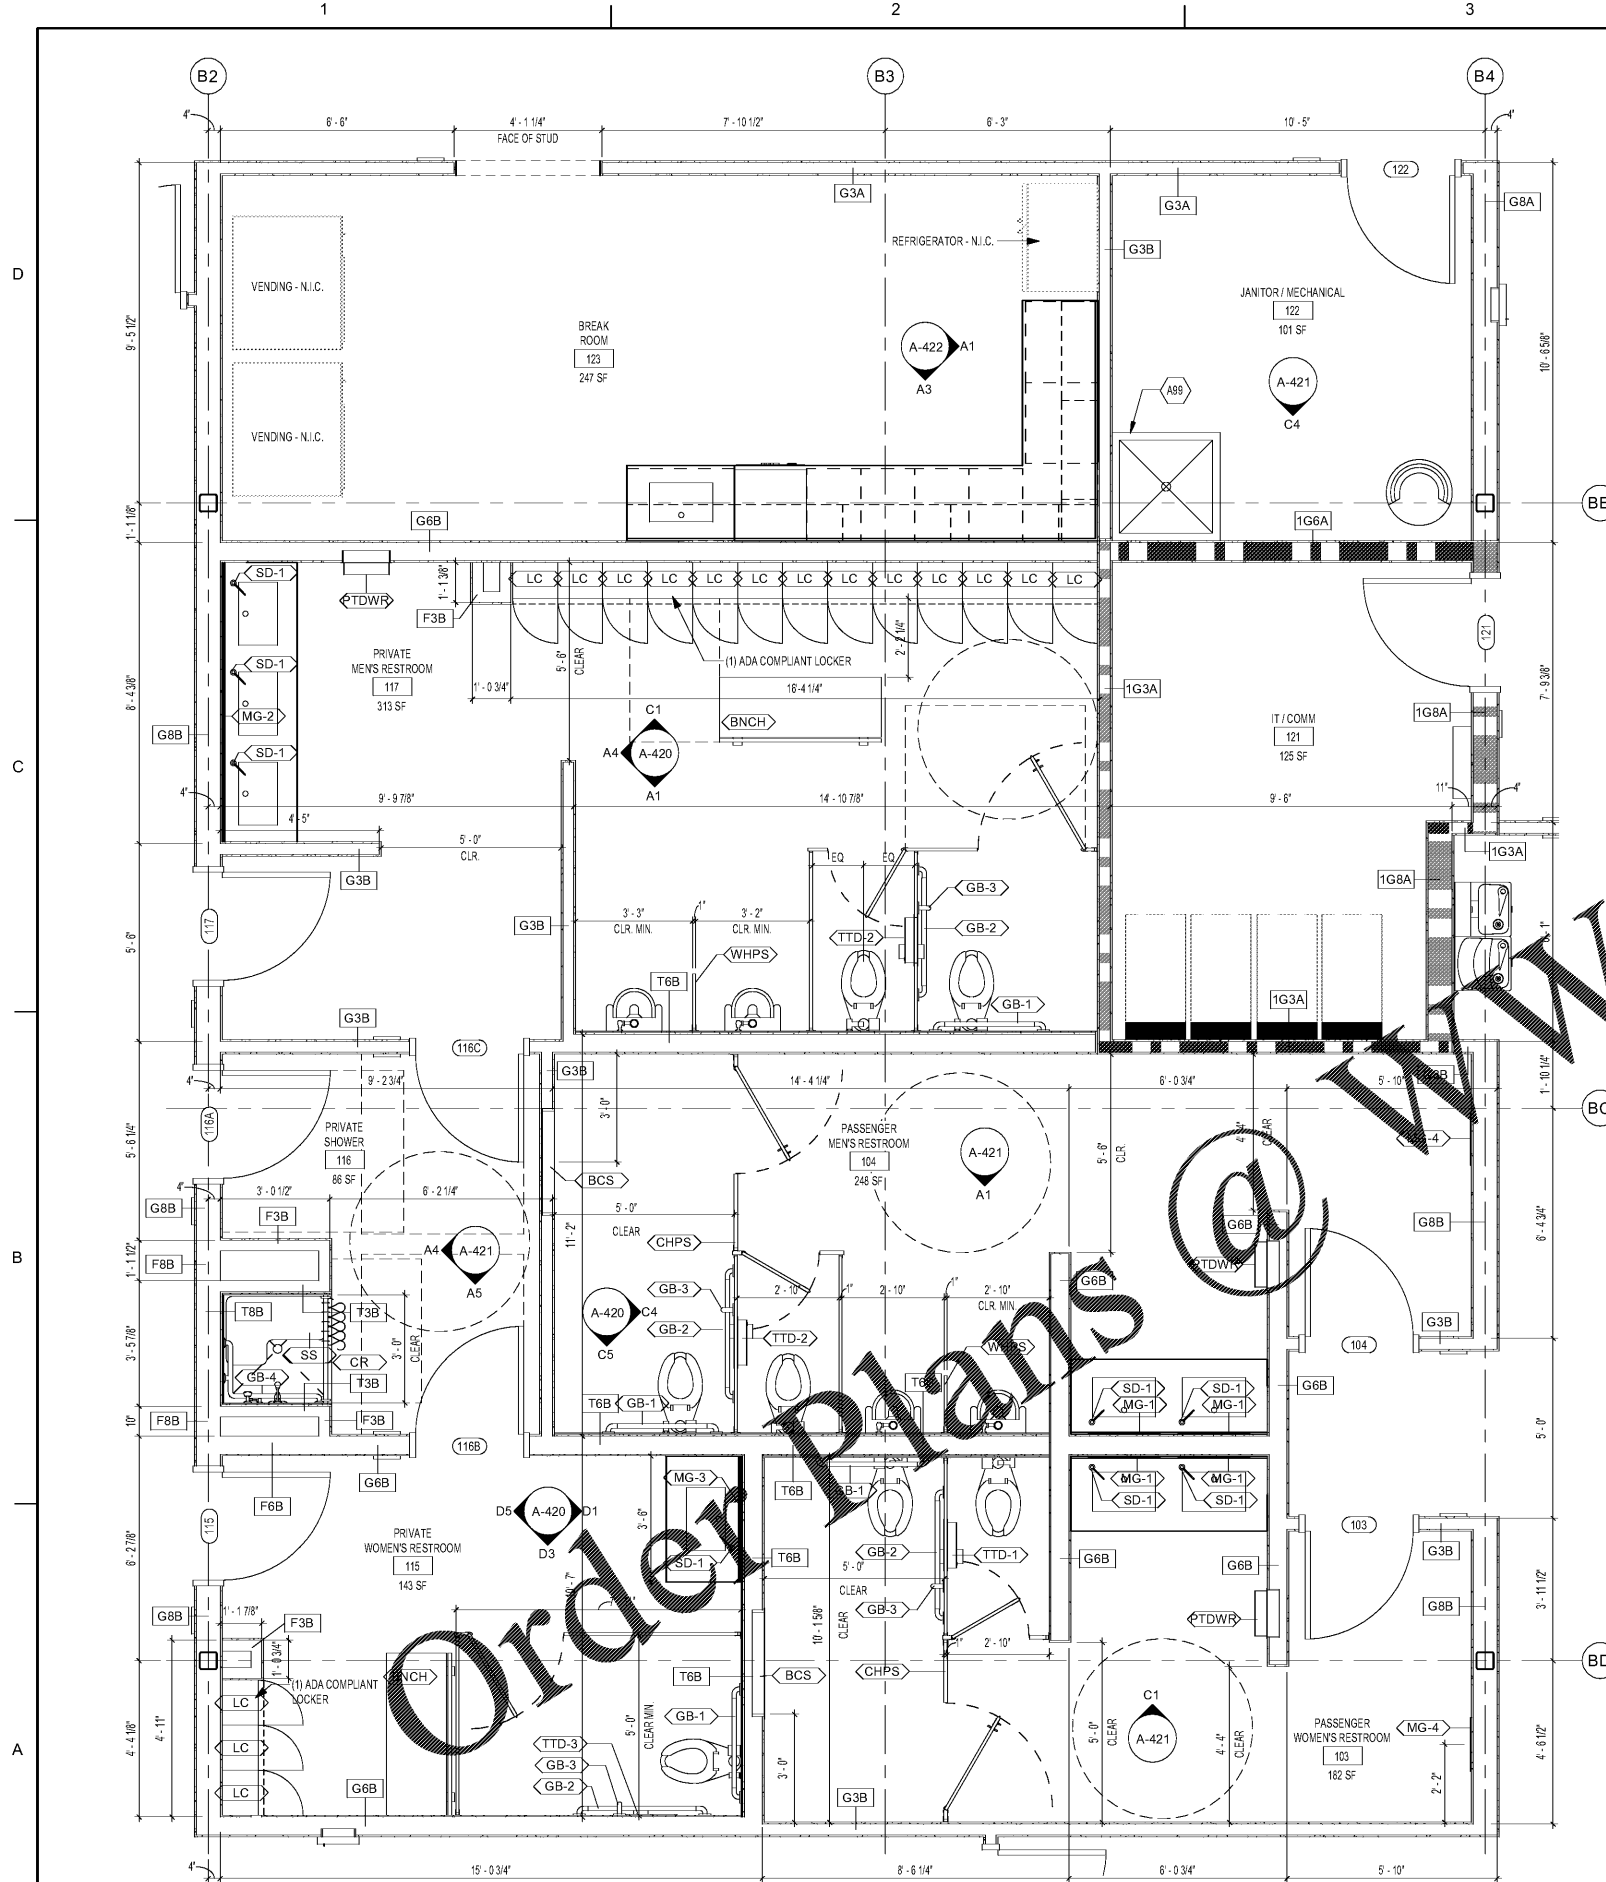

A1 ENLARGED PLAN RESTROOMS
SCALE: 3/8" = 1'-0"



ENLARGED FLOOR PLAN NOTES:

- SEE SHEET A-001 FOR GENERAL NOTES.
- SEE SHEET A-005 & A-006 FOR PARTITION TYPES & DETAILS.
- SEE STRUCTURAL, MECHANICAL, PLUMBING, FIRE PROTECTION, ELECTRICAL & INTERIOR DRAWINGS FOR ADDITIONAL INFORMATION.
- PARTITIONS INDICATED WITH [Symbol]. SEE SHEET A-005 & A-006 FOR PARTITION TYPES.
- DOORS INDICATED WITH [Symbol]. SEE SHEET A-601 FOR DOOR SCHEDULES & TYPES.
- WINDOWS INDICATED WITH [Symbol]. SEE SHEET A-604 FOR WINDOW TYPES.
- SEE SHEET A-003 & A-004 FOR TYPICAL MOUNTING HEIGHTS, LOCATIONS & DETAILS.

KEYNOTES:
(KEYNOTE NUMBERS ARE UNIFORM ACROSS ALL SHEETS AND SOME MAY NOT BE REQUIRED ON THIS SHEET)

KEYNOTE #	KEYNOTE DESCRIPTION
A99	MOP SINK

TAG	DESCRIPTION	MANUFACTURER	MODEL #	FINISH
BCS	BARBER ENGINE STATION	BOBRICK	KB110-SSRE	STAINLESS
BNCH	ADA BENCH	LYON PRODUCTS	ADABK4824	HARDWOOD / PAINTED STEEL - MATCH LOCKER COLOR
CHPS	Ceiling Hung Partition Stall	HINY HIDERS	-	STAINLESS GRIP-EX
CR	SHOWER CURTAIN ROD	BRADLEY CORP.	9531	STAINLESS
GB-1	36" ADA GRAB BAR	BRADLEY CORP.	812-7	STAINLESS
GB-2	18" ADA GRAB BAR PARTITION MOUNT	BRADLEY CORP.	812-7	STAINLESS
GB-3	18" ADA VERTICAL GRAB BAR PARTITION MOUNT	BRADLEY CORP.	812-7	STAINLESS
GB-4	24" x 18" ADA GRAB BAR	Bradley Corporation	812-7	STAINLESS
LC	SINGLE UNIT LOCKER 12"D X 15"W X 72"H	SCRANTON PRODUCTS	-	PHENOLIC
MBH	MOP AND BROOM HOLDER	BRADLEY CORP.	9953	STAINLESS
MG-1	FRAMELESS MIRROR 2'-0" X 3'-0"	BRADLEY CORP.	747	
MG-2	FRAMELESS MIRROR 7'-9" X 3'-0"	BRADLEY CORP.	747	
MG-3	FRAMELESS MIRROR 3'-6" X 3'-0"	BRADLEY CORP.	747	
MG-4	FRAMELESS MIRROR 1'-6" X 5'-0"	BRADLEY CORP.	747	STAINLESS
PTDWR	PAPER TOWEL DISPENSER WASTE RECEPTACLE	BRADLEY CORP.	234	STAINLESS
RH	ROBE HOOK	BRADLEY CORP.	9114	STAINLESS
SD-1	SOAP DISPENSER	BRADLEY CORP.	6324	STAINLESS
SS	ADA SHOWER SEAT	BRADLEY CORP.		
TTD-1	PARTITION MOUNT TOILET TISSUE DISPENSER & SAN. NAPKIN	BRADLEY CORP.	5911	STAINLESS
TTD-2	PARTITION MOUNT TOILET TISSUE DISPENSER	BRADLEY CORP.	5921	STAINLESS
TTD-3	RECESSED TOILET TISSUE DISPENSER & SAN. NAPKIN	BRADLEY CORP.	5912	STAINLESS
WHPS	WALL HUNG PRIVACY SCREEN W/ FLOOR LEG	HINY HIDERS	-	STAINLESS GRIP-EX

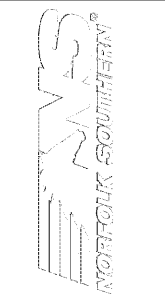 

DATE	DESCRIPTION

DESIGNED BY:
ARCHITECT:
NORFOLK SOUTHERN CORPORATION
1200 PEACHTREE STREET, NE
ATLANTA, GEORGIA 30309
404-529-1230

CHECKED BY:
K. WOODRUM
K. WOODRUM

SUBMITTED BY:
E. AMES
ISSUED FOR CONSTRUCTION:
DE-MMM-YTY

CORPORATE AIRCRAFT HANGAR FOR NORFOLK SOUTHERN CORPORATION
FULTON COUNTY AIRPORT - BROWN FIELD (FTY)
3827 AVIATION CIRCLE, SUITE 200
ATLANTA, GEORGIA 30338

ENLARGED PLAN RESTROOMS

SHEET ID
A-401