




C1 FOAM STORAGE TANKS DETAIL
SCALE: N.T.S.

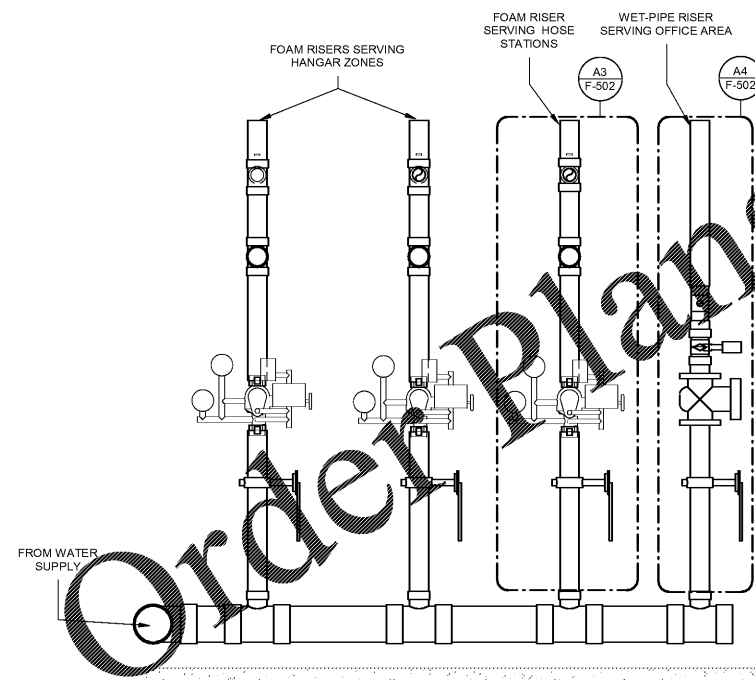

A1 RISER MANIFOLD DETAIL
SCALE: N.T.S.

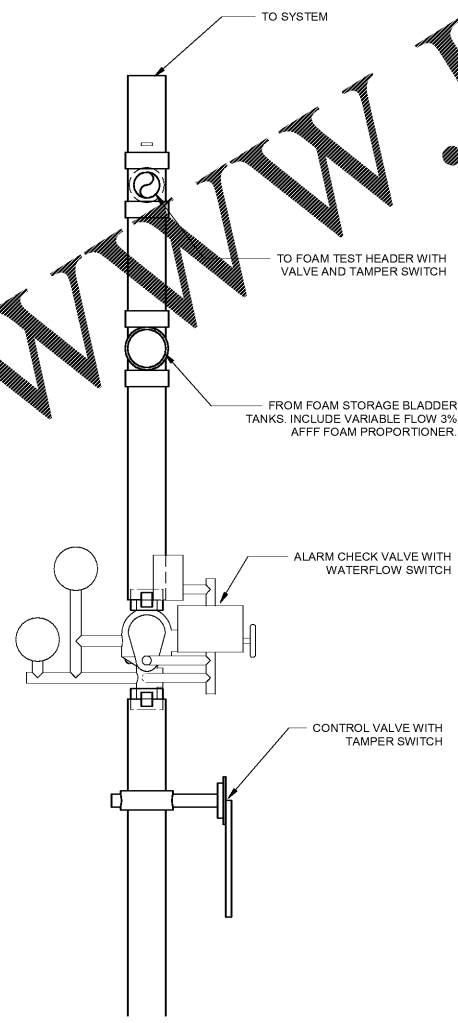

A3 TYPICAL FOAM RISER ASSEMBLY DETAIL
SCALE: N.T.S.

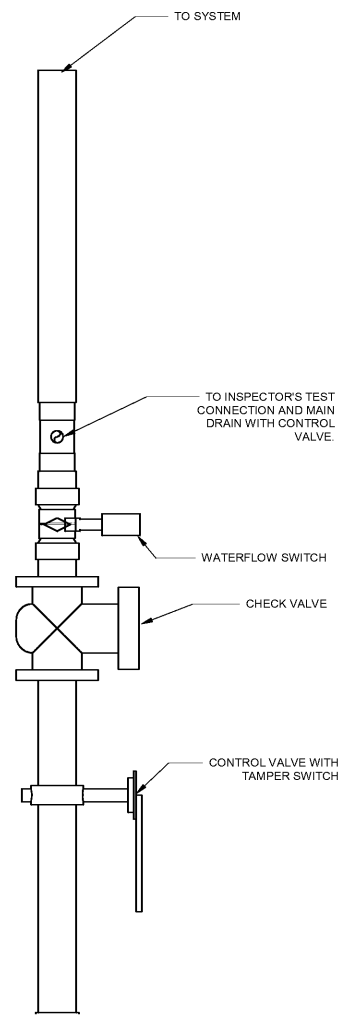

A4 TYPICAL WET-PIPE RISER ASSEMBLY DETAIL
SCALE: N.T.S.

GENERAL NOTES

- SEE SHEET F-001 FOR GENERAL NOTES AND LEGEND.



MARK	DESCRIPTION	DATE

DESIGNED BY: BTH	DRAWN BY: JMS	CHECKED BY: JMS	SUBMITTED BY: JMS	ISSUED FOR CONSTRUCTION: 15/7/2021
---------------------	------------------	--------------------	----------------------	---------------------------------------

NORFOLK SOUTHERN CORP.
 1200 PEACOCK STREET, NE
 ATLANTA, GEORGIA 30309
 (404) 521-1000
 POND & COMPANY
 3852 AVIATION CIRCLE, SUITE 200
 ATLANTA, GEORGIA 30338
 (404) 252-1100
 LICENSE NO. 1119257

CORPORATE AIRCRAFT HANGAR FOR NORFOLK SOUTHERN CORPORATION
 FULTON COUNTY AIRPORT - BROWN FIELD (FTY)
 3852 AVIATION CIRCLE, SUITE 200
 ATLANTA, GEORGIA 30338

FIRE PROTECTION DETAILS

SHEET ID
F-502

7/9/2020 9:39:36 AM BIM 360://1190557_Pegasus/1190557_Pegasus_NS_MEP_FP_v19.rvt