


1 2 3 4 5

D
C
B
A

KEYNOTES


KEY#	KEYNOTE DESCRIPTION
1	REFER TO SHEET FA103 FOR FIRE ALARM DEVICE PLAN IN PUMP ROOM.
2	MOUNT APPLIANCE ABOVE HANGAR DOOR. COORDINATE MOUNTING HEIGHT AND LOCATION WITH HANGAR DOOR.
3	PROVIDE CONTROL MODULE AT HVLS FANS TO SHUT DOWN ON SPRINKLER WATER FLOW ACTIVATION.
4	PROVIDE RELAY TO ACTUATE DIVERTER VALVE ON FOAM ACTUATION.
5	PROVIDE CONTROL PANEL FOR DIVERTER VALVE. SEE FA501 FOR MORE INFORMATION.

GENERAL NOTES
1. SEE SHEET F-001 FOR GENERAL NOTES AND LEGEND.

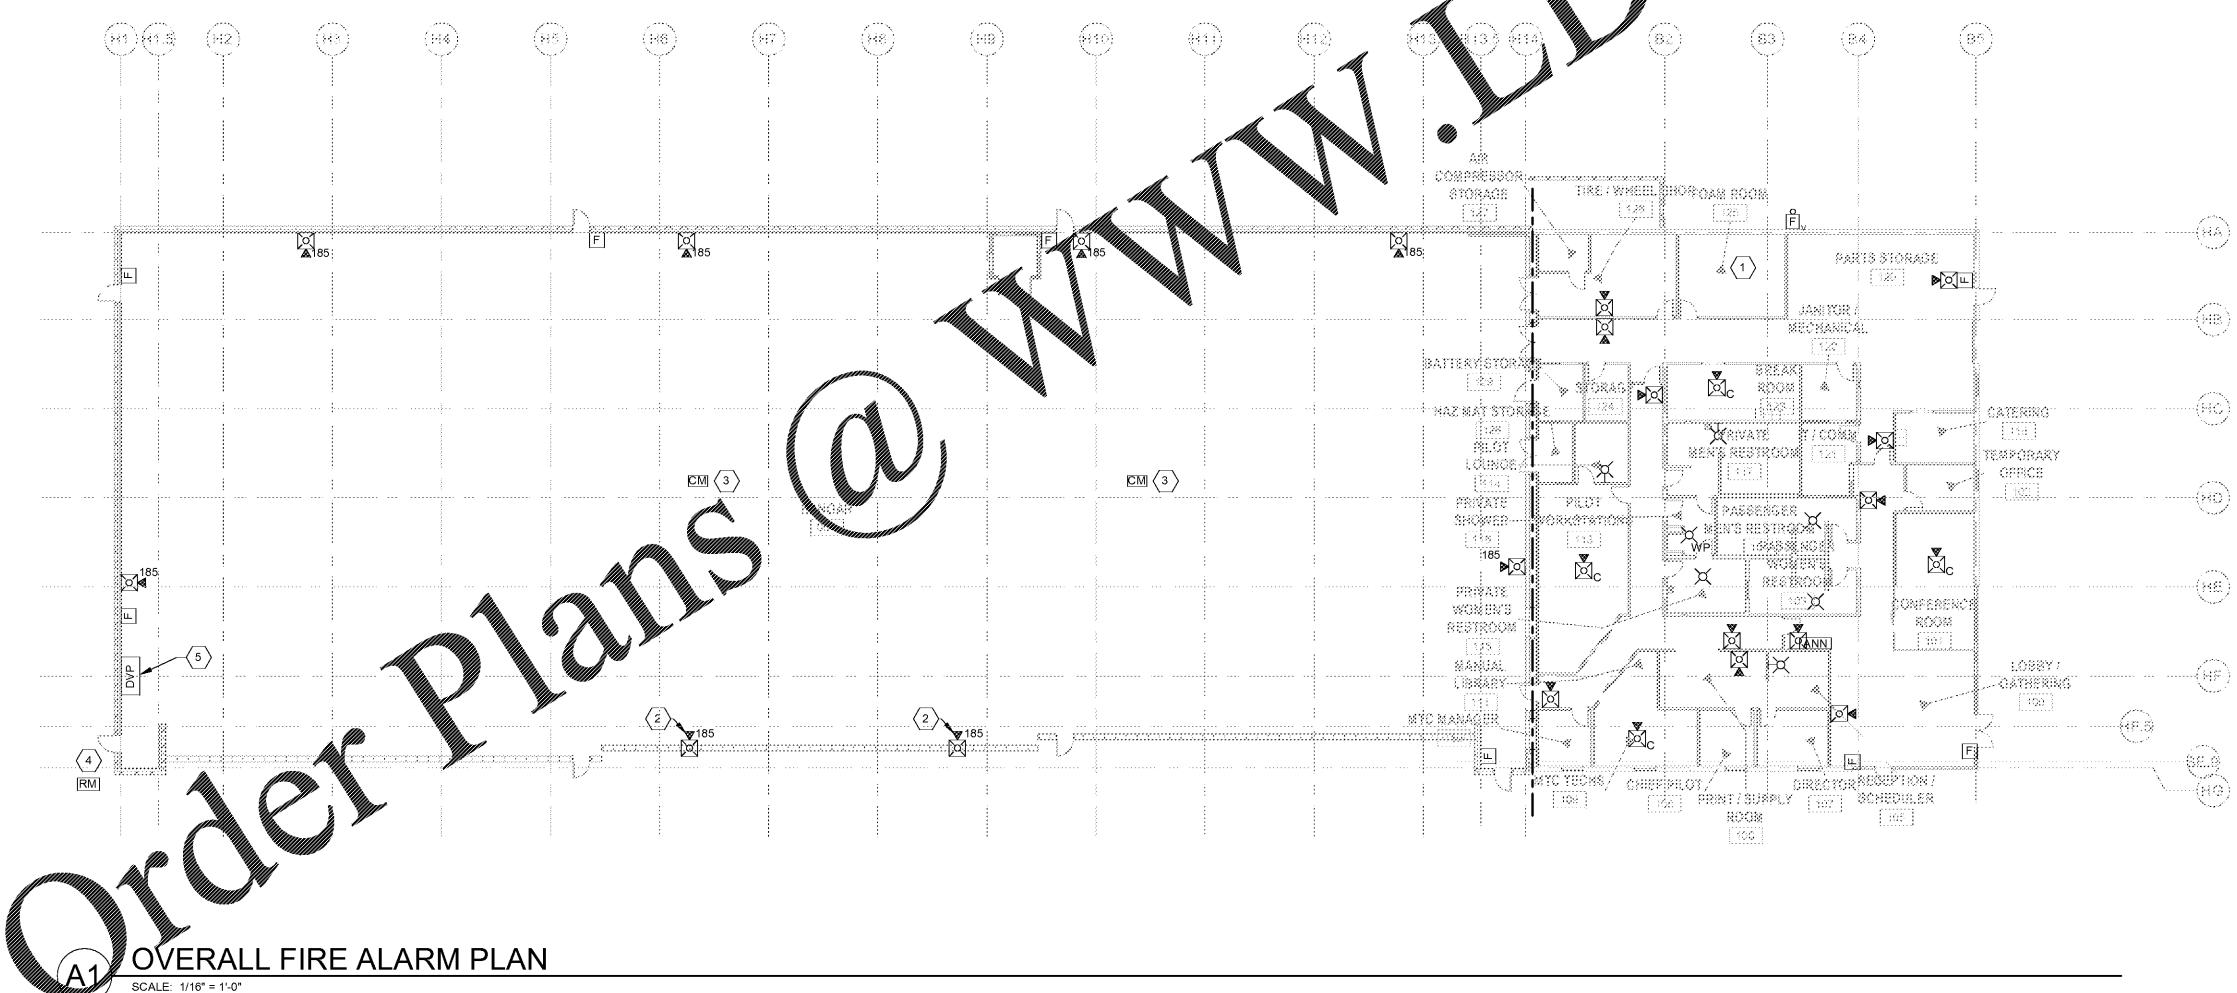

A1 OVERALL FIRE ALARM PLAN
SCALE: 1/16" = 1'-0"

www.LDILine.com

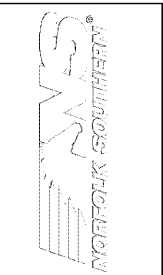

MARK	DESCRIPTION	DATE

DESIGNED BY: BTL	DRAWN BY: JAC	CHECKED BY: MS	SUBMITTED BY: Apprent	ISSUED FOR CONSTRUCTION: 15/1/2021
<small> OWNER REPRESENTATIVE: HENRIK HANSEN, INC. 1200 PEACHTREE STREET, NE ATLANTA, GEORGIA 30309 PHONE: (404) 261-1100 FAX: (404) 261-1101 E-MAIL: HENRIK@HENRIKHANSEN.COM </small>				
<small> ACCOUNTS/CLERK/OPERATOR: JACOBSON ENGINEERING, INC. 1100 W. BROADWAY, SUITE 100 ATLANTA, GEORGIA 30309 PHONE: (404) 525-1100 FAX: (404) 525-1101 E-MAIL: JACOBSON@JACOBSONENGINEERING.COM </small>				
<small> THESE PLANS ARE AN ADAPTATION OF THE ORIGINAL PLANS PREPARED BY THE ARCHITECT AND HIS OFFICE </small>				


NORFOLK SOUTHERN CORP.
1200 PEACHTREE STREET, NE
ATLANTA, GEORGIA 30309

POND
1200 PEACHTREE STREET, NE
ATLANTA, GEORGIA 30309
PHONE: (404) 261-1100
FAX: (404) 261-1101
E-MAIL: POND@PONDENGINEERING.COM

CORPORATE AIRCRAFT HANGAR FOR NORFOLK SOUTHERN CORPORATION
FULTON COUNTY AIRPORT - BROWN FIELD (FTY)
395 AVIATION CIRCLE, SUITE 200
ATLANTA, GEORGIA 30338

OVERALL FIRE ALARM PLAN

 SHEET ID
FA101



7/9/2020 9:39:37 AM BIM 360://1190557 - Pegasus/1190557_Pegasus_NS_MEP_FP_V19.rvt