


1 2 3 4 5

KEYNOTES	
KEY#	KEYNOTE DESCRIPTION
1	FLUSH MOUNT FIRE ALARM PULL STATION ON THE COLUMN. CONDUIT AND BACK BOX SERVING PULL STATION SHALL BE INSTALLED INSIDE OF COLUMN WRAP.

GENERAL NOTES
 1. SEE SHEET F-001 FOR GENERAL NOTES AND LEGEND.



A1 FIRE ALARM PLAN - OFFICES
 SCALE: 1/8" = 1'-0"

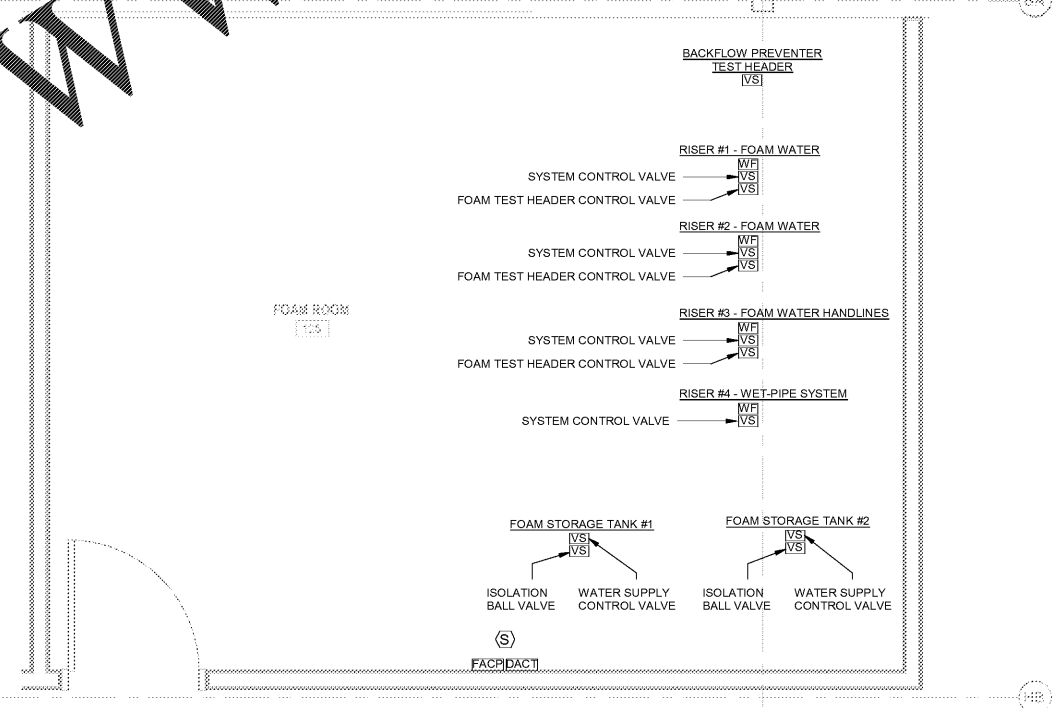

A3 FIRE ALARM PLAN - FOAM ROOM
 SCALE: 1/2" = 1'-0"



WWW.LDILine.com

Order Plans @



MARK	DESCRIPTION	DATE

DESIGNED BY: BTL	DRAWN BY: JAC	CHECKED BY: MS	SUBMITTED BY: Approved	ISSUED FOR CONSTRUCTION: 15/7/2021
<small> CIVIL ENGINEER STATE OF GEORGIA LICENSE NO. 12453 BRADY T. WOODWARD 1200 PEACOCK STREET, NE ATLANTA, GEORGIA 30309 PHONE: (404) 339-7240 FAX: (404) 339-7240 E-MAIL: BWOODWARD@LDI.COM </small>				

NORFOLK SOUTHERN CORP.
 1200 PEACOCK STREET, NE
 ATLANTA, GEORGIA 30309
POND
 3855 AVIATION CIRCLE, SUITE 200
 ATLANTA, GEORGIA 30338
 PHONE: (404) 339-7240
 FAX: (404) 339-7240
 E-MAIL: INFO@LDI.COM

SHEET ID
FA103

7/9/2020 9:39:39 AM BIM-360/11190557 - Pegasus/1190557_Pegasus_NS_MEP_FP_V19.rvt