
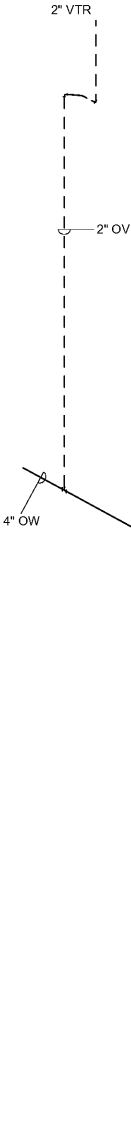


Order Plans @ www.LDILine.com

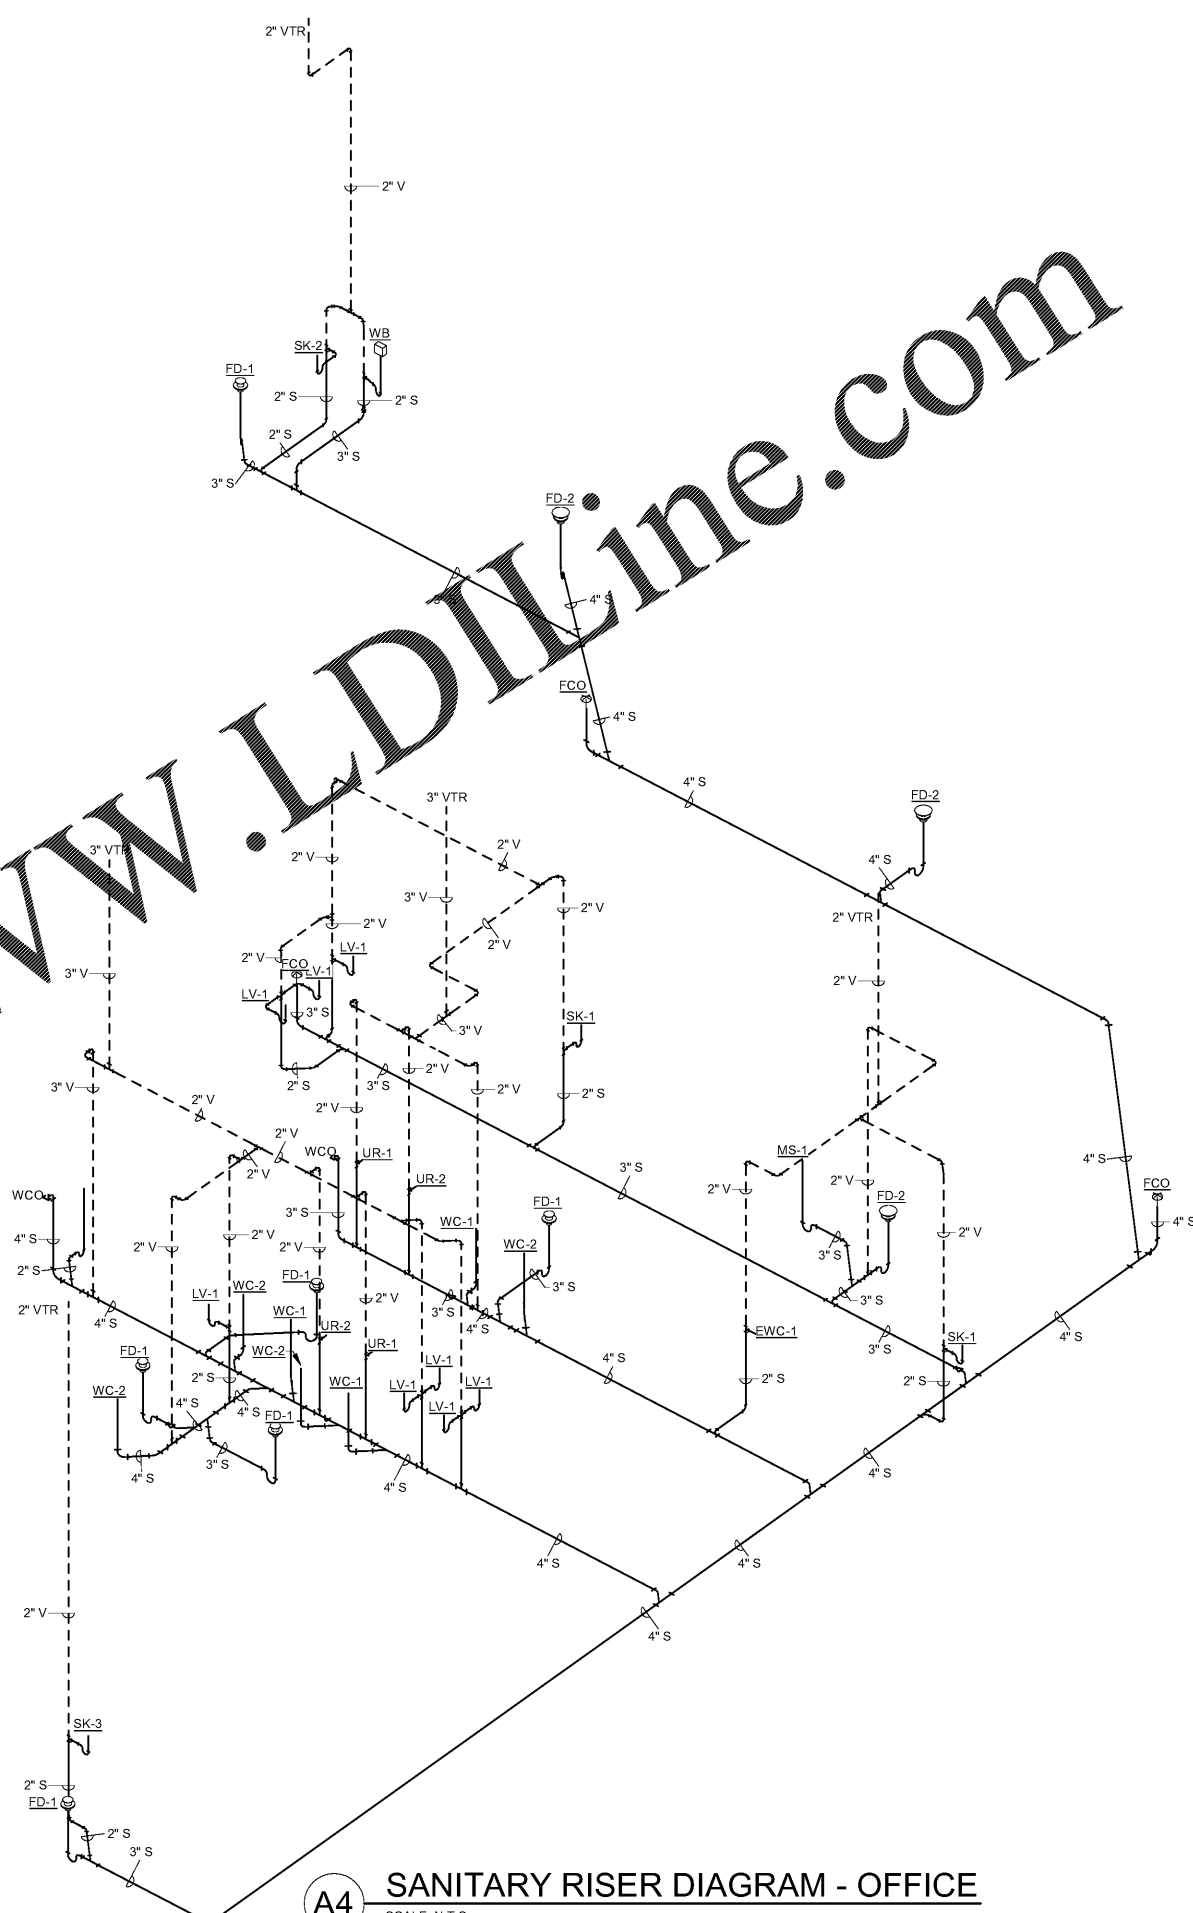


A1

OIL WASTE RISER DIAGRAM - HANGAR
SCALE: N.T.S.

A4

SANITARY RISER DIAGRAM - OFFICE
SCALE: N.T.S.

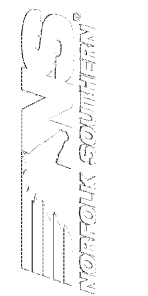

MARK	DESCRIPTION	DATE

DESIGNED BY:	DESIGNED BY:	DESIGNED BY:	DESIGNED BY:	DESIGNED BY:
DRAWN BY:	DRAWN BY:	DRAWN BY:	DRAWN BY:	DRAWN BY:
CHECKED BY:	CHECKED BY:	CHECKED BY:	CHECKED BY:	CHECKED BY:
ISSUED FOR CONSTRUCTION:	ISSUED FOR CONSTRUCTION:	ISSUED FOR CONSTRUCTION:	ISSUED FOR CONSTRUCTION:	ISSUED FOR CONSTRUCTION:
DATE:	DATE:	DATE:	DATE:	DATE:

NORFOLK SOUTHERN CORP
 1200 PEACHTREE STREET, NE
 ATLANTA, GEORGIA 30309
POND
 3000 Peachtree Lake, Atlanta, GA 30305
 Phone (770) 335-7740
 Fax (770) 335-7740
 Job No. 1190557

SHEET ID
P-901