



D  
C  
B  
A

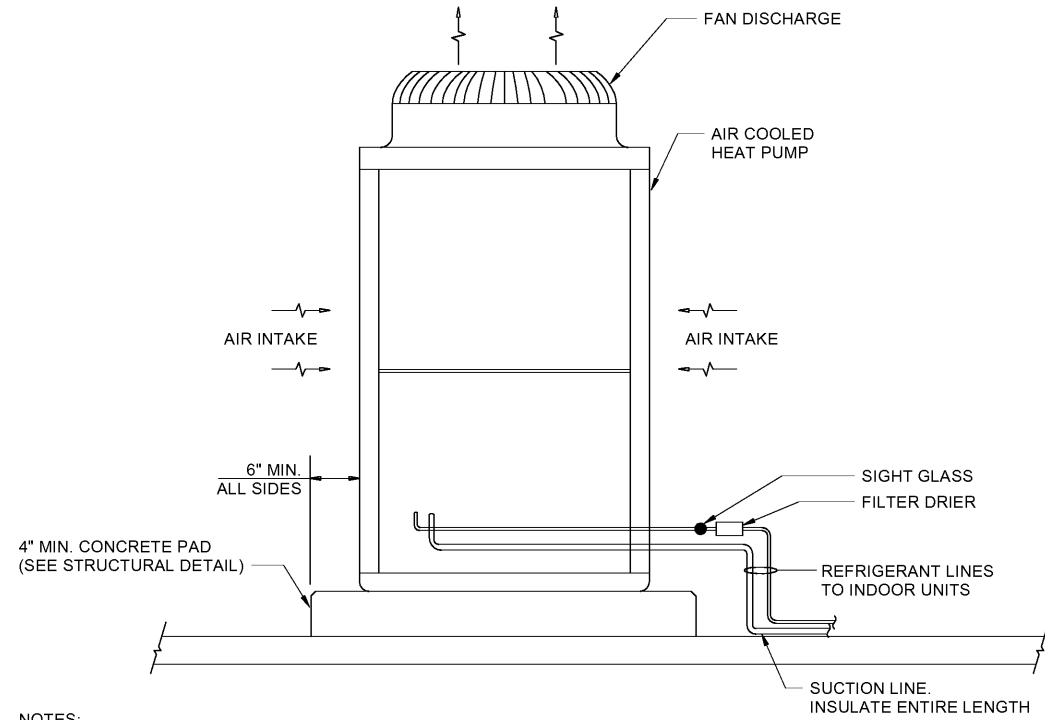


**NOTES:**  
 1. REFRIGERANT LINES SHALL BE SIZED PER MANUFACTURER'S RECOMMENDATIONS.  
 2. MAINTAIN CLEARANCES TO OBSTRUCTIONS AND FOR SERVICE ACCESS PER MANUFACTURER'S RECOMMENDATIONS.

**C1 VRF HEAT PUMP DETAIL**  
 SCALE: N.T.S.

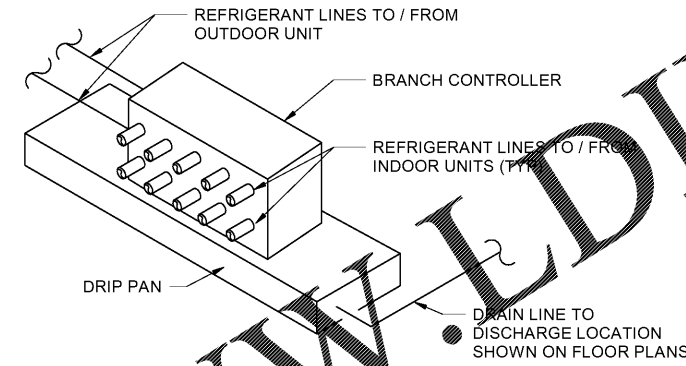


**C3 VRF BRANCH CONTROLLER DETAIL**  
 SCALE: N.T.S.

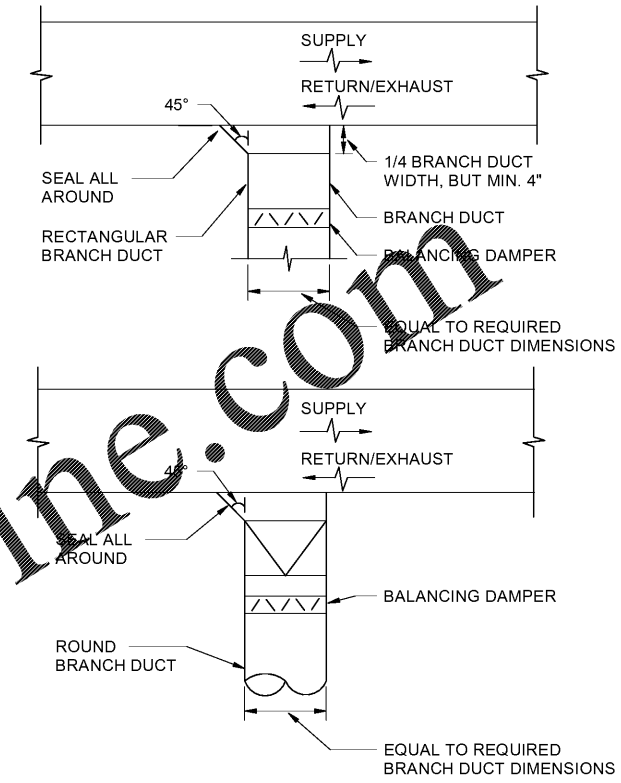


**NOTE:**  
 1. STANDARD BELLMOUTH FITTINGS (WITH RADIUS = DIAMETER / 5) MAY BE SUBSTITUTED FOR BRANCH FITTINGS.

**C4 BRANCH DUCT CONNECTION DETAIL**  
 SCALE: N.T.S.

 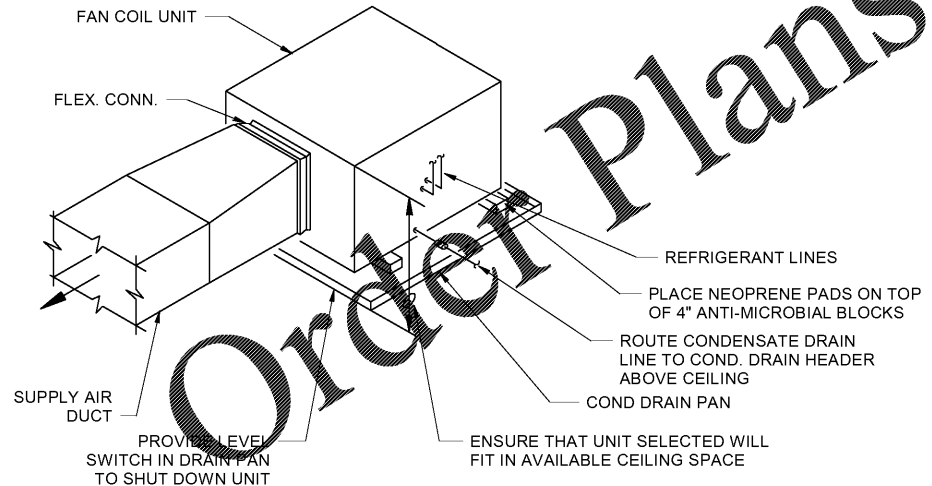


**A1 FAN COIL UNIT DETAIL**  
 SCALE: N.T.S.

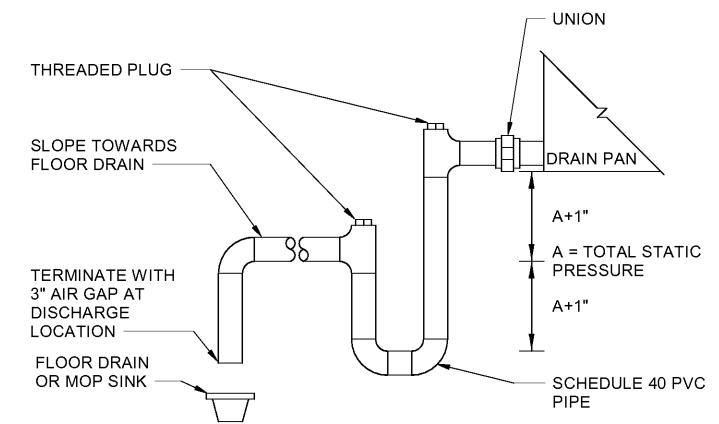

**NOTE:**  
 1. TYPE "L" COPPER IN RETURN AIR PLENUMS.

**A3 CONDENSATE DRAIN DETAIL**  
 SCALE: N.T.S.



MARK	DESCRIPTION	DATE

DESIGNED BY: JAN	CHECKED BY: JAN	ISSUED FOR CONSTRUCTION: ERA
DRAWN BY: JAN	DATE: 13-JUL-2020	

**POND**  
 3000 Peachtree Lane, Suite 200  
 Atlanta, Georgia 30305  
 Phone (404) 335-7740  
 Fax (404) 335-7740  
 Lic. No. 1185547

**MECHANICAL DETAILS**  
 SHEET ID  
**M-501**

7/10/2020 11:39:44 AM BIM 360://1190557 - Pegasus/1190557\_Pegasus\_NS\_MEP\_FP\_v19.rvt