

SHEET NOTES:

1. REFER TO E-001 & E-002 FOR ELECTRICAL GENERAL NOTES, ABBREVIATIONS & LEGEND.

KEYNOTES:

- 1. 208V/3PH, 35A FEED TO DOOR BUSWAY (BY NORCO). REFER TO ELEVATION C1/E-504.
- 2. PROVIDE ARKITE AREAL20426 NEMA 3R RECEPTACLE FOR AC CART GPU. CONFIRM WITH OWNER FURNISHED EQUIPMENT PRIOR TO ORDERING.
- 3. PROVIDE ARKITE AREAL20426 NEMA 3R RECEPTACLE FOR DC CART GPU. CONFIRM WITH OWNER FURNISHED EQUIPMENT PRIOR TO ORDERING.
- 4. PROVIDE NEMA L15-30 RECEPTACLE POWER FOR AIR CONDITIONING CART.
- 5. PROVIDE NEMA L14-20 RECEPTACLE POWER FOR HYDRAULIC MULE.
- 6. NEMA 14-30R DRYER RECEPTACLE. 3#10 & 1#10G - 3/4" C.
- 7. POWER FOR DOORBELL SYSTEM. MOUNT AT 10'-0" AFF.
- 8. REFER TO C/E-504 AND E-001 FOR MORE INFORMATION AND ELEVATION VIEW OF DOOR POWER FEED.
- 9. 120V/1PH, 15A POWER FOR OFOI ACCESS CONTROLS. LOCATE JUNCTION BOX ABOVE DOOR HEADER ON SECURE SIDE OF DOOR.




MARK	DESCRIPTION	DATE

DESIGNED BY:	DRAWN BY:	CHECKED BY:	SUBMITTED BY:	ISSUED FOR CONSTRUCTION:

NORFOLK SOUTHERN CORP
 1200 PEACHTREE STREET, NE
 ATLANTA, GEORGIA 30309
POND
 3000 Peachtree Lane, Suite 200
 Atlanta, Georgia 30328
 Phone (770) 335-7740
 Job No. 1185517

CORPORATE AIRCRAFT HANGAR FOR NORFOLK SOUTHERN CORPORATION
 FULTON COUNTY AIRPORT - BROWN FIELD (FTY)
 3627 AVIATION CIRCLE, SUITE 200
 ATLANTA, GEORGIA 30336
POWER PLAN - HANGAR AREA

SHEET ID
E-111A

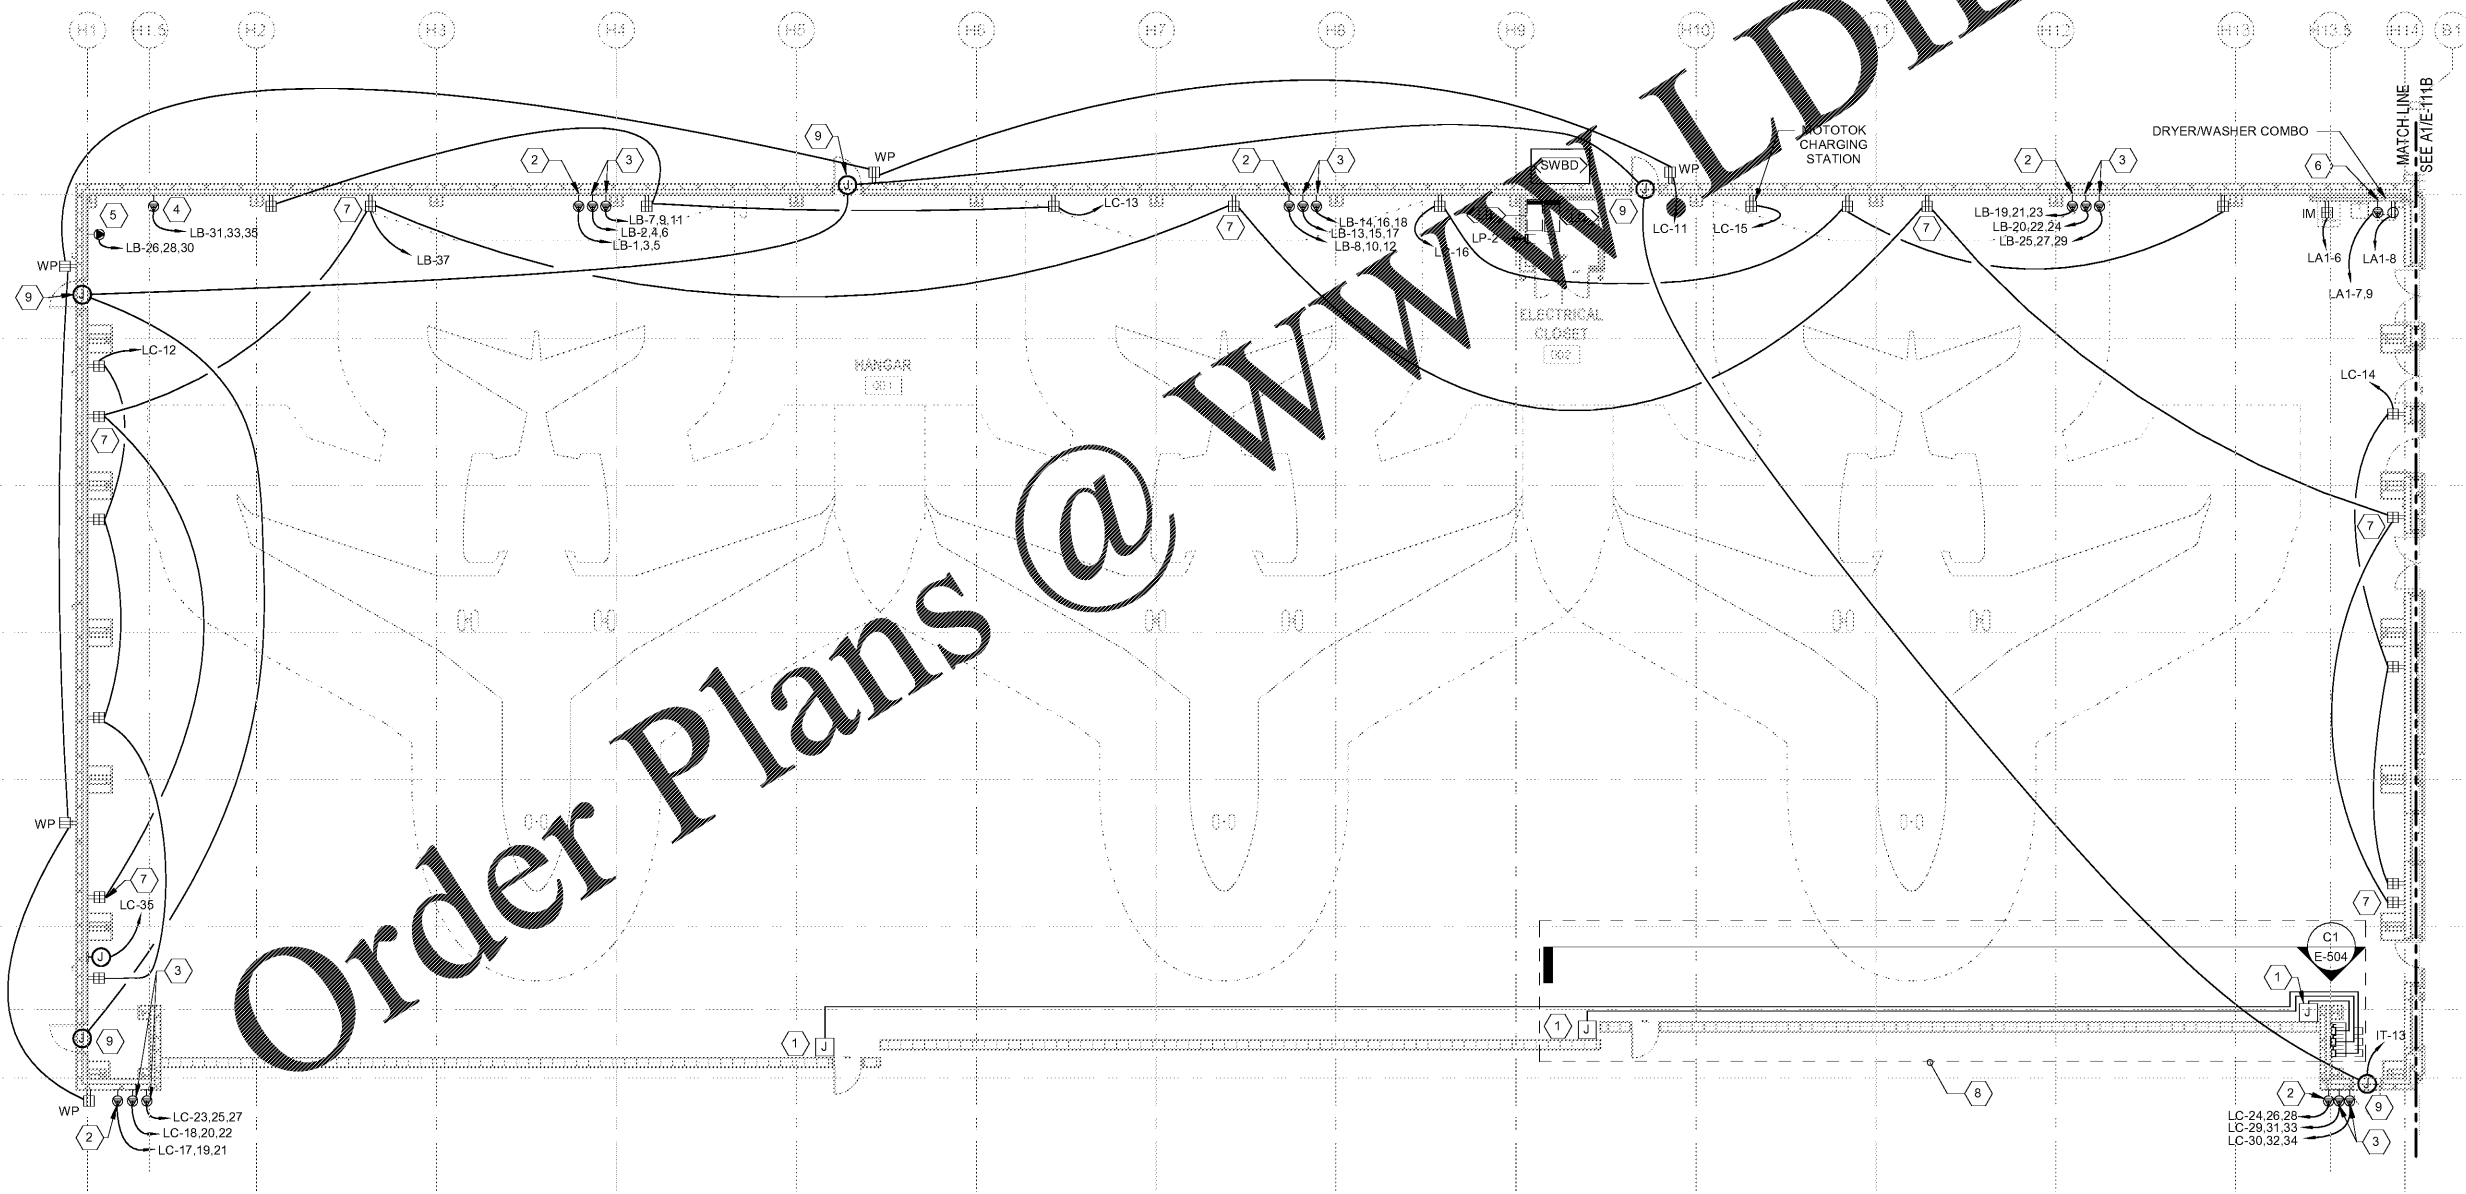

Order Plans @ www.LDILine.com

A1 POWER PLAN - HANGAR AREA
SCALE: 3/32" = 1'-0"

