

SHEET NOTES:


- 1. REFER TO E-001 & E-002 FOR ELECTRICAL GENERAL NOTES, ABBREVIATIONS & LEGEND.
- 2. REFER TO E-612 FOR MECHANICAL EQUIPMENT CONNECTION SCHEDULE.

KEYNOTES:


- 1. 120V/1PH POWER INSTALLED BEHIND FIXTURE FOR AUTOMATIC FLUSH VALVE. COORDINATE FINAL LOCATION WITH PLUMBING CONTRACTOR PRIOR TO INSTALLATION.



Order Plans @ www.LDILine.com

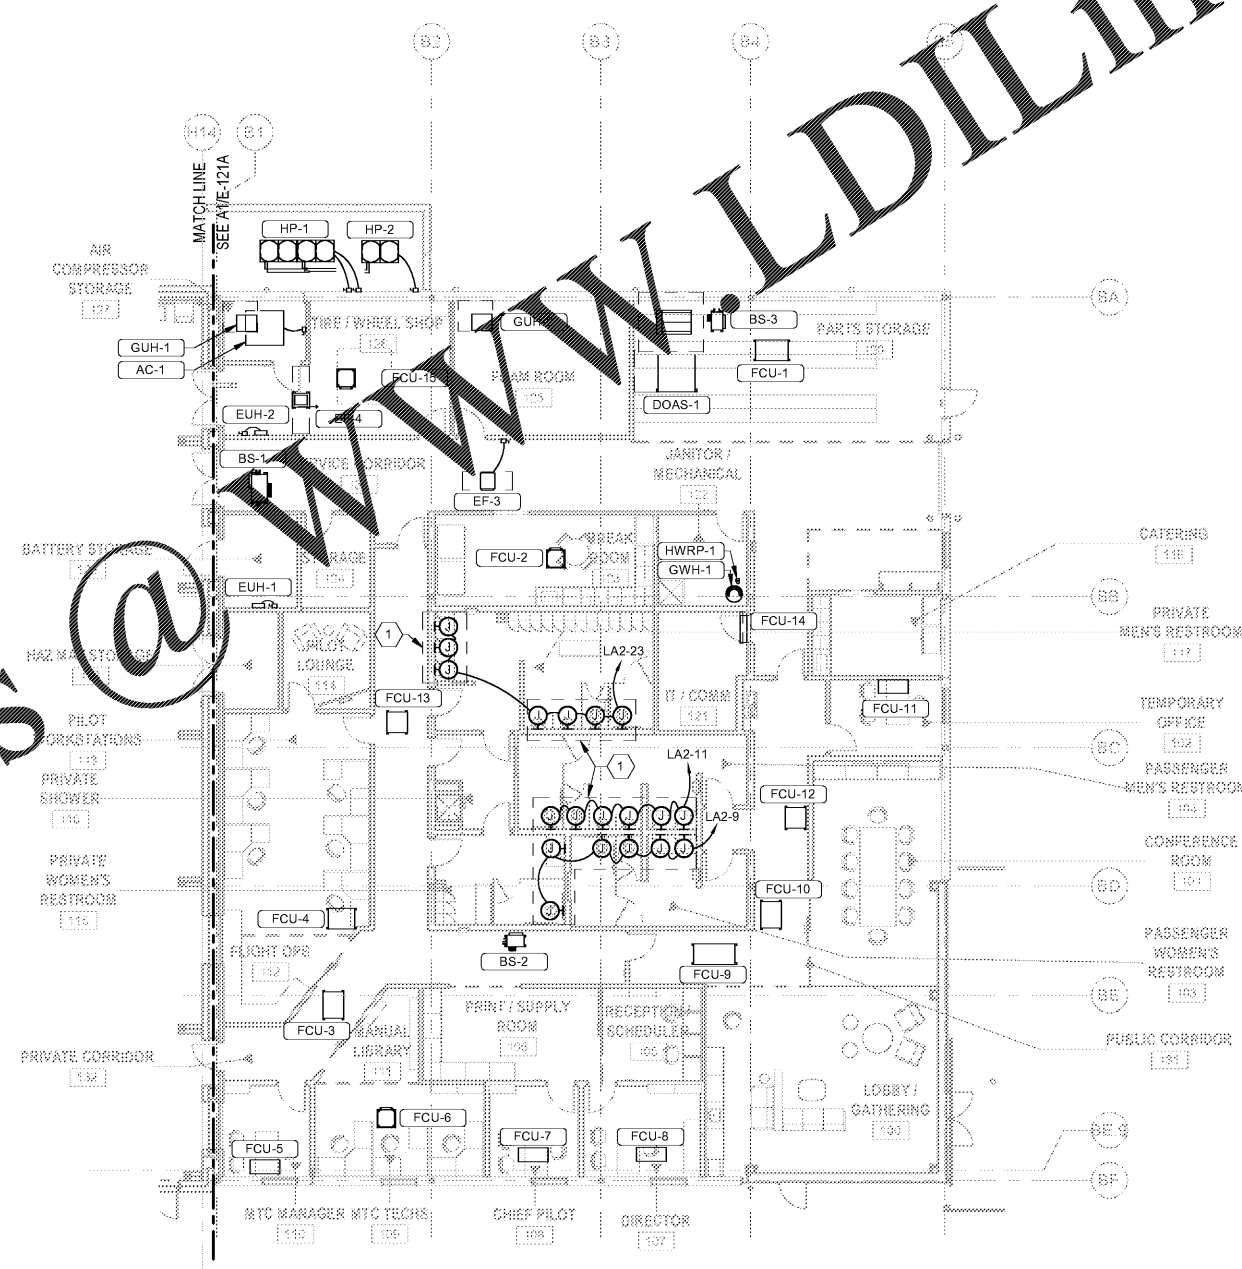

 A3 MECHANICAL POWER PLAN - OFFICE AREA
SCALE: 3/32" = 1'-0"



MARK	DESCRIPTION	DATE

DESIGNED BY: _____
 DRAWN BY: _____
 CHECKED BY: _____
 SUBMITTED BY: _____
 ISSUED FOR CONSTRUCTION: _____
 DC-MM-YYYY

OWNER REPRESENTATIVE: NORFOLK SOUTHERN CORPORATION, 1000 N. AVENUE, SUITE 1000, NORFOLK, VA 23510
 CONTRACT NO. 1185547
 PROJECT NO. 1185547
 SHEET NO. E-121B

MECHANICAL POWER PLAN - OFFICE AREA

SHEET ID
E-121B