

**PLUMBING ACCESSORIES SCHEDULE**


Project Name: Marriott Sawgrass  
 Issue Date: 05-06-2020  
 Revision(s):

Spec #	Drawing Designation	Products	Color	Brand	QTY	ku/K#	ADA	Calgreen	Watersense	SPEC SHEET...
10 2813	B11	Surface-mounted toilet tissue dispenser and utility shelf.	Satin	Bobrick	8	B-2840	Yes			Yes
10 2813	D2	Recessed convertible paper towel dispenser and waste receptacle	Satin	Bobrick	4	813061	Yes			Yes
10 2813	D5	Recessed paper towel dispenser and waste receptacle.	Satin	Bobrick	4	B-36503	Yes			Yes
10 2813	E4, E5	Grab Bar	Satin	Kohler	8	K-11890	Yes			Yes
10 2813	G1	Surface-mounted sanitary napkin disposal	Satin	Bobrick	4	B-270	Yes			Yes
10 2813	J3	Counter mounted automatic liquid soap dispenser.	Brushed Satin Finish	Bobrick	8	B-858	Yes			Yes
10 2813	K1	Surface-mounted seat-cover dispenser	Satin	Bobrick	6	B-4221	Yes			Yes
10 2813	V1	Robe hook	Brushed Satin Finish	Kohler	8	K-67897				Yes
10 2813	Q1	Baby Changing Stations Horizontal Wall Mounted	Satin	Koala Kare	4	KB110-SSVM				Yes
10 2813	EWC	Bottle filling station with integral fountain wall mounted	Satin	Elkay	1	EZWS-EDFPM117-K				Yes

**STANDARD LAYOUTS - FLORIDA**

SCALE: 1/4" = 1'-0"


NOTE: LOCATE FLUSH ACTIVATION ON WIDE SIDE AT ALL TOILETS - LOCATE FLUSH VALVE BENEATH ADJACENT GRAB BARS.

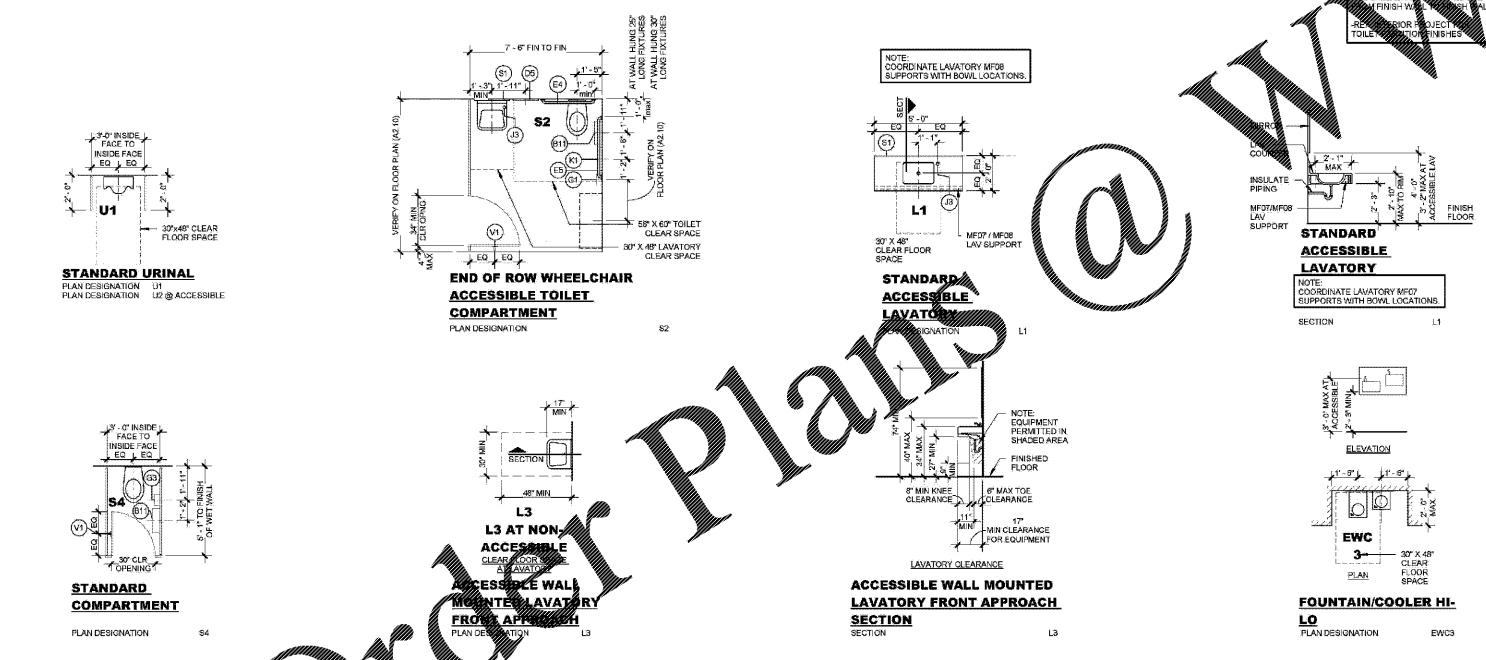


**TOILET ACCESSORY MOUNTING DIAGRAM**

SCALE: 1/4" = 1'-0"

NOTE:  
 1. ACCESSORIES LISTED MAY HAVE GAPS IN ALPHABETICAL LISTING.  
 2. ACCESSORIES CAN APPEAR ON FLOOR PLANS OR INTERIOR ELEVATIONS.  
 3. ALL DIMENSIONS INDICATED ARE FROM FINISH WALL TO FINISH WALL.

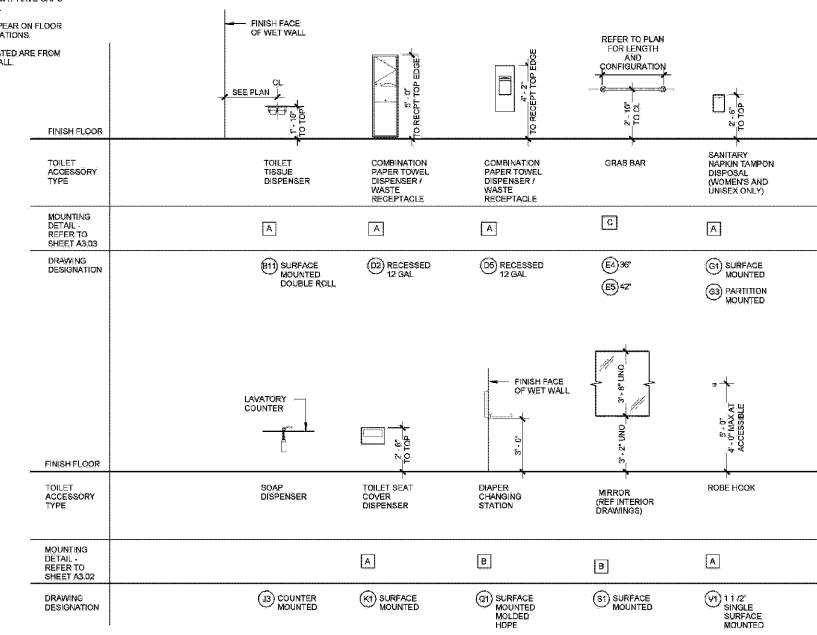

**FIXTURE AND PARTITION MOUNTING DIAGRAM**

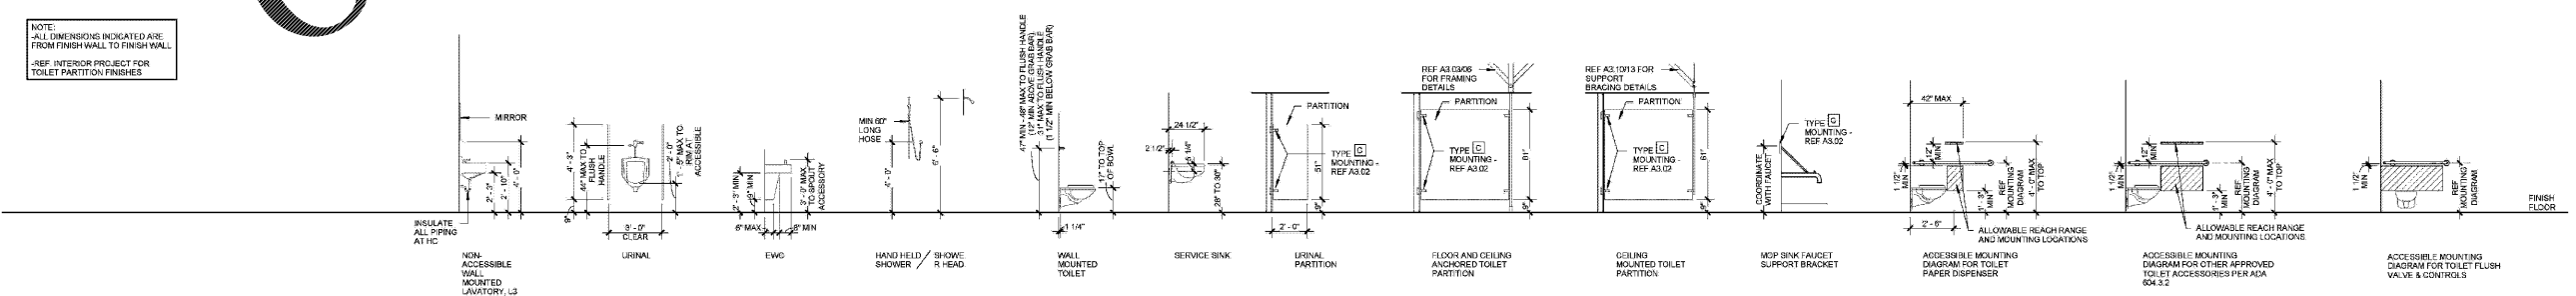

ARCHITECT  
 HKS ARCHITECTS, INC.  
 2030 SALZEDO ST, 4TH FLOOR  
 CORAL GABLES, FL 33134

STRUCTURAL CONSULTANT  
 THE RYAN TOMASETTI  
 101 NE THIRD AVE, SUITE 1170  
 FORT LAUDERDALE, FL 33301-1189

MEP CONSULTANT  
 THOMPSON E-FILE  
 53 TECHNOLOGY PKWY S PEACHTREE CORNERS,  
 GA 30092

KITCHEN CONSULTANT  
 INNOVATIVE FOOD SERVICE  
 11101 NORTH 48TH STREET, TAMPA, FL 33617

WATERPROOFING CONSULTANT  
 CDC USA  
 8070 Park Ln., Suite 400 Dallas, TX 75221

CODE & LIFE SAFETY CONSULTANT  
 HOWE ENGINEERS  
 101 LONGWATER CIR. NORWELL, MA 02061

**MARRIOTT SAWGRASS  
 CABANA CLUB**


 
615 PONTE VEDRA BLVD  
 PONTE VEDRA BEACH, FL 32082

OWNER  
 WATERMARK CAPITAL PARTNERS, LLC  
 100 NORTH RIVERSIDE PLAZA SUITE 400  
 CHICAGO, IL 60606

OWNER'S CONSULTANT  
 THE JOHN HARDY GROUP INC.  
 6085 SHELLEY RD., SUITE 200  
 ATLANTA, GA 30328

CIVIL ENGINEER AND LANDSCAPE CONSULTANT  
 KIMLEY-HORN  
 12740 GRAN BAY PARKWAY WEST  
 SUITE 2280  
 JACKSONVILLE, FL 32256

INTERIOR DESIGN CONSULTANT  
 HBA DESIGN  
 3216 MERIDIANA AVENUE, SANTA MONICA,  
 CALIFORNIA 90404 U.S.A.

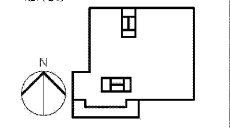

KEY PLAN

NO.	DESCRIPTION	DATE

HKS PROJECT NUMBER  
**22808.001**

DATE  
**05/22/2020**

ISSUE

**PERMIT SET**

SHEET TITLE  
**FLORIDA TOILET LAYOUTS AND STD ACCESSORIES**

SHEET NO.  
**A3.23**

© 2020 HKS ARCHITECTS, INC.