


**MARRIOTT SAWGRASS
CABANA CLUB**

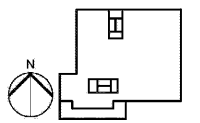

REVISION NO.	DESCRIPTION	DATE

HKS PROJECT NUMBER
22808.001
DATE:
05/22/2020
ISSUE:
PERMIT SET


9-SHEET TITLE
**FLOOR PLAN -
LEVEL 01 & 02 -
MECH. PIPING**
SHEET NO.

M4.01


KITCHEN EQUIPMENT 'X':

ITEM	DESCRIPTION	EXHAUST (CFM)	MAKE-UP (CFM)
7	MEDIUM TEMP. REMOTE COMPRESSOR	--	--
14	MEDIUM TEMP. REMOTE COMPRESSOR	--	--
19	LOW TEMP. REMOTE COMPRESSOR	--	--
34	CONDENSATE EXHAUST HOOD	600	--
71 L	TYPE I EXHAUST HOOD	2154	1723
71 R	TYPE I EXHAUST HOOD	2154	1723
204	MEDIUM TEMP. REMOTE COMPRESSOR	--	--
238	CONDENSATE EXHAUST HOOD	600	--
239	TYPE I EXHAUST HOOD	1000	--


NOTE:
KITCHEN EQUIPMENT IS SCHEDULED FOR REFERENCE ONLY. REFER TO FOOD SERVICE DRAWINGS FOR EQUIPMENT SPECIFICATIONS AND PIPING REQUIREMENTS.

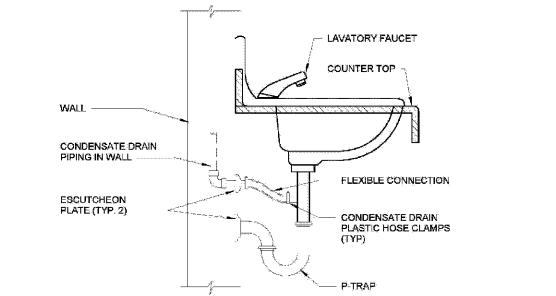

3 CONDENSATE DRAIN TO LAVATORY TAILPIECE DETAIL
M4.01 N.T.S.

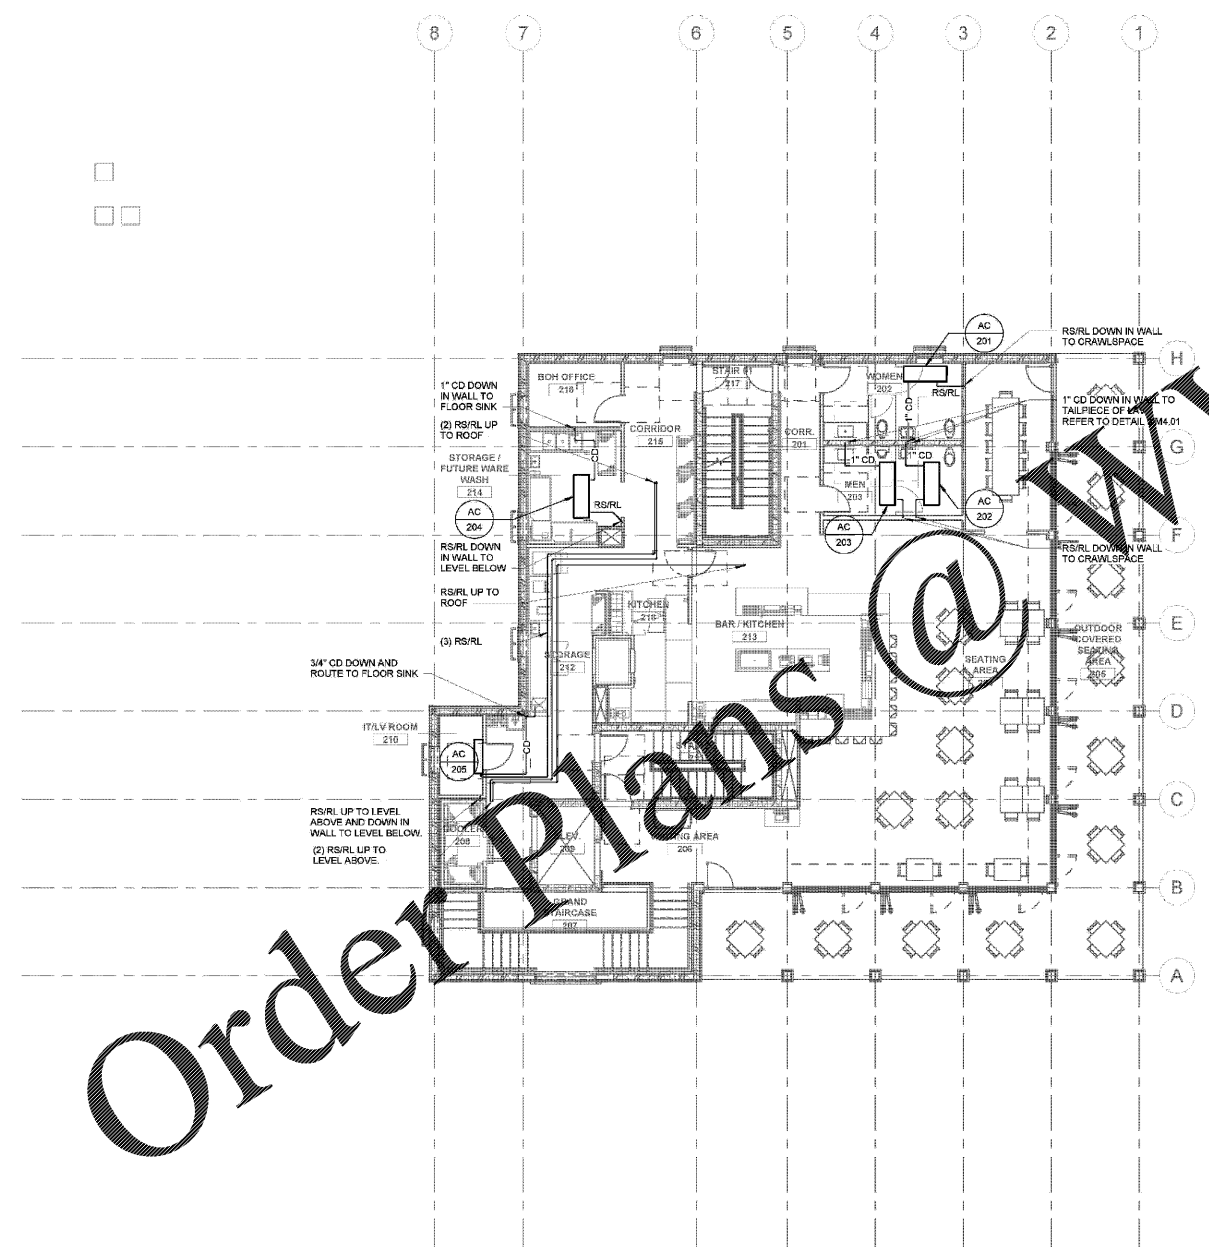

2 FLOOR PLAN - LEVEL 02 - MECHANICAL PIPING
M4.01 1/8" = 1'-0"

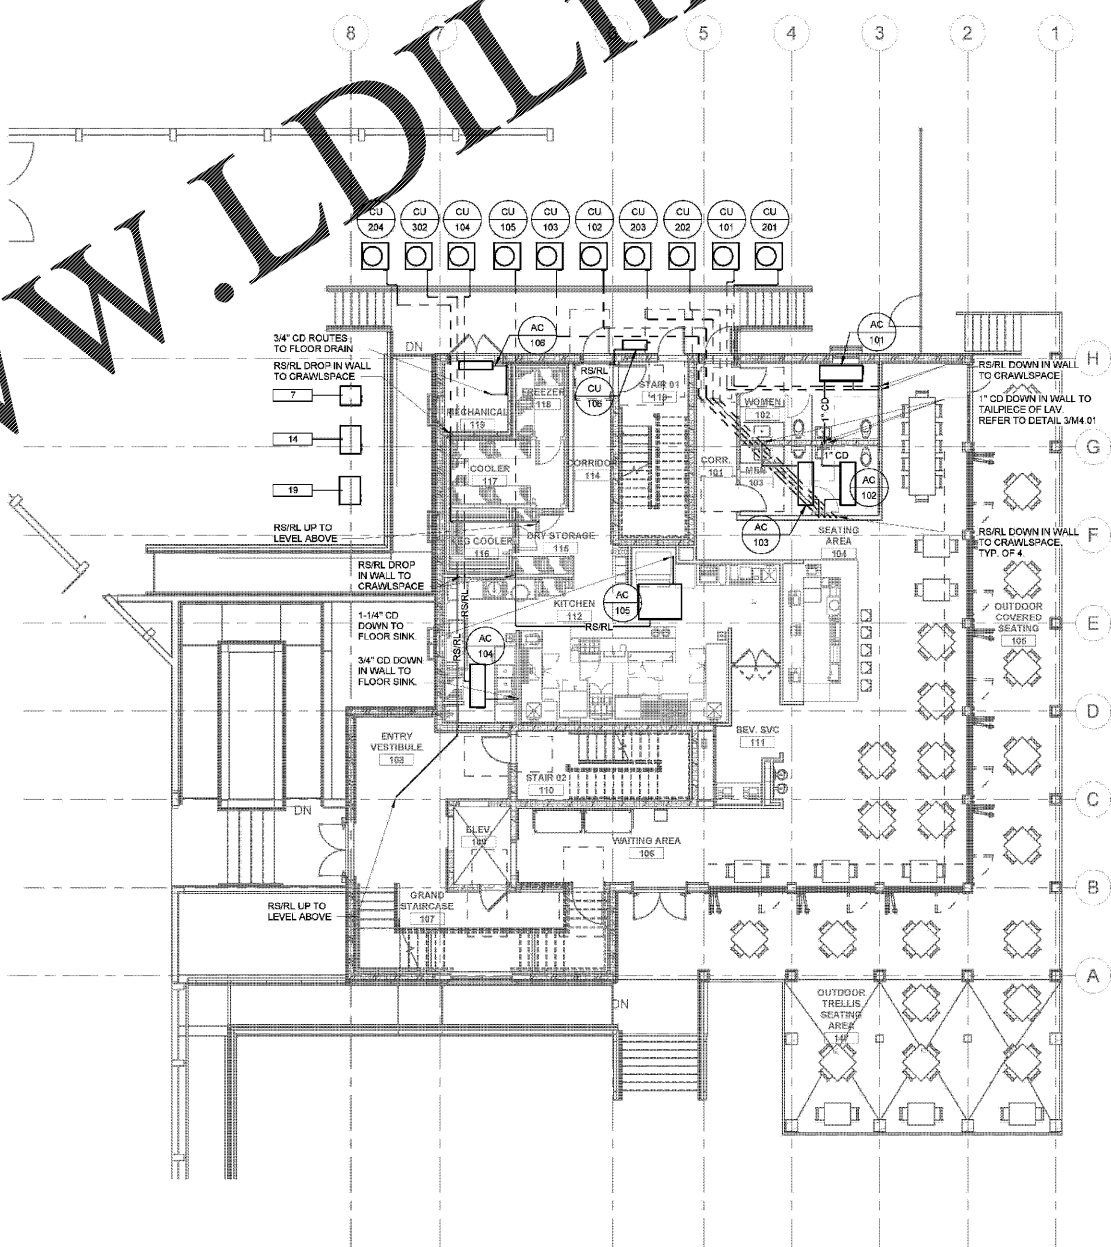

1 FLOOR PLAN - LEVEL 01 - MECHANICAL PIPING
M4.01 1/8" = 1'-0"

Order Plans @ www.LDILine.com

www.LDILine.com