

**ARCHITECT**  
HKS ARCHITECTS, INC.  
844 100319  
201 ALHAMBRA CIRCLE, SUITE 802  
CORAL GABLES, FL 33134

**CIVIL ENGINEER**  
KIMLEY-HORN  
12740 GRIFFIN BAY PARKWAY WEST  
SUITE 2350  
JACKSONVILLE, FL 32258

**STRUCTURAL CONSULTANT**  
THORNTON TOMASETTI  
101 NE THIRD AVE., SUITE 1170  
FORT LAUDERDALE, FL 33301-1190

**MEP CONSULTANT**  
THOMPSON E&E  
55 TECHNOLOGY PARKWAY S, PEACHTREE CORNERS,  
GA 30092

**KITCHEN CONSULTANT**  
INNOVATIVE FOOD SERVICE  
11101 NORTH 40TH STREET, TAMPA, FL 33617

**WATERPROOFING CONSULTANT**  
CDC USA  
8070 Park Ln., Suite 400 Dallas, TX 75251

**CODE & LIFE SAFETY CONSULTANT**  
HOWE ENGINEERS  
101 LONGWATER CIR. NORWELL, MA 02061

## MARRIOTT SAWGRASS CABANA CLUB


**OWNER**  
WATERMARK CAPITAL PARTNERS, LLC  
150 NORTH RIVERSIDE PLAZA, SUITE 4200  
CHICAGO, IL 60606

**OWNER'S CONSULTANT**  
THE JOHN HARDY GROUP INC.  
6085 SAKFIELD RD., SUITE 200  
ATLANTA, GA 30328

Allen Ellis, State of Florida, Professional Engineer,  
License No. 77261  
This sheet has been electronically signed and sealed by  
Allen Ellis, on the Date and/or Time Stamp using a digital  
signature.

Printed copies of this document are not considered signed  
and sealed, and the signature must be verified on any  
electronic copy.

KEY PLAN

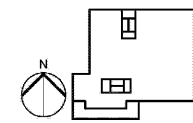

REVISION  
NO. DESCRIPTION DATE

NO.	DESCRIPTION	DATE

HKS PROJECT NUMBER  
**22808.001**

DATE:  
**05/22/2020**

ISSUE:  
**PERMIT SET**

9-SHEET TITLE  
**FLOOR PLAN -  
DECK & ROOF -  
MECH. PIPING**


SHEET NO.

**M4.02**

**KITCHEN EQUIPMENT ' X ':**

ITEM	DESCRIPTION	EXHAUST (CFM)	MAKE-UP (CFM)
7	MEDIUM TEMP. REMOTE COMPRESSOR	--	--
14	MEDIUM TEMP. REMOTE COMPRESSOR	--	--
19	LOW TEMP. REMOTE COMPRESSOR	--	--
34	CONDENSATE EXHAUST HOOD	600	--
71 L	TYPE I EXHAUST HOOD	2154	1723
71 R	TYPE I EXHAUST HOOD	2154	1723
204	MEDIUM TEMP. REMOTE COMPRESSOR	--	--
238	CONDENSATE EXHAUST HOOD	600	--
299	TYPE I EXHAUST HOOD	1000	--

**NOTE:**  
KITCHEN EQUIPMENT IS SCHEDULED FOR REFERENCE ONLY. REFER TO FOOD SERVICE DRAWINGS FOR EQUIPMENT SPECIFICATIONS AND PIPING REQUIREMENTS.

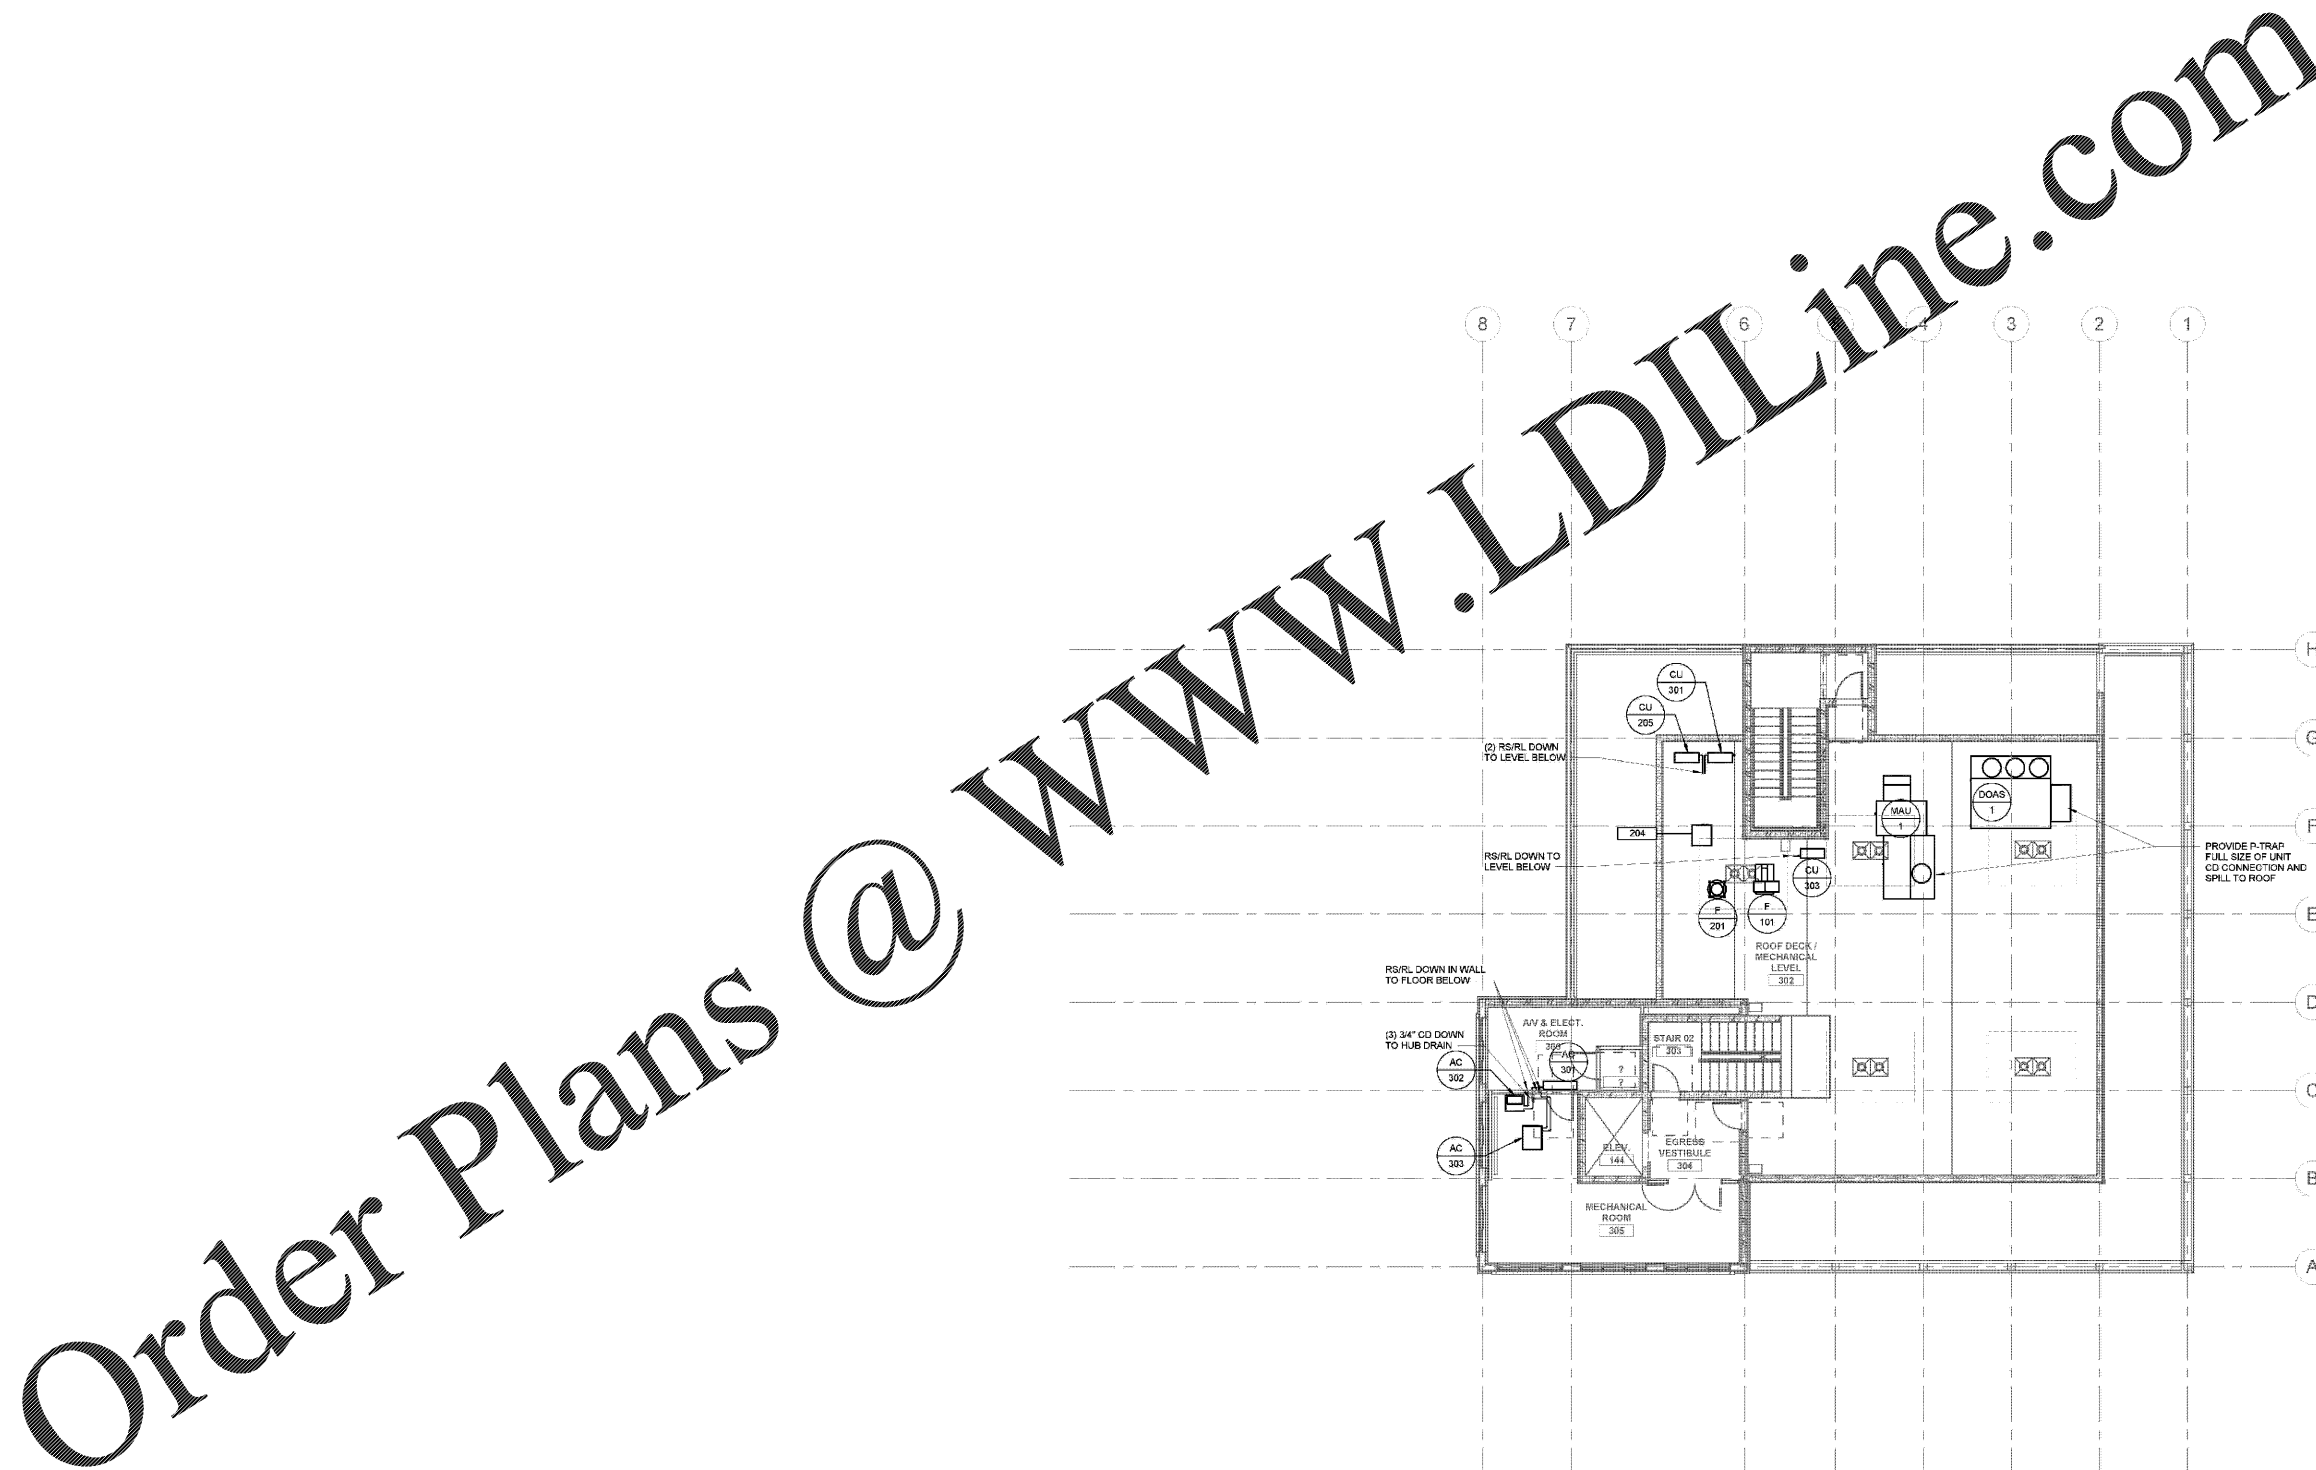

**1 FLOOR PLAN - DECK LEVEL - MECHANICAL PIPING**  
M4.02 1/8" = 1'-0"

Order Plans @ [www.LDILine.com](http://www.LDILine.com)