


General

1. Lay out provided for architectural purposes of defining placement of furnishings and equipment. Contractor shall verify final location and power requirements from manufacturer instruction.
2. Plan has been prepared without the benefit of mechanical engineer review and shall not be construed as an engineered plan, but rather a schematic of how the Owner prefers the HVAC system to be installed and operate. Contractor is responsible for any engineering required by City.
3. All work shall be performed by licensed mechanical contractor with the City of Oxford and shall be installed in strict accordance with all applicable standards of the current International Mechanical Code all applicalbe local codes and regulations.

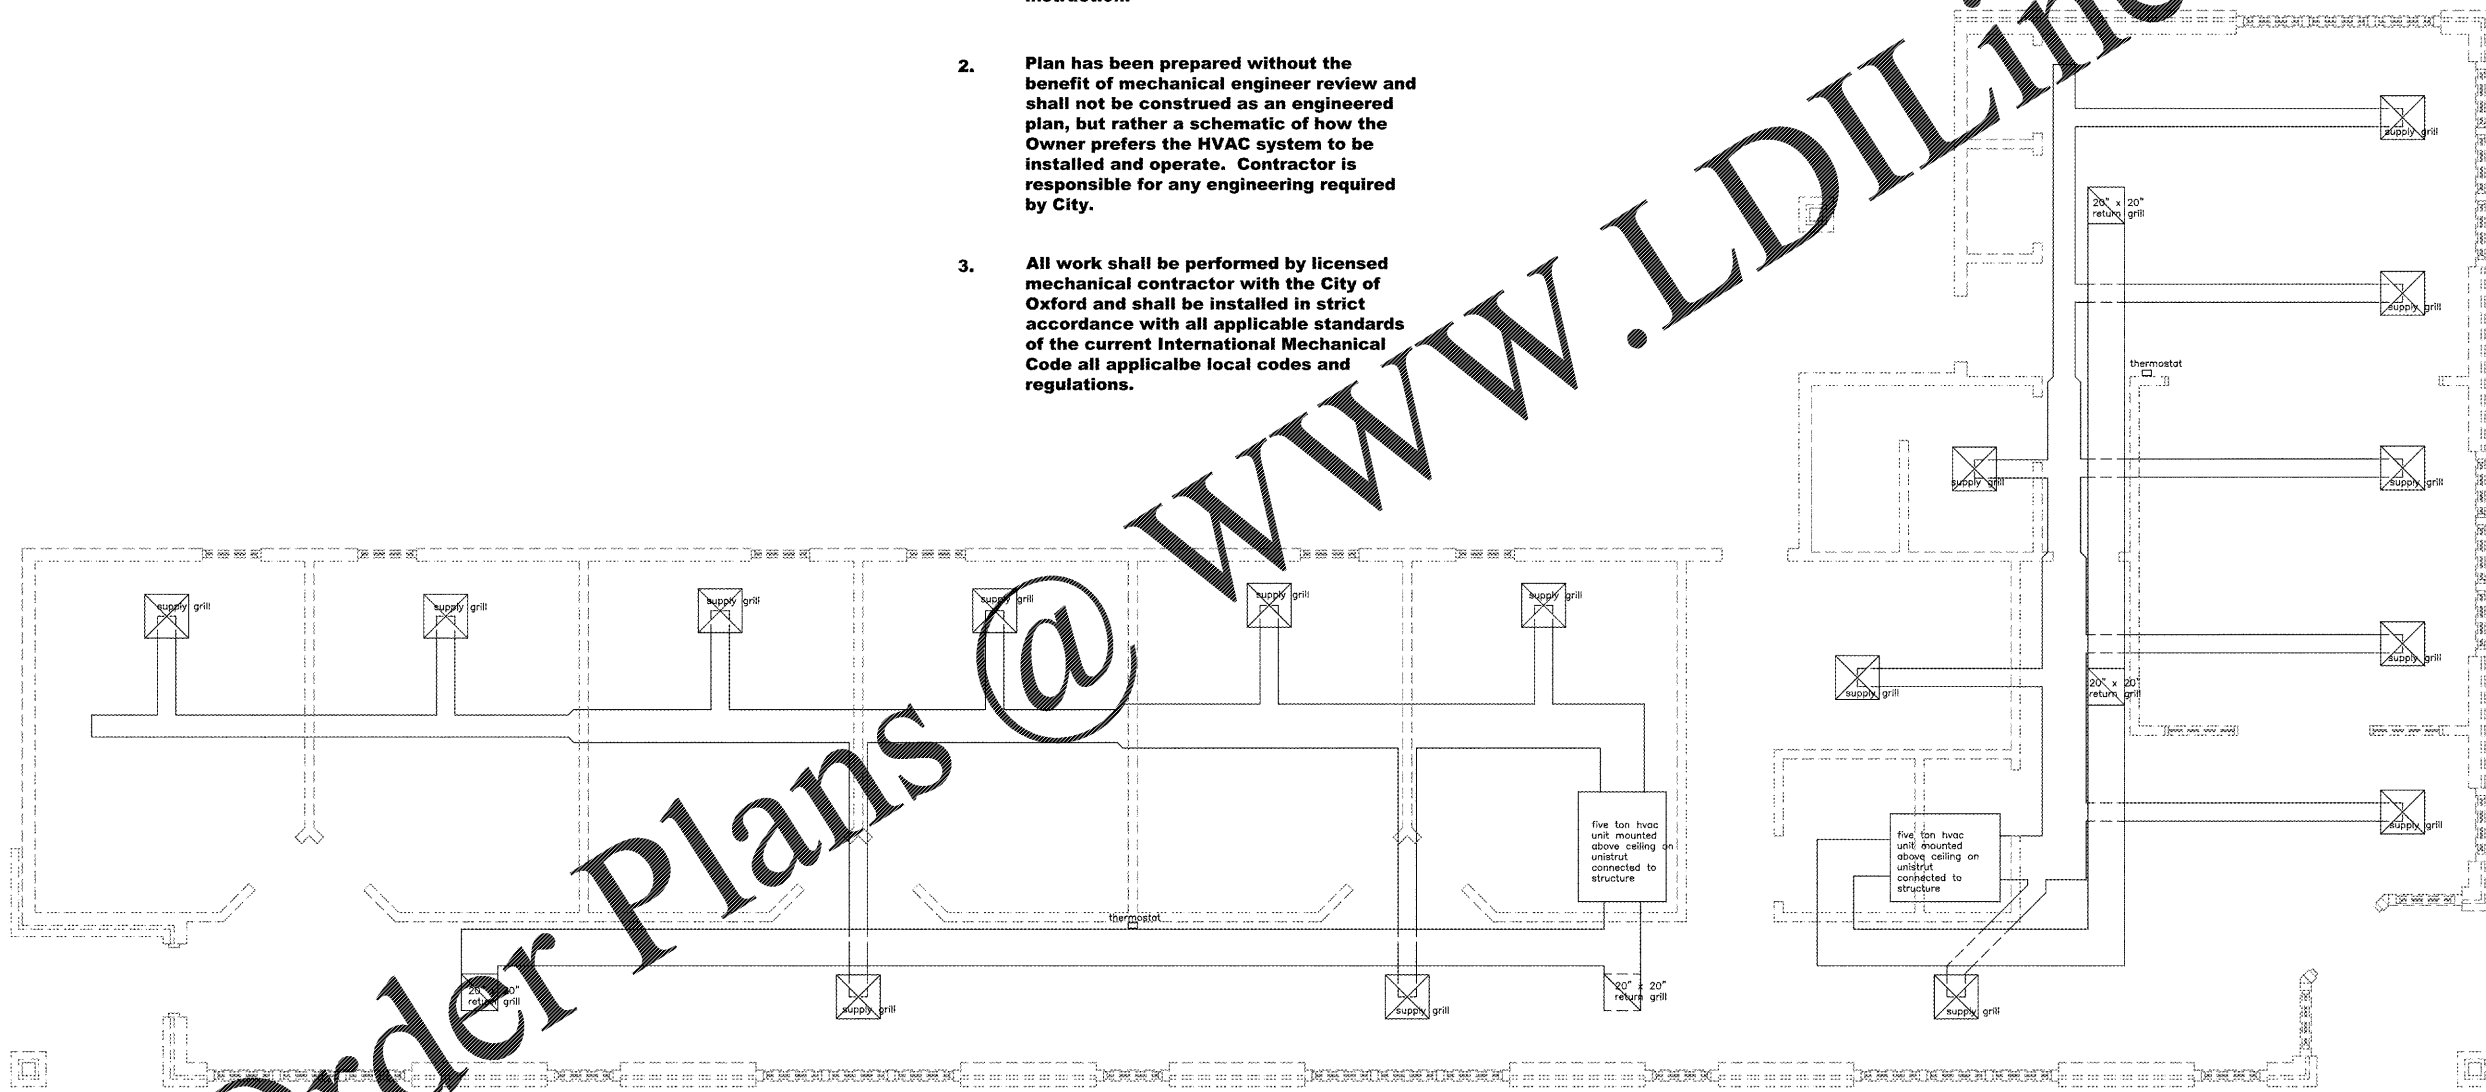

Architectural HVAC Plan

scale: 1/4" = 1'-0"

A New Facility for
House Counseling Services
Oxford, Alabama

Jay Jenkins architecture
301 Buckner Circle Anniston, Alabama 36205

DATE	REVISED
FILE	SHEET
	AM1